
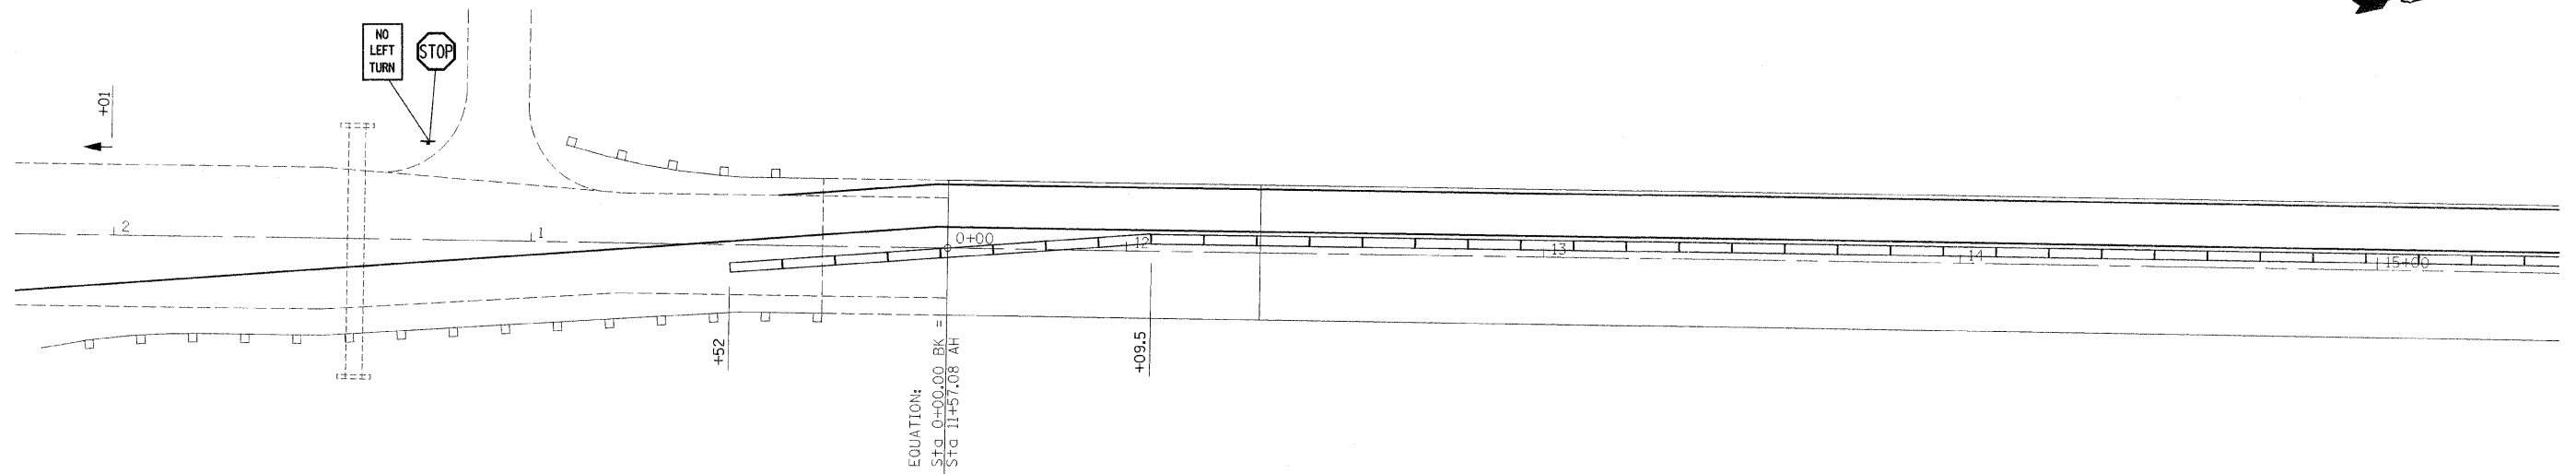


SUGGESTED SEQUENCE OF OPERATION

1. ERECT SIGNS, TRAFFIC SIGNALS, TEMPORARY BARRIERS, ECT. ACCORDING TO TRAFFIC CONTROL STANDARD 701321.
2. PLACE TEMPORARY PAVEMENT MARKING ACCORDING TO TRAFFIC CONTROL STANDARD 701321.
3. REMOVE THE EXISTING DECK BEAMS FOR STAGE II CONSTRUCTION.
4. PLACE NEW DECK BEAMS FOR STAGE II.

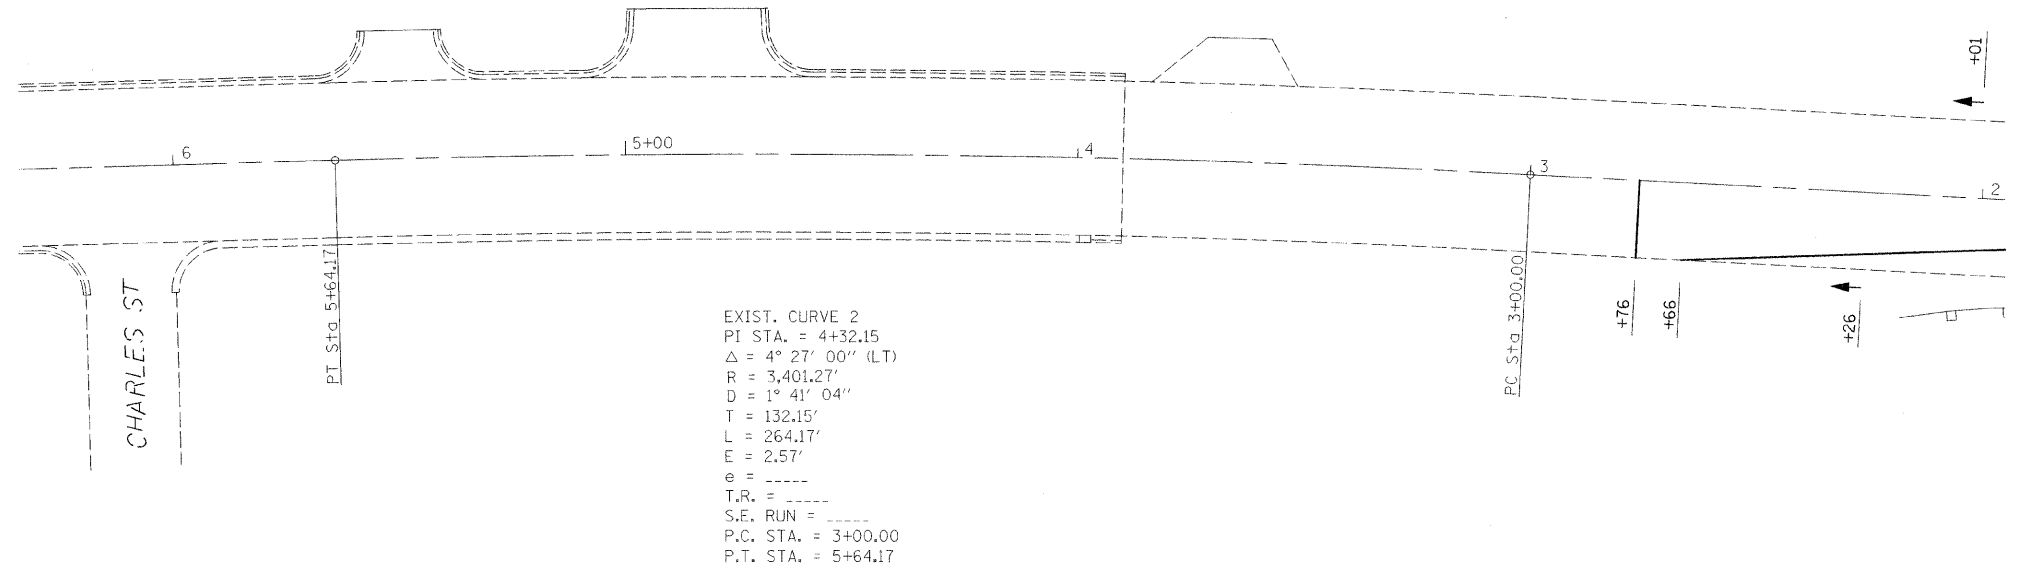

FILE NAME = c:\projects\74290d\stage2_74290.dgn	USER NAME = swartzw	DESIGNED - JDW	REVISED -	STATE OF ILLINOIS DEPARTMENT OF TRANSPORTATION	STAGE II CONSTRUCTION			F.A.P. RTE. 332	SECTION D7 BEAM REPAIR 2008-2	COUNTY LAWRENCE	TOTAL SHEETS 11	SHEET NO. 7
PLOT SCALE = 20.0000 ' / IN.	CHECKED -	DRAWN - RWS	REVISED -		SCALE: 20	SHEET NO. OF	SHEETS	STA. 8+00	TO STA. 15+00	CONTRACT NO. 74290		
PLOT DATE = 2/5/2008	DATE -	CHECKED -	REVISED -		FED. ROAD DIST. NO. ILLINOIS FED. AID PROJECT							
	DATE -	CHECKED -	REVISED -									