
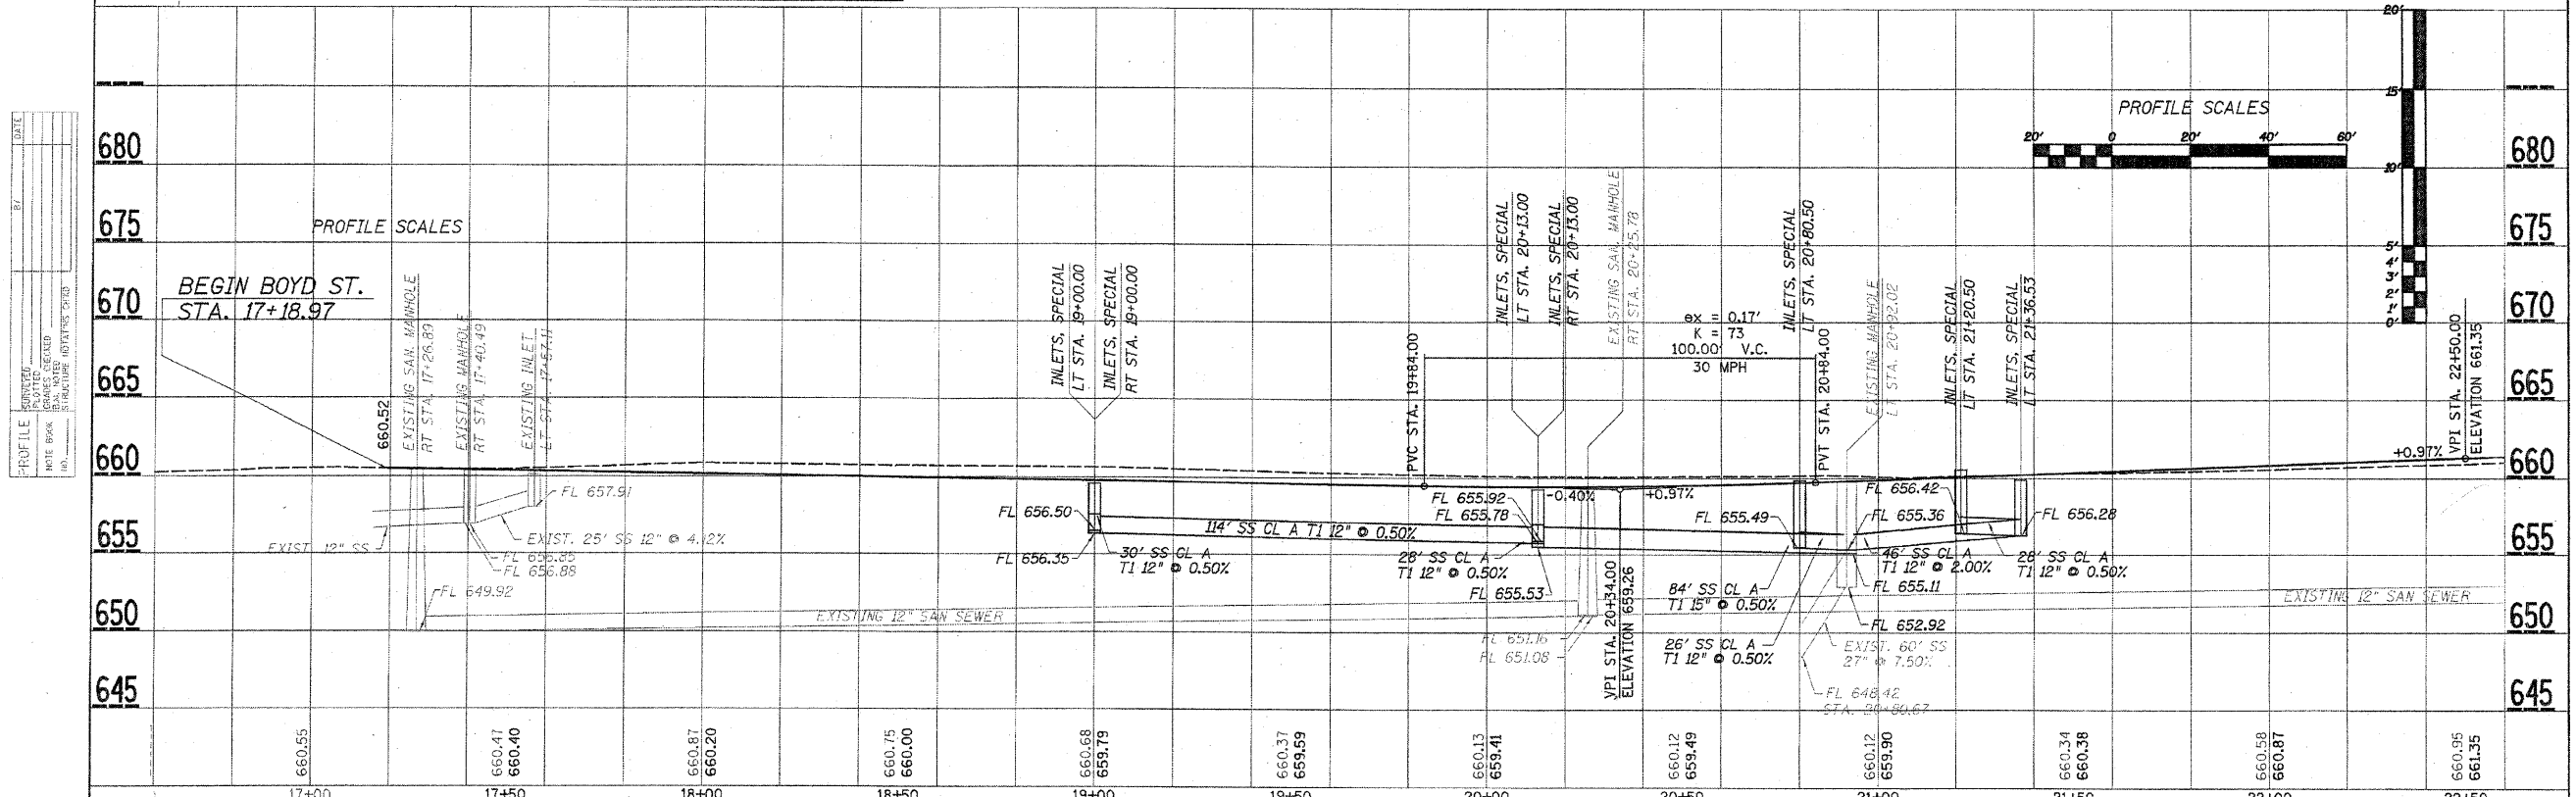


Contract 85429

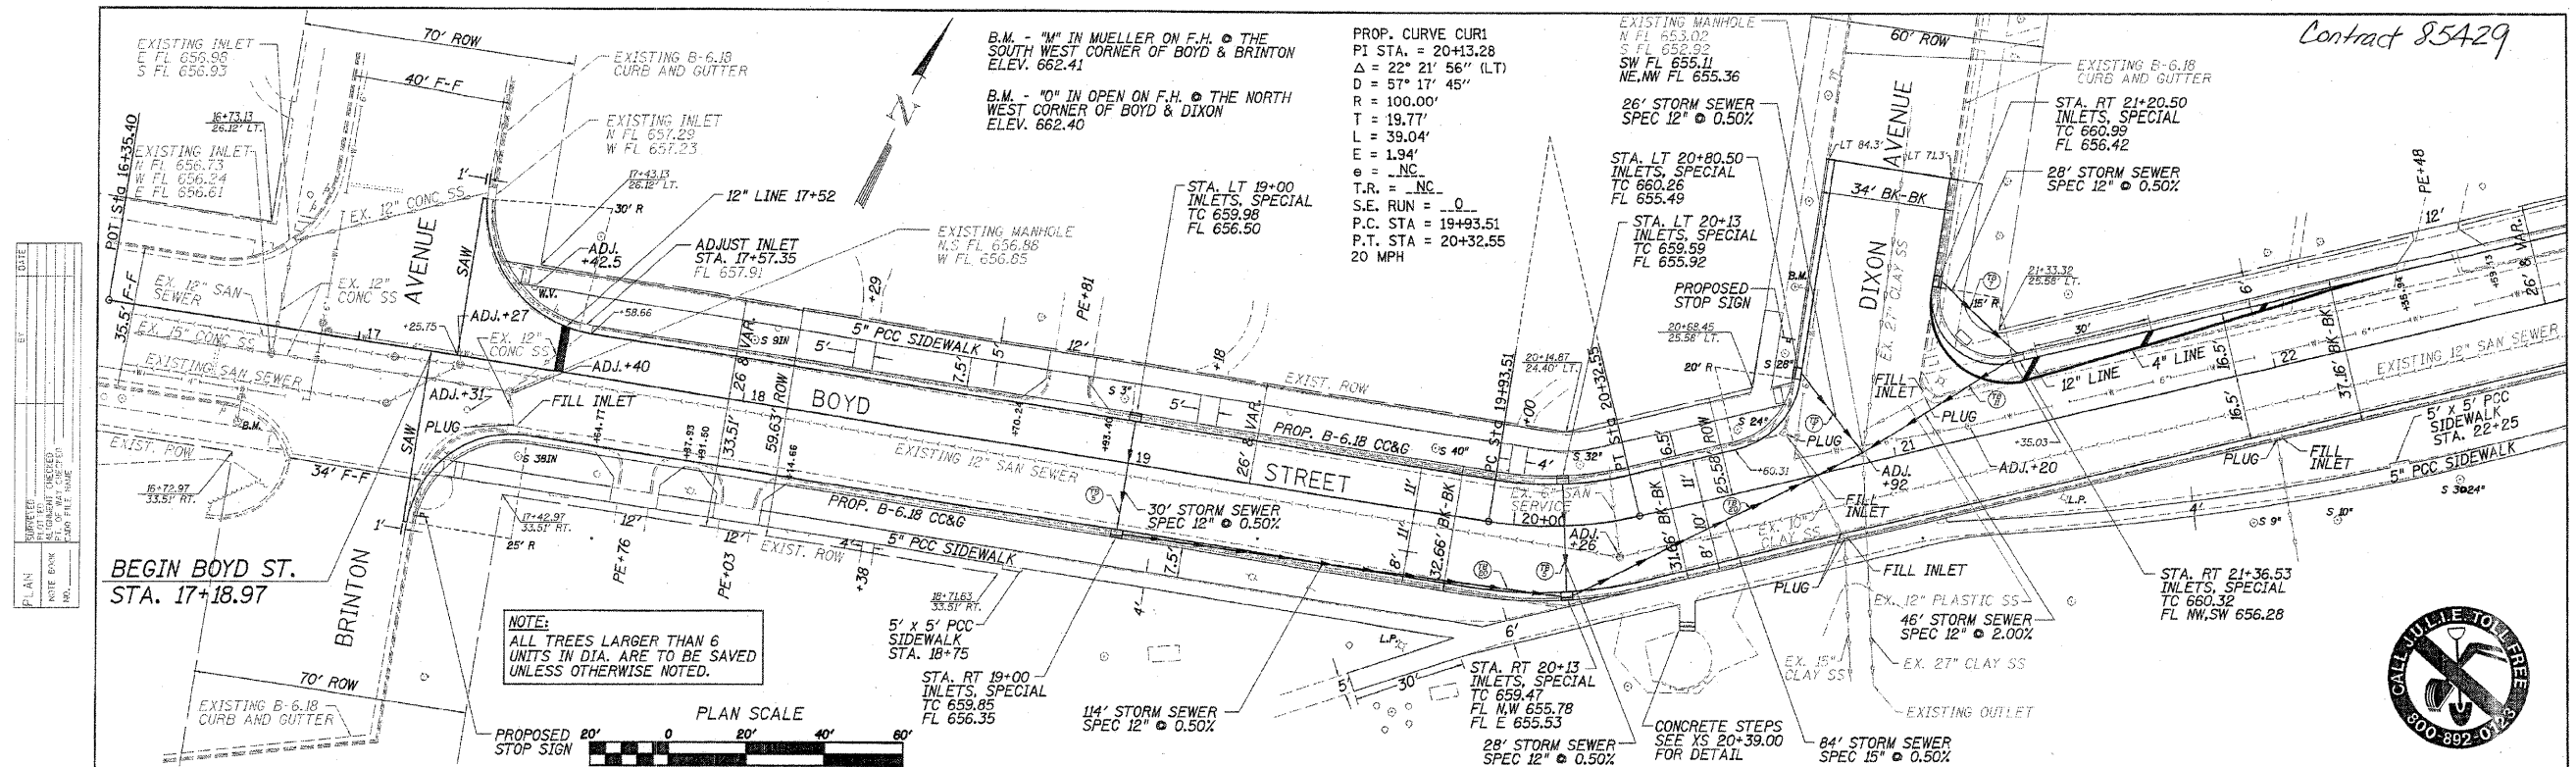

FILE NAME =	USER NAME = USER1	DESIGNED =	REVISED =	WILLETT, HOFMANN & ASSOCIATES, INC CONSULTING ENGINEERS DIXON, IL	BOYD STREET - PLAN AND PROFILE	F.A. RTE. =	SECTION	COUNTY	TOTAL SHEETS	SHEET NO.	
FILE # =	PLOT SCALE = 1/8"=1'-0"	DRAWN =	REVISED =			5482	07-00171-00-PP	LEE	25	9	
S:\Trans\1050007\pp\BOYD1.dgn	PLOT DATE = 1/20/11	CHECKED =	REVISED =			SCALE: SHEET NO. OF SHEETS STA. 17+00 TO STA. 22+50		CONTRACT NO. 85429			
		DATE =	REVISED =			FED. ROAD DIST. NO. ILLINOIS FED. AID PROJECT					