
 
 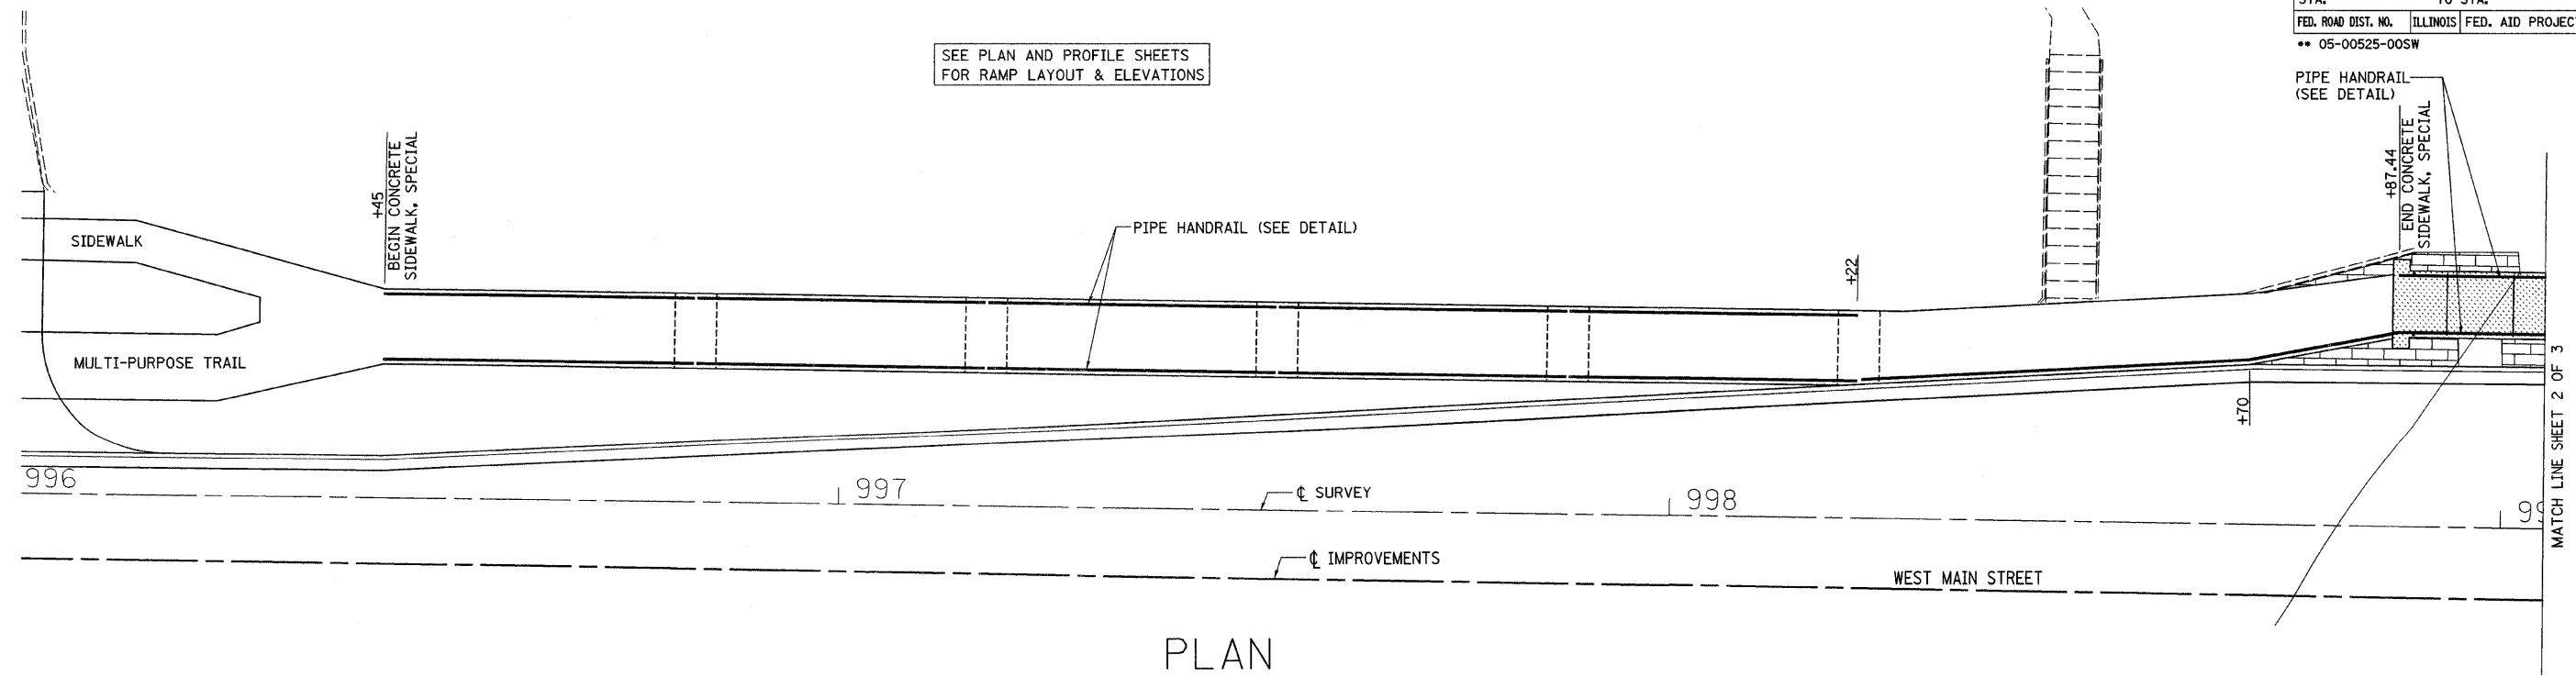


F.A. RTE.	SECTION	COUNTY	TOTAL SHEETS	SHEET NO.
	**	MACON	106	69
STA.		TO STA.		
FED. ROAD DIST. NO.	ILLINOIS	FED. AID PROJECT		
** 05-00525-00SW				

SEE PLAN AND PROFILE SHEETS FOR RAMP LAYOUT & ELEVATIONS



PLAN



REV. NO.	DESCRIPTION	BY	DATE	APPROVED
PIPE HANDRAIL LAYOUT				
DESIGN BWC	WEST MAIN STREET IMPROVEMENTS CITY OF DECATUR	SCALE		
DATE				
DRAWN MLD	BWC PROJECT NO. 009-0605	DATE		
DATE 12/07				
CHECKED	BWC BLANK, WESSELINK, COOK & ASSOCIATES, INC.	DATE		
DATE				
APPROVED	ARCHITECTS ENGINEERS 2623 EAST PERSHING ROAD DECATUR, IL 62524 (217) 428-0973 FAX (217) 428-8934	SHEET		
DATE		1 OF 3		