


| | |
|------|------------------------------|
| DATE | |
| BY | |
| PLAN | SURVEYED |
| | PLOTTED |
| | GRADES CHECKED |
| | ALIGNMENT CHECKED |
| | STRUCTURE NOT AT THIS OFFICE |
| | NO. _____ |
| | FILE NAME |

| | |
|---------|------------------------------|
| DATE | |
| BY | |
| PROFILE | SURVEYED |
| | PLOTTED |
| | GRADES CHECKED |
| | STRUCTURE NOT AT THIS OFFICE |
| | NO. _____ |
| | FILE NAME |


MATCH LINE STA. 128 + 00

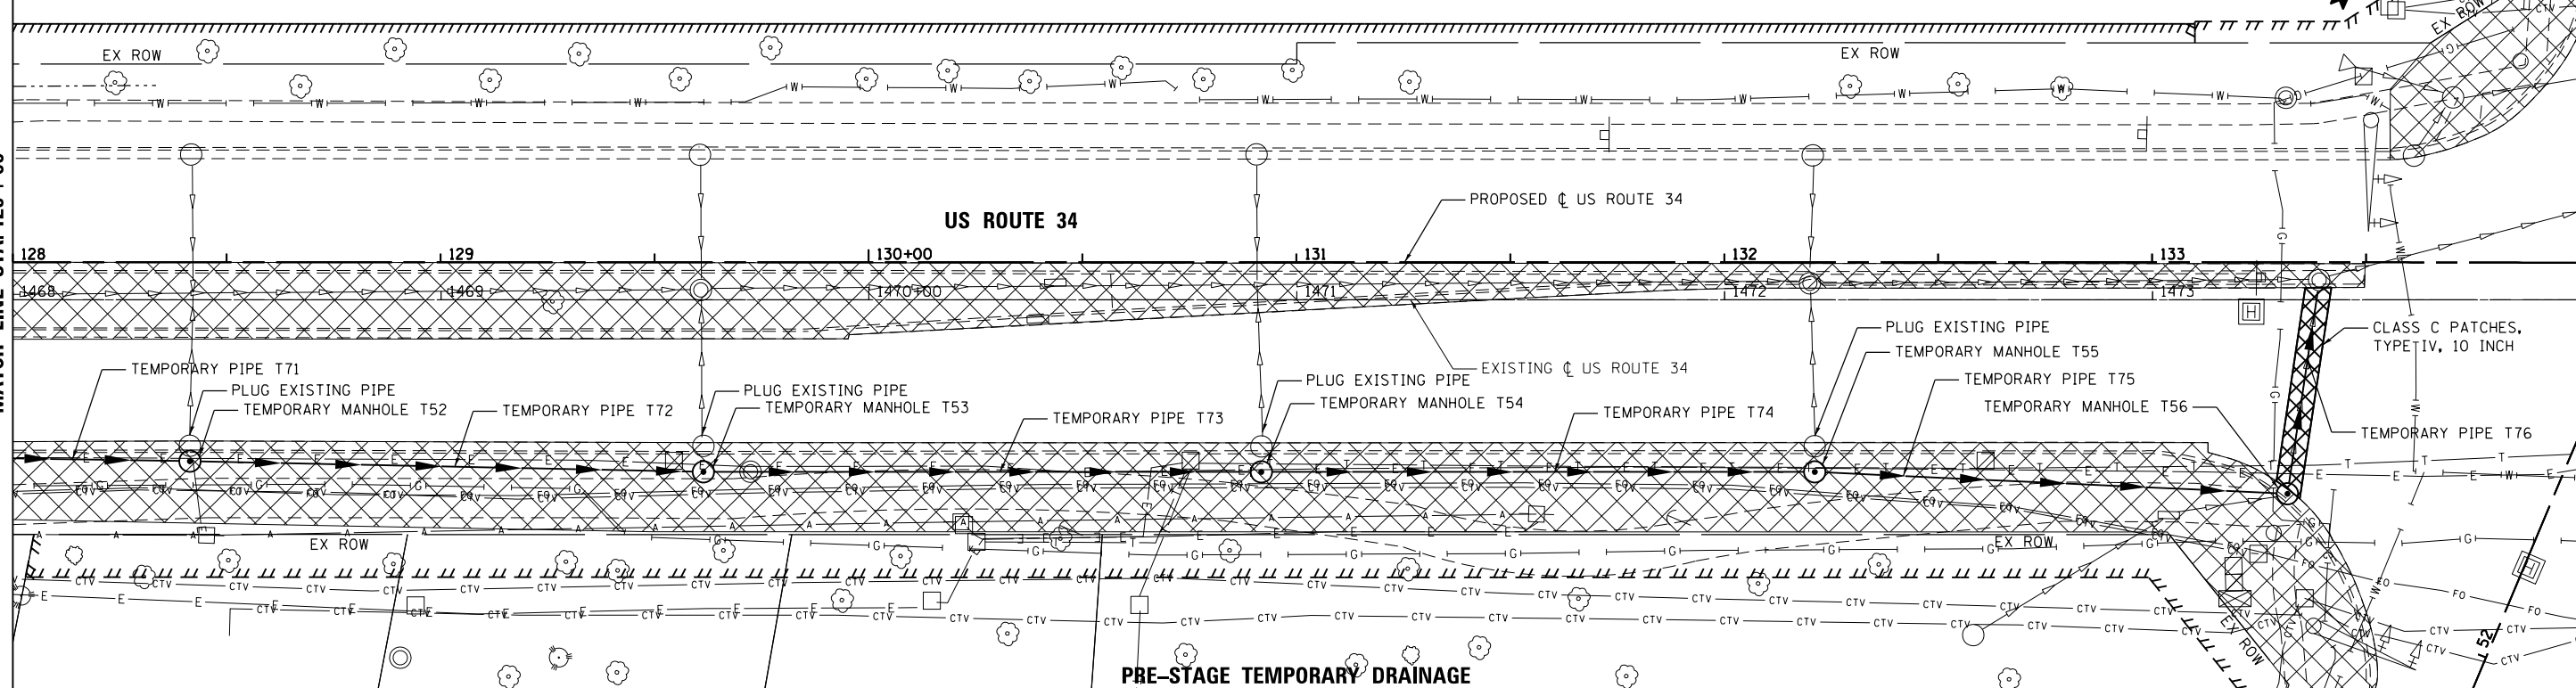

PRE-STAGE TEMPORARY DRAINAGE

THE COST TO CONNECT THE EXISTING STORM SEWER TO THE TEMPORARY STRUCTURE WILL BE INCLUDED IN THE COST OF THE TEMPORARY MANHOLE.

THE COST TO PLUG EXISTING PIPE CONNECTIONS SHALL BE INCLUDED IN THE COST OF THE TEMPORARY PIPE

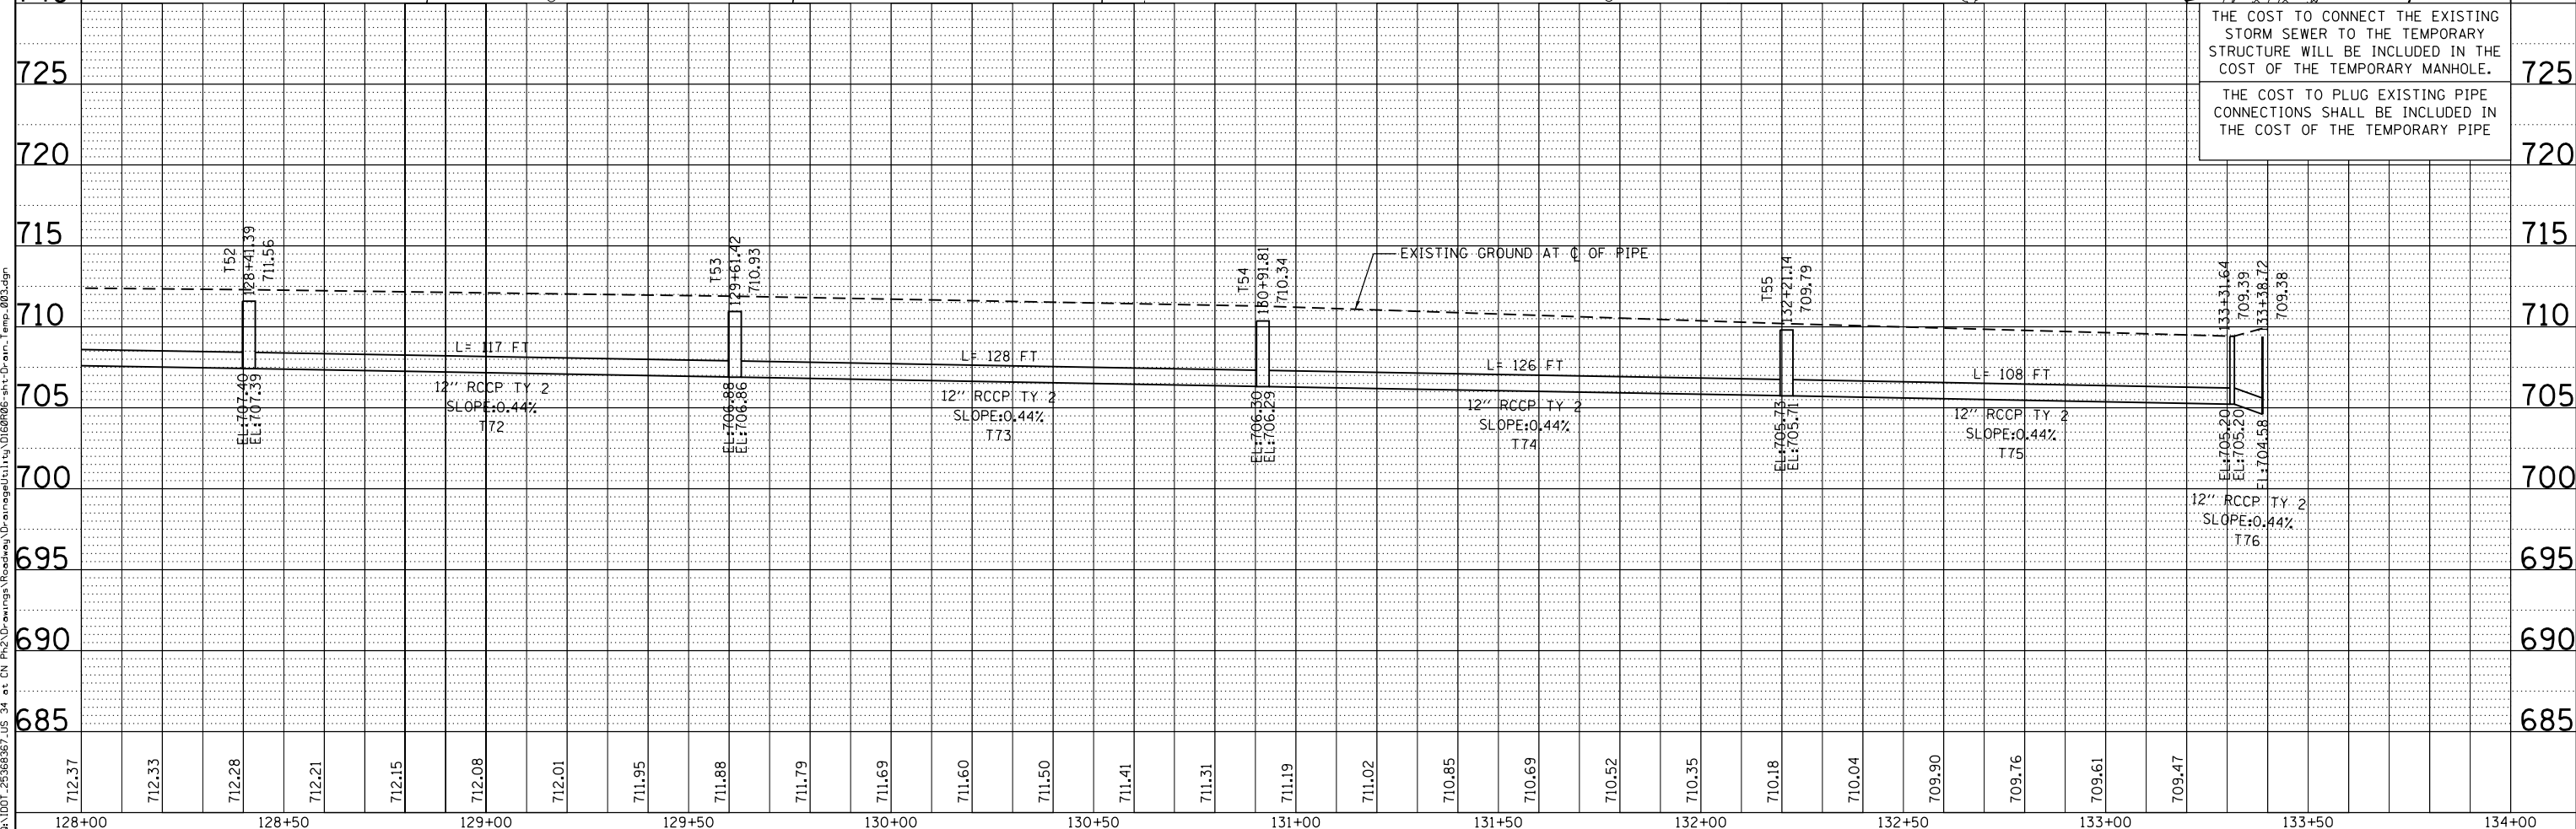

| | | | | | | | | | | | | | |
|--|-----------------------------|-------------------|-----------|---|--------------------------------|---------------------------|-------------------------|---------------|------------------|--------------------|--|--|--|
| | USER NAME = URS | DESIGNED - MB | REVISED - | STATE OF ILLINOIS DEPARTMENT OF TRANSPORTATION | TEMPORARY DRAINAGE PLAN | F.A.P. RTE. 311 | SECTION 652-A | COUNTY DuPAGE | TOTAL SHEETS 383 | SHEET NO. 66 | | | |
| | PLOT SCALE = 40.0000' / in. | CHECKED - SPF | REVISED - | | | SCALE: 20 | SHEET NO. 3 OF 3 SHEETS | STA. 128+00 | TO STA. 134+00 | CONTRACT NO. 60R06 | | | |
| | PLOT DATE = 02/28/2014 | DATE - 02/28/2014 | REVISED - | | | ILLINOIS FED. AID PROJECT | | | | | | | |
| | | | | | | | | | | | | | |