


PLAN	SURVEYED	BY	DATE
	PLOTTED		
	GRADES CHECKED		
	STRUCTURE NOTATIONS CHECKED		
	NO. _____		

PROFILE	SURVEYED	BY	DATE
	PLOTTED		
	GRADES CHECKED		
	STRUCTURE NOTATIONS CHECKED		
	NO. _____		

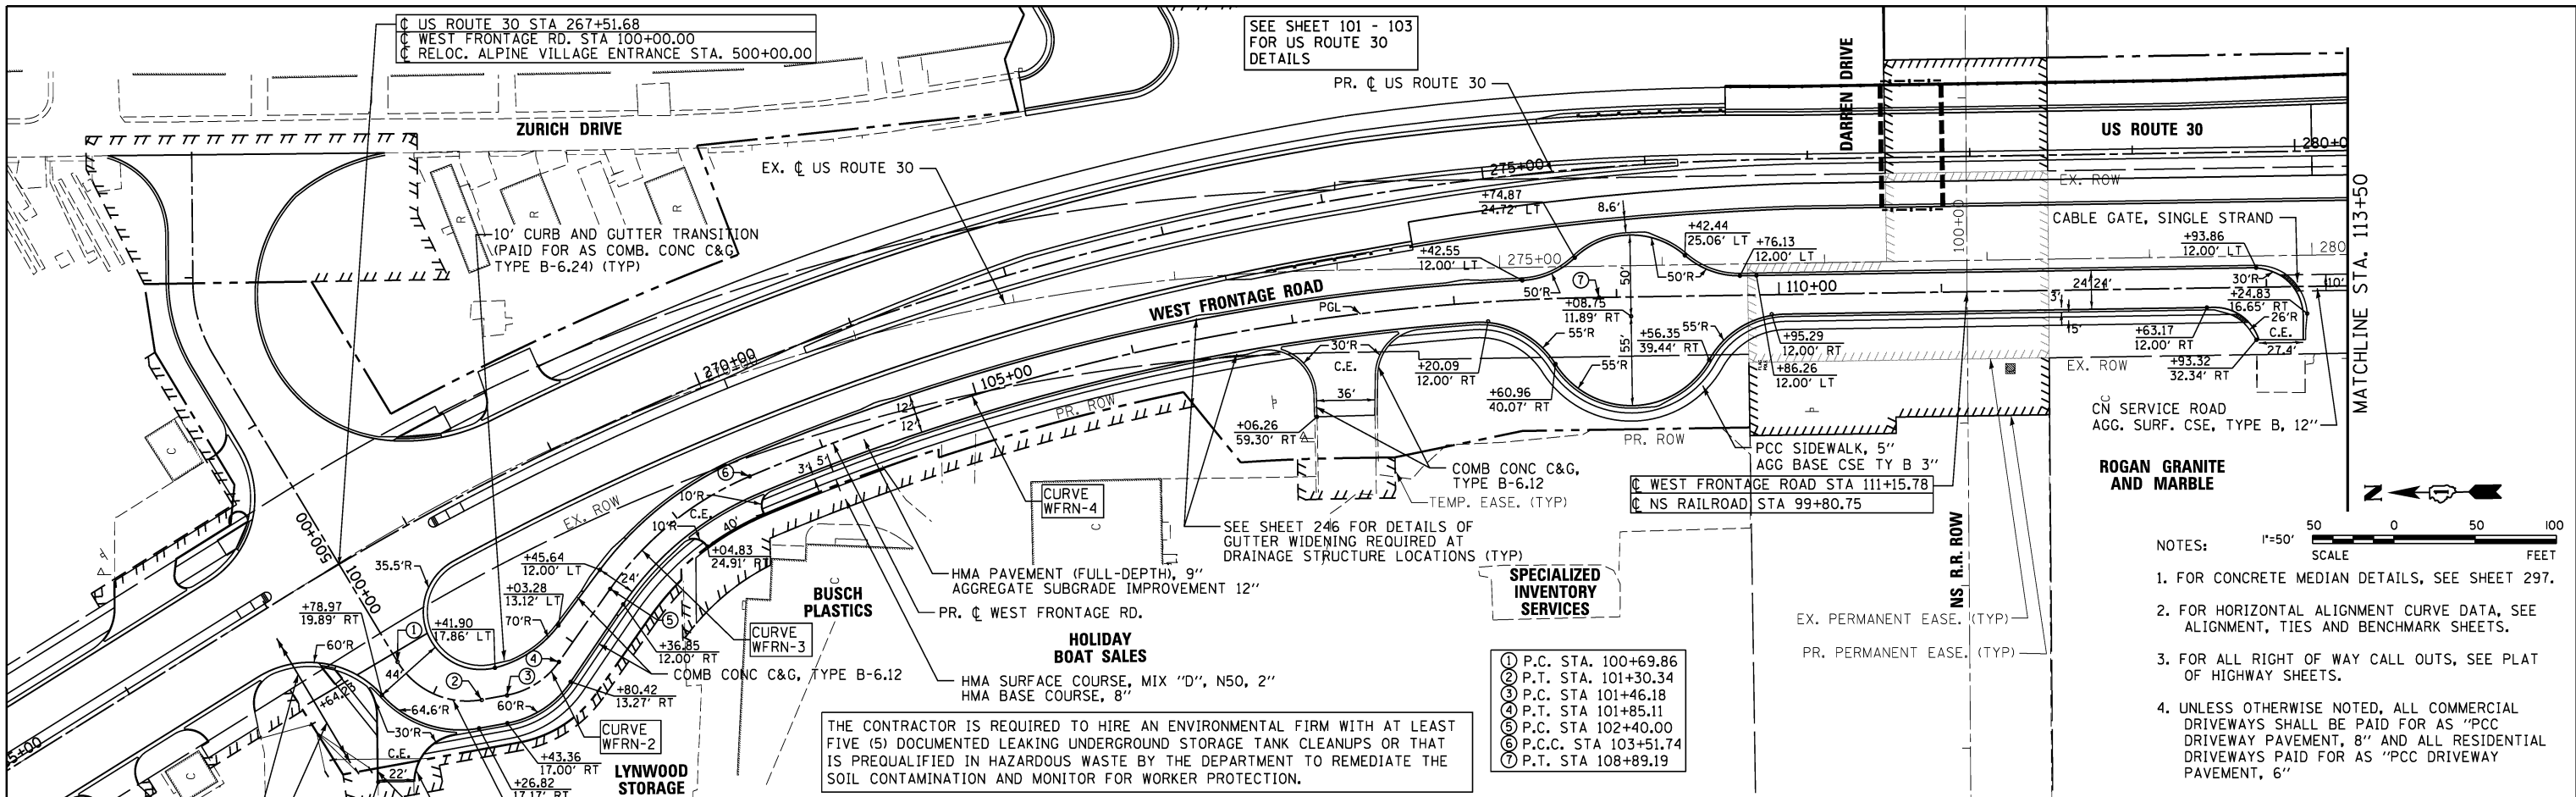


SEE SHEET 101 - 103 FOR US ROUTE 30 DETAILS

- SPECIALIZED INVENTORY SERVICES**
- ① P.C. STA. 100+69.86
 - ② P.T. STA. 101+30.34
 - ③ P.C. STA 101+46.18
 - ④ P.T. STA 101+85.11
 - ⑤ P.C. STA 102+40.00
 - ⑥ P.C.C. STA 103+51.74
 - ⑦ P.T. STA 108+89.19

THE CONTRACTOR IS REQUIRED TO HIRE AN ENVIRONMENTAL FIRM WITH AT LEAST FIVE (5) DOCUMENTED LEAKING UNDERGROUND STORAGE TANK CLEANUPS OR THAT IS PREQUALIFIED IN HAZARDOUS WASTE BY THE DEPARTMENT TO REMEDIATE THE SOIL CONTAMINATION AND MONITOR FOR WORKER PROTECTION.

- NOTES:
1. FOR CONCRETE MEDIAN DETAILS, SEE SHEET 297.
 2. FOR HORIZONTAL ALIGNMENT CURVE DATA, SEE ALIGNMENT, TIES AND BENCHMARK SHEETS.
 3. FOR ALL RIGHT OF WAY CALL OUTS, SEE PLAT OF HIGHWAY SHEETS.
 4. UNLESS OTHERWISE NOTED, ALL COMMERCIAL DRIVEWAYS SHALL BE PAID FOR AS "PCC DRIVEWAY PAVEMENT, 8" AND ALL RESIDENTIAL DRIVEWAYS PAID FOR AS "PCC DRIVEWAY PAVEMENT, 6"

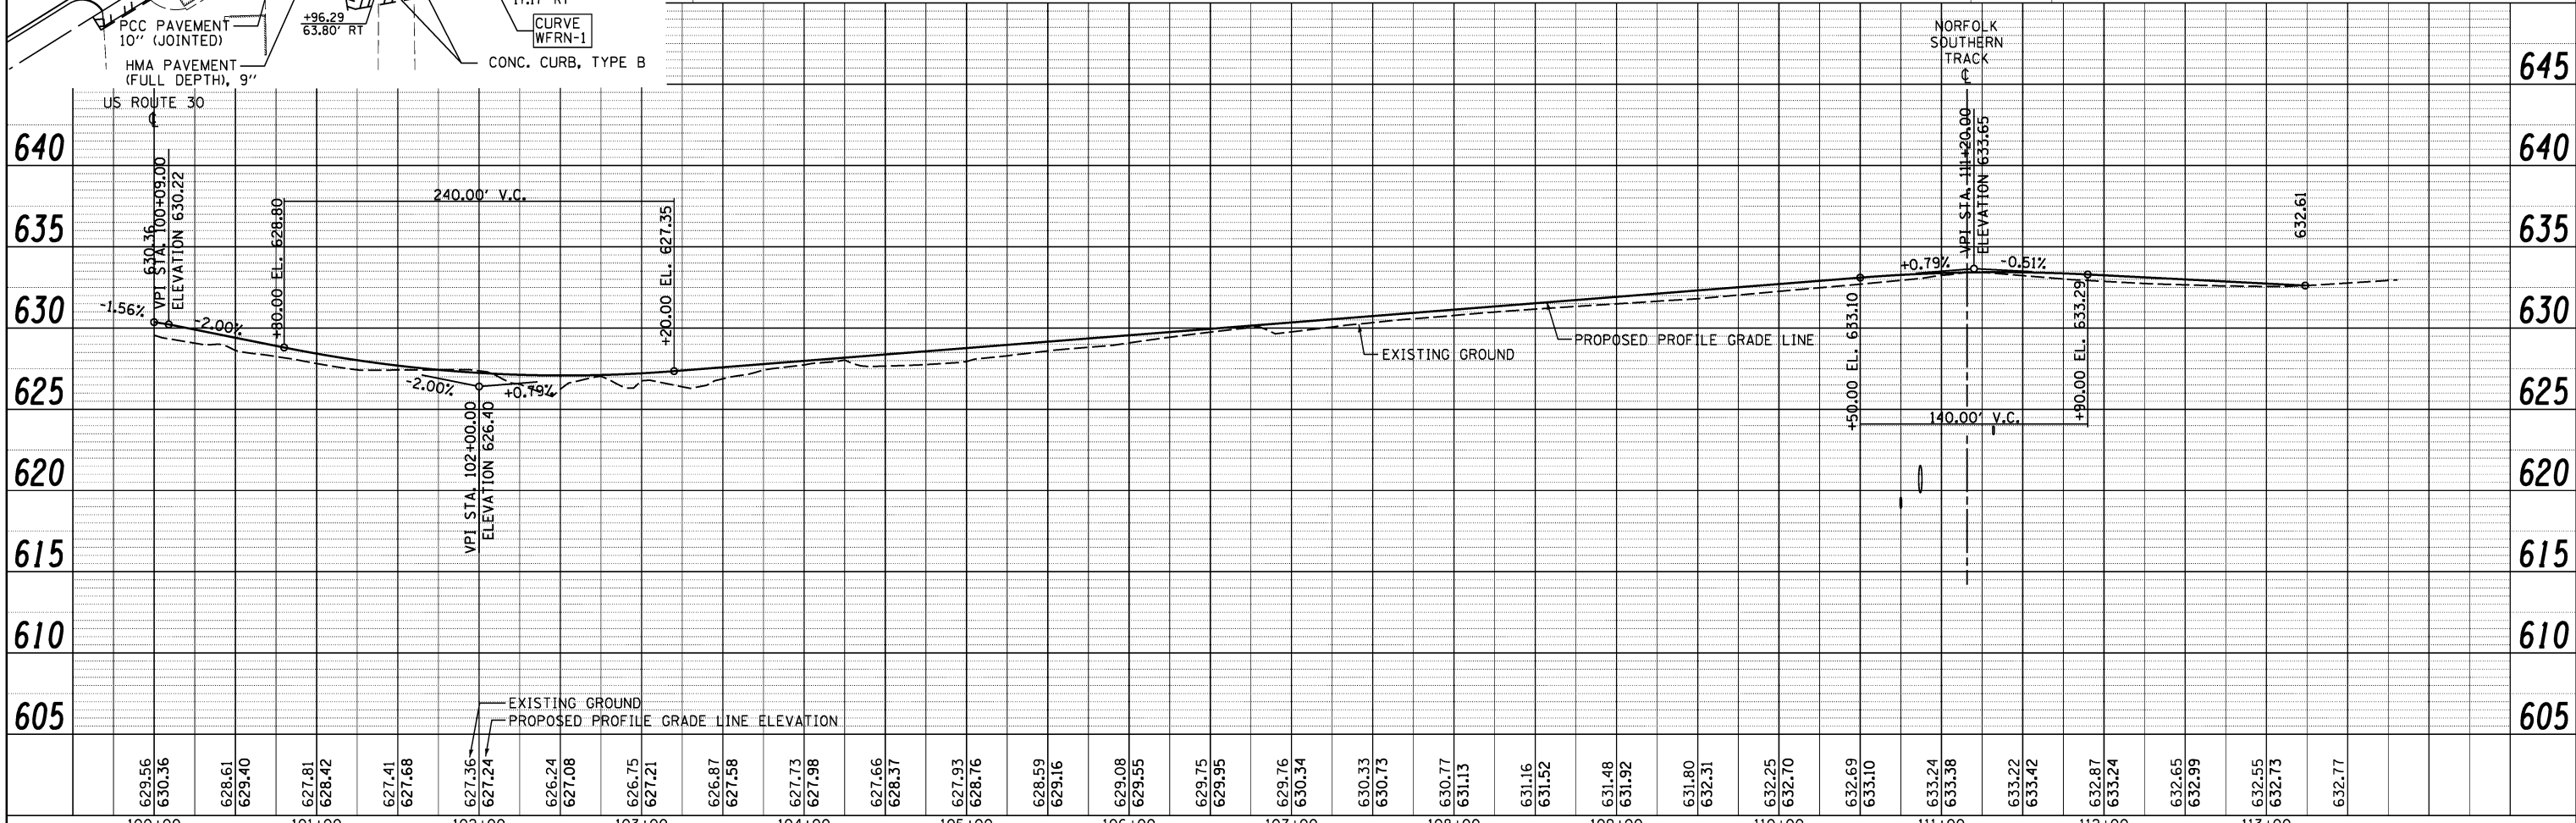

<p>V3 Companies 7325 Janes Avenue Woodridge, IL 60517 630.724.9200 phone 630.724.9202 fax www.v3co.com</p>	USER NAME = dsherman	DESIGNED - DTE	REVISED -	<p>STATE OF ILLINOIS DEPARTMENT OF TRANSPORTATION</p> <p>WEST FRONTAGE ROAD - NORTH PLAN AND PROFILE STATION 100+00 TO STATION 113+75.52</p> <p>SCALE: 1" = 50' SHEET NO. 5 OF 7 SHEETS STA. 100+00 TO STA. 113+75.52</p>	<table border="1"> <tr><td>F.A.P. RTE.</td><td>SECTION</td><td>COUNTY</td><td>TOTAL SHEETS</td><td>SHEET NO.</td></tr> <tr><td>353</td><td>11-Y-A</td><td>COOK</td><td>354</td><td>106</td></tr> <tr><td colspan="4"></td><td>CONTRACT NO. 60R19</td></tr> <tr><td colspan="5">ILLINOIS FED. AID PROJECT</td></tr> </table>	F.A.P. RTE.	SECTION	COUNTY	TOTAL SHEETS	SHEET NO.	353	11-Y-A	COOK	354	106					CONTRACT NO. 60R19	ILLINOIS FED. AID PROJECT				
	F.A.P. RTE.	SECTION	COUNTY			TOTAL SHEETS	SHEET NO.																		
	353	11-Y-A	COOK			354	106																		
						CONTRACT NO. 60R19																			
ILLINOIS FED. AID PROJECT																									
PLOT SCALE = 50'	CHECKED - VJD	REVISED -																							
PLOT DATE = 3/27/2014	DATE - 03/28/2014	REVISED -																							