
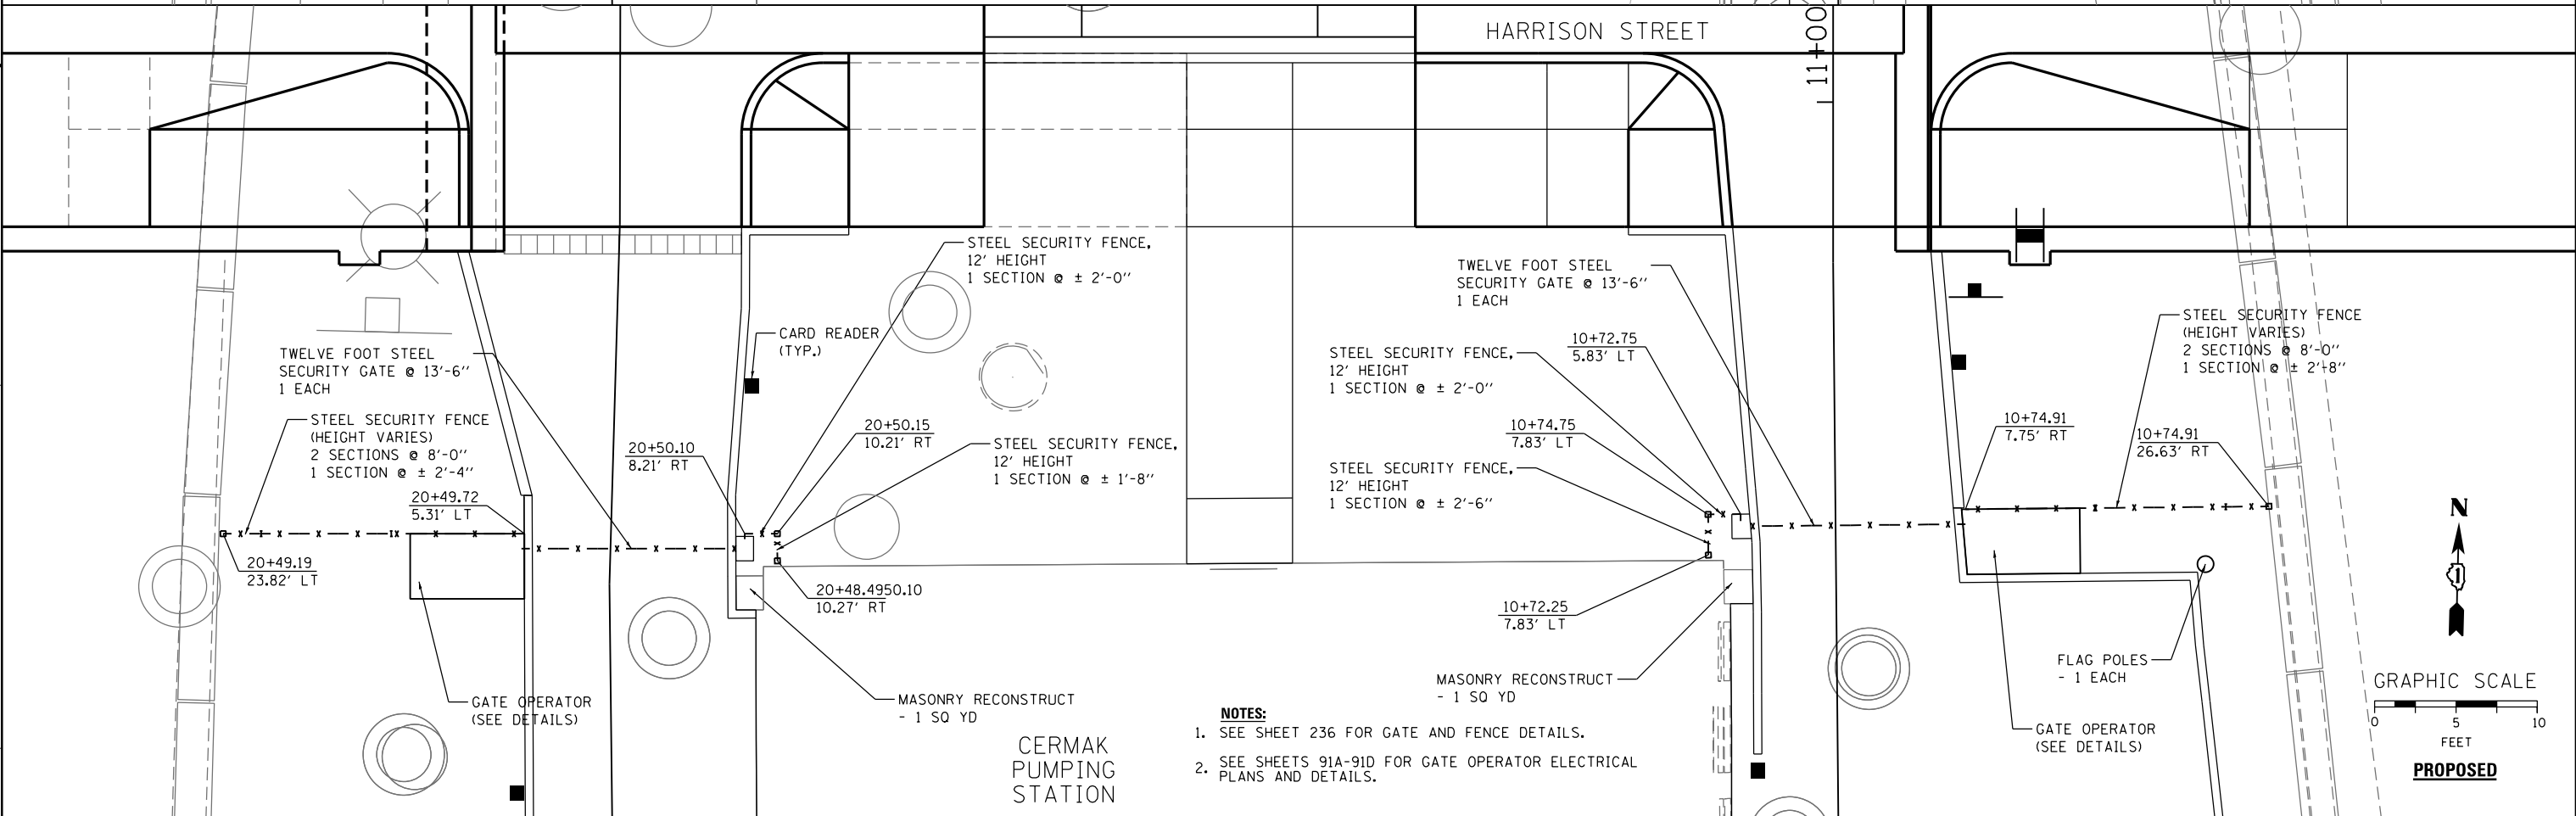


FILE PATH = p:\388035-p\m\1\escom\line\local\PAEC\DWG\Documents\01\_Americas\Transportation\62629938\_Circle Phase\_1\000\_CAD\005\_Roadway\_Sheets\60W71\_Contract\0160W71-sh-Fence-01

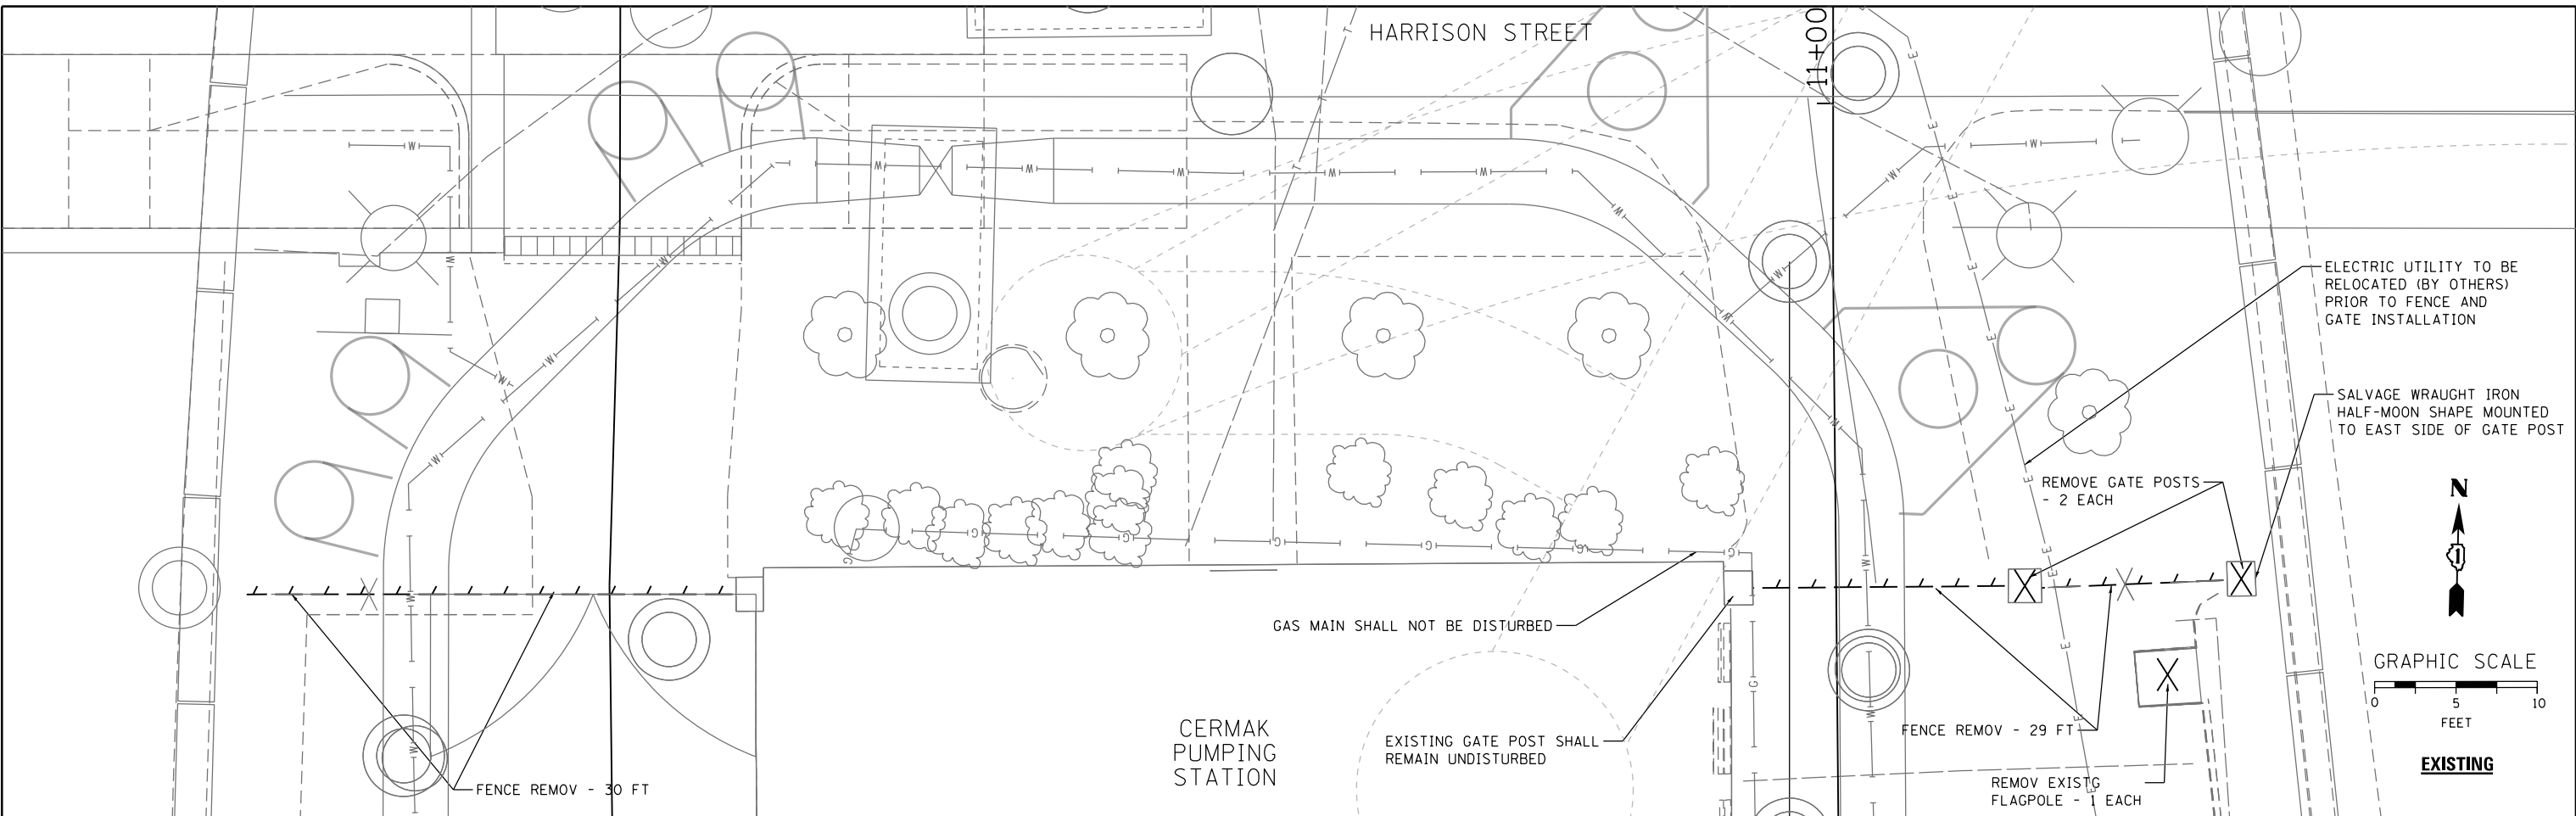

- NOTES:**
- SEE SHEET 236 FOR GATE AND FENCE DETAILS.
  - SEE SHEETS 91A-91D FOR GATE OPERATOR ELECTRICAL PLANS AND DETAILS.

**STATE OF ILLINOIS  
DEPARTMENT OF TRANSPORTATION**

**FENCING PLAN  
AT CERMAK PUMPING STATION**



D160W71-sh-Fence-01  
 USER NAME = Cooper-M2  
 PLOT SCALE = 10.0000' / 1" IN.  
 PLOT DATE = 2/21/2014

DESIGNED - MSC	REVISED -
DRAWN - MSC	REVISED -
CHECKED - DBM	REVISED -
DATE - 02/19/14	REVISED -

SCALE: 1" = 10'    SHEET 1 OF 1 SHEETS    STA.    TO STA.

F.A.I. R.T.E.	SECTION	COUNTY	TOTAL SHEETS	SHEET NO.
90/94/290	2013-036R	COOK	256	54
CONTRACT NO. 60W71				
ILLINOIS FED. AID PROJECT				