


2/13/2014 10:46:05 AM c:\pwworking\acem00\myer.sc\d0257059\DIGOW71-sht-Light-08.dgn

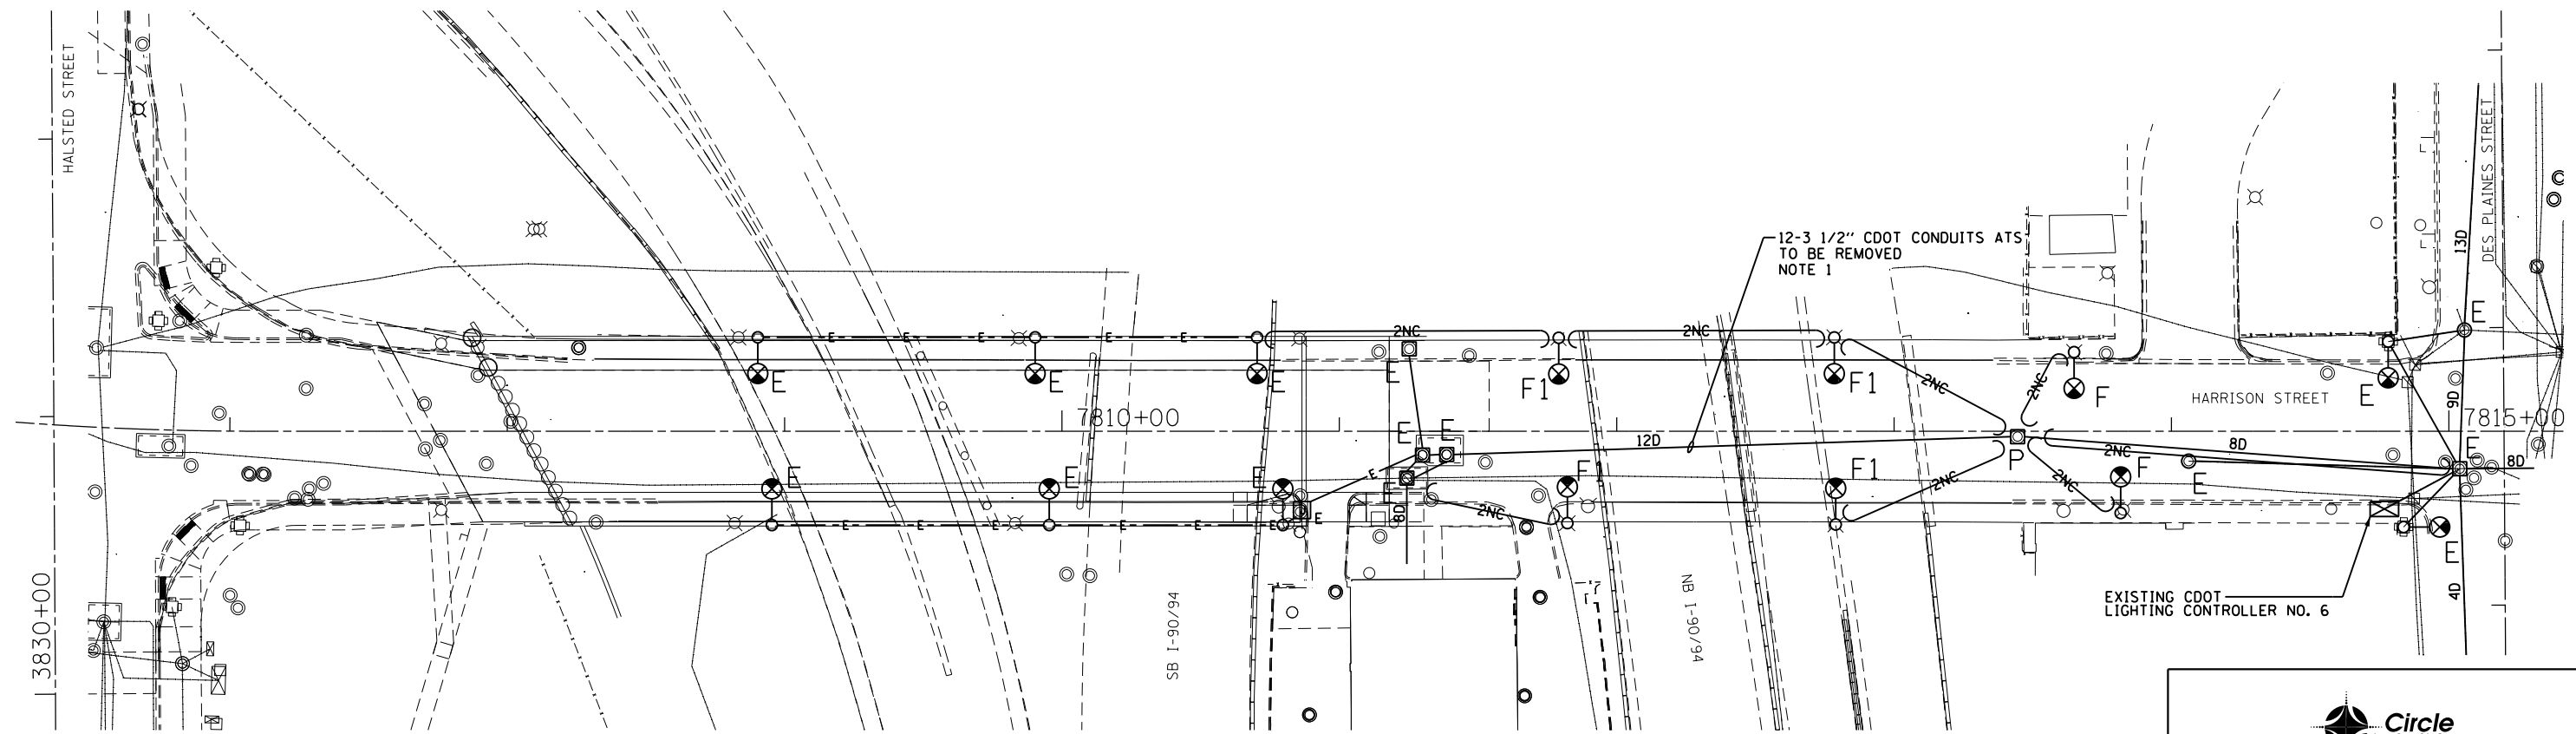

- | | |
|------|---|
| "E" | EXISTING TO REMAIN |
| "F" | REMOVE AND SALVAGE EXISTING STEEL POLE, LUMINAIRE AND MAST ARM. BREAKDOWN CONCRETE FOUNDATION COMPLETE. |
| "F1" | REMOVE AND SALVAGE EXISTING STEEL POLE, LUMINAIRE AND MAST ARM. |
| "G" | REMOVE LUMINAIRE AND MAST ARM, ANCHOR BASE STEEL POLE AND CONCRETE FOUNDATION TO BE REMOVED WITH TRAFFIC SIGNAL WORK. |
| "P" | REMOVE EXISTING MANHOLE COMPLETE |

NOTES:

- THE EXISTING CDOT CONDUITS ATTACHED TO THE UNDERSIDE OF THE BRIDGE STRUCTURE MAY CONTAIN ASBESTOS MATERIALS. THE CONDUITS SHALL BE REMOVED AND DISPOSED OF PROPERLY PRIOR TO THE BRIDGE DEMOLITION. CONDUITS TESTED AND CONFIRMED TO CONTAIN ASBESTOS MUST BE REMOVED IN ACCORDANCE WITH THE SPECIAL PROVISION "REMOVAL OF ASBESTOS CEMENT CONDUIT". ASBESTOS CONDUIT REMOVAL SHALL BE PAID FOR UNDER THE "REMOVAL OF ASBESTOS CEMENT CONDUIT" PAY ITEM.

FOR CONDUIT AND FOUNDATION PLANS SEE DRAWING NO. E-06.
 FOR LIGHTING CABLE AND EQUIPMENT INSTALLATION PLANS SEE DRAWING NO. E-07.

DATE	REVISION
CITY OF CHICAGO DEPARTMENT OF TRANSPORTATION DIVISION OF ENGINEERING	
CONSULTANT: AECOM	
WORK ORDER NO. _____	DATE _____
COST ALLOCATION ACCOUNT _____	
APPROPRIATION ACCOUNT _____	MATERIAL _____ LABOR _____
EAST HARRISON STREET LIGHTING REMOVAL PLAN	
CITY OF CHICAGO DEPT. OF TRANSPORTATION DIVISION OF ELECTRICAL OPERATIONS	
DRAFTSMAN: CAM	ENGINEER: WDS
SUPERVISING ENGINEER: WDS	ELEC. DESIGN ENGR.
ENGINEER OF ELECTRICITY:	
GEN'L SUPT. OF ELECTRICITY:	
DEPUTY COMMISSIONER:	
SIZE: 22" 34"	SCALE: 1" = 30'
DATE: 02/19/14	DATE: 12/06/13
C.D.O.T. PROJECT NO.:	DWG. NO.:
	8 OF 19

E-08