


CABLE TRENCH

CONDUIT TRENCH

NOTE
 EXCESS SOIL FROM TRENCH TO BE COMPLETELY REMOVED FROM SITE AS SOON AS PRACTICABLE.
 BLACK DIRT TO BE TAMPED & THOROUGHLY COMPACTED AS SHOWN.

STANDARD METHOD FOR BACKFILLING CABLE & CONDUIT TRENCHES IN SODDED PARKWAY & LAWNS

CITY OF CHICAGO			
DEPT. OF STREETS & SANITATION			
DIVISION OF ELECTRICAL ENGINEERING			
REVISION	DRAWN	CHECKED	ENGINEER
A	W. E. HARP	M. J. HINE	J. O'CONNOR
B	ENGR. IN CHARGE		DRG. NO.
C	Supt. of Const.		579
D	Supt. of Const.		
E	Supt. of Const.		
F	Supt. of Const.		
G	Supt. of Const.		
H	SIZE: 8 1/2 x 14	SCALE: N	DATE: 7-14-61

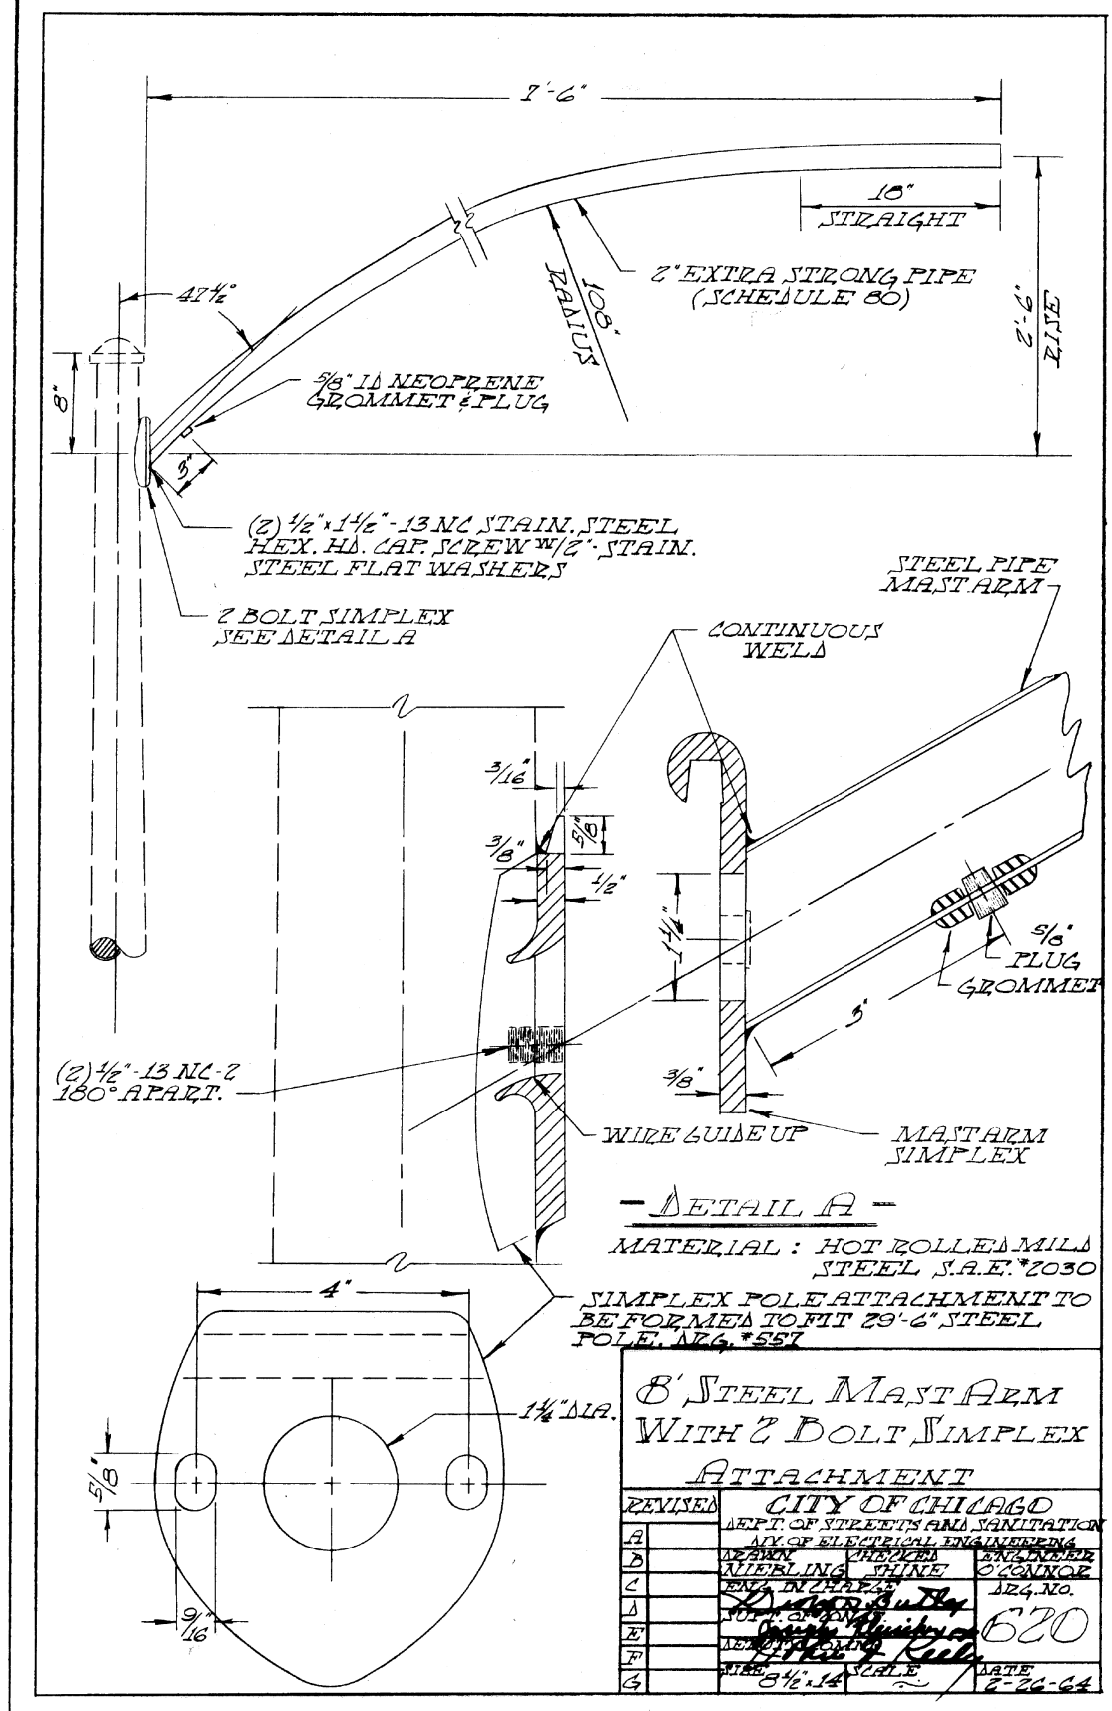

DETAIL A
 MATERIAL: HOT ROLLED MILD STEEL S.A.E. #2030
 SIMPLEX POLE ATTACHMENT TO BE FORMED TO FIT 29'-6" STEEL POLE, A24 #557

8' STEEL MAST ARM WITH 2 BOLT SIMPLEX ATTACHMENT

REVISED	CITY OF CHICAGO	
A	DEPT. OF STREETS AND SANITATION	DATE
B	DIVISION OF ELECTRICAL ENGINEERING	SCALE
C	DESIGNED BY	DATE
D	CHECKED BY	SCALE
E	ENGINEER	DATE
F	ENGR. IN CHARGE	SCALE
G	SUPV. OF CONST.	DATE

FILE PATH = p:\388935\pmt\l\escomonline\local\p\AEC\DWG\Documents\01_Americas\Transportation\66269938_Circle\Phase 1\1000_CAD\016_Electrical\Sheets\60W71-Contract\160W71-sht-Light-12



D160W71-sht-Light-12
 USER NAME = myersc
 PLOT SCALE = 1:8000 / 1 in.
 PLOT DATE = 12/18/2013

DESIGNED - WDS
 DRAWN - CAM
 CHECKED - WDS
 DATE - 12/20/13

REVISED -
 REVISED -
 REVISED -
 REVISED -

STATE OF ILLINOIS
 DEPARTMENT OF TRANSPORTATION

MISCELLANEOUS ELECTRICAL DETAILS

SCALE: N.T.S. SHEET 12 OF 19 SHEETS STA. TO STA.

F.A.I. RTE.	SECTION	COUNTY	TOTAL SHEETS	SHEET NO.
90/94/290	2013-036R	COOK	256	84
CONTRACT NO. 60W71				
ILLINOIS FED. AID PROJECT				