


DAN RYAN

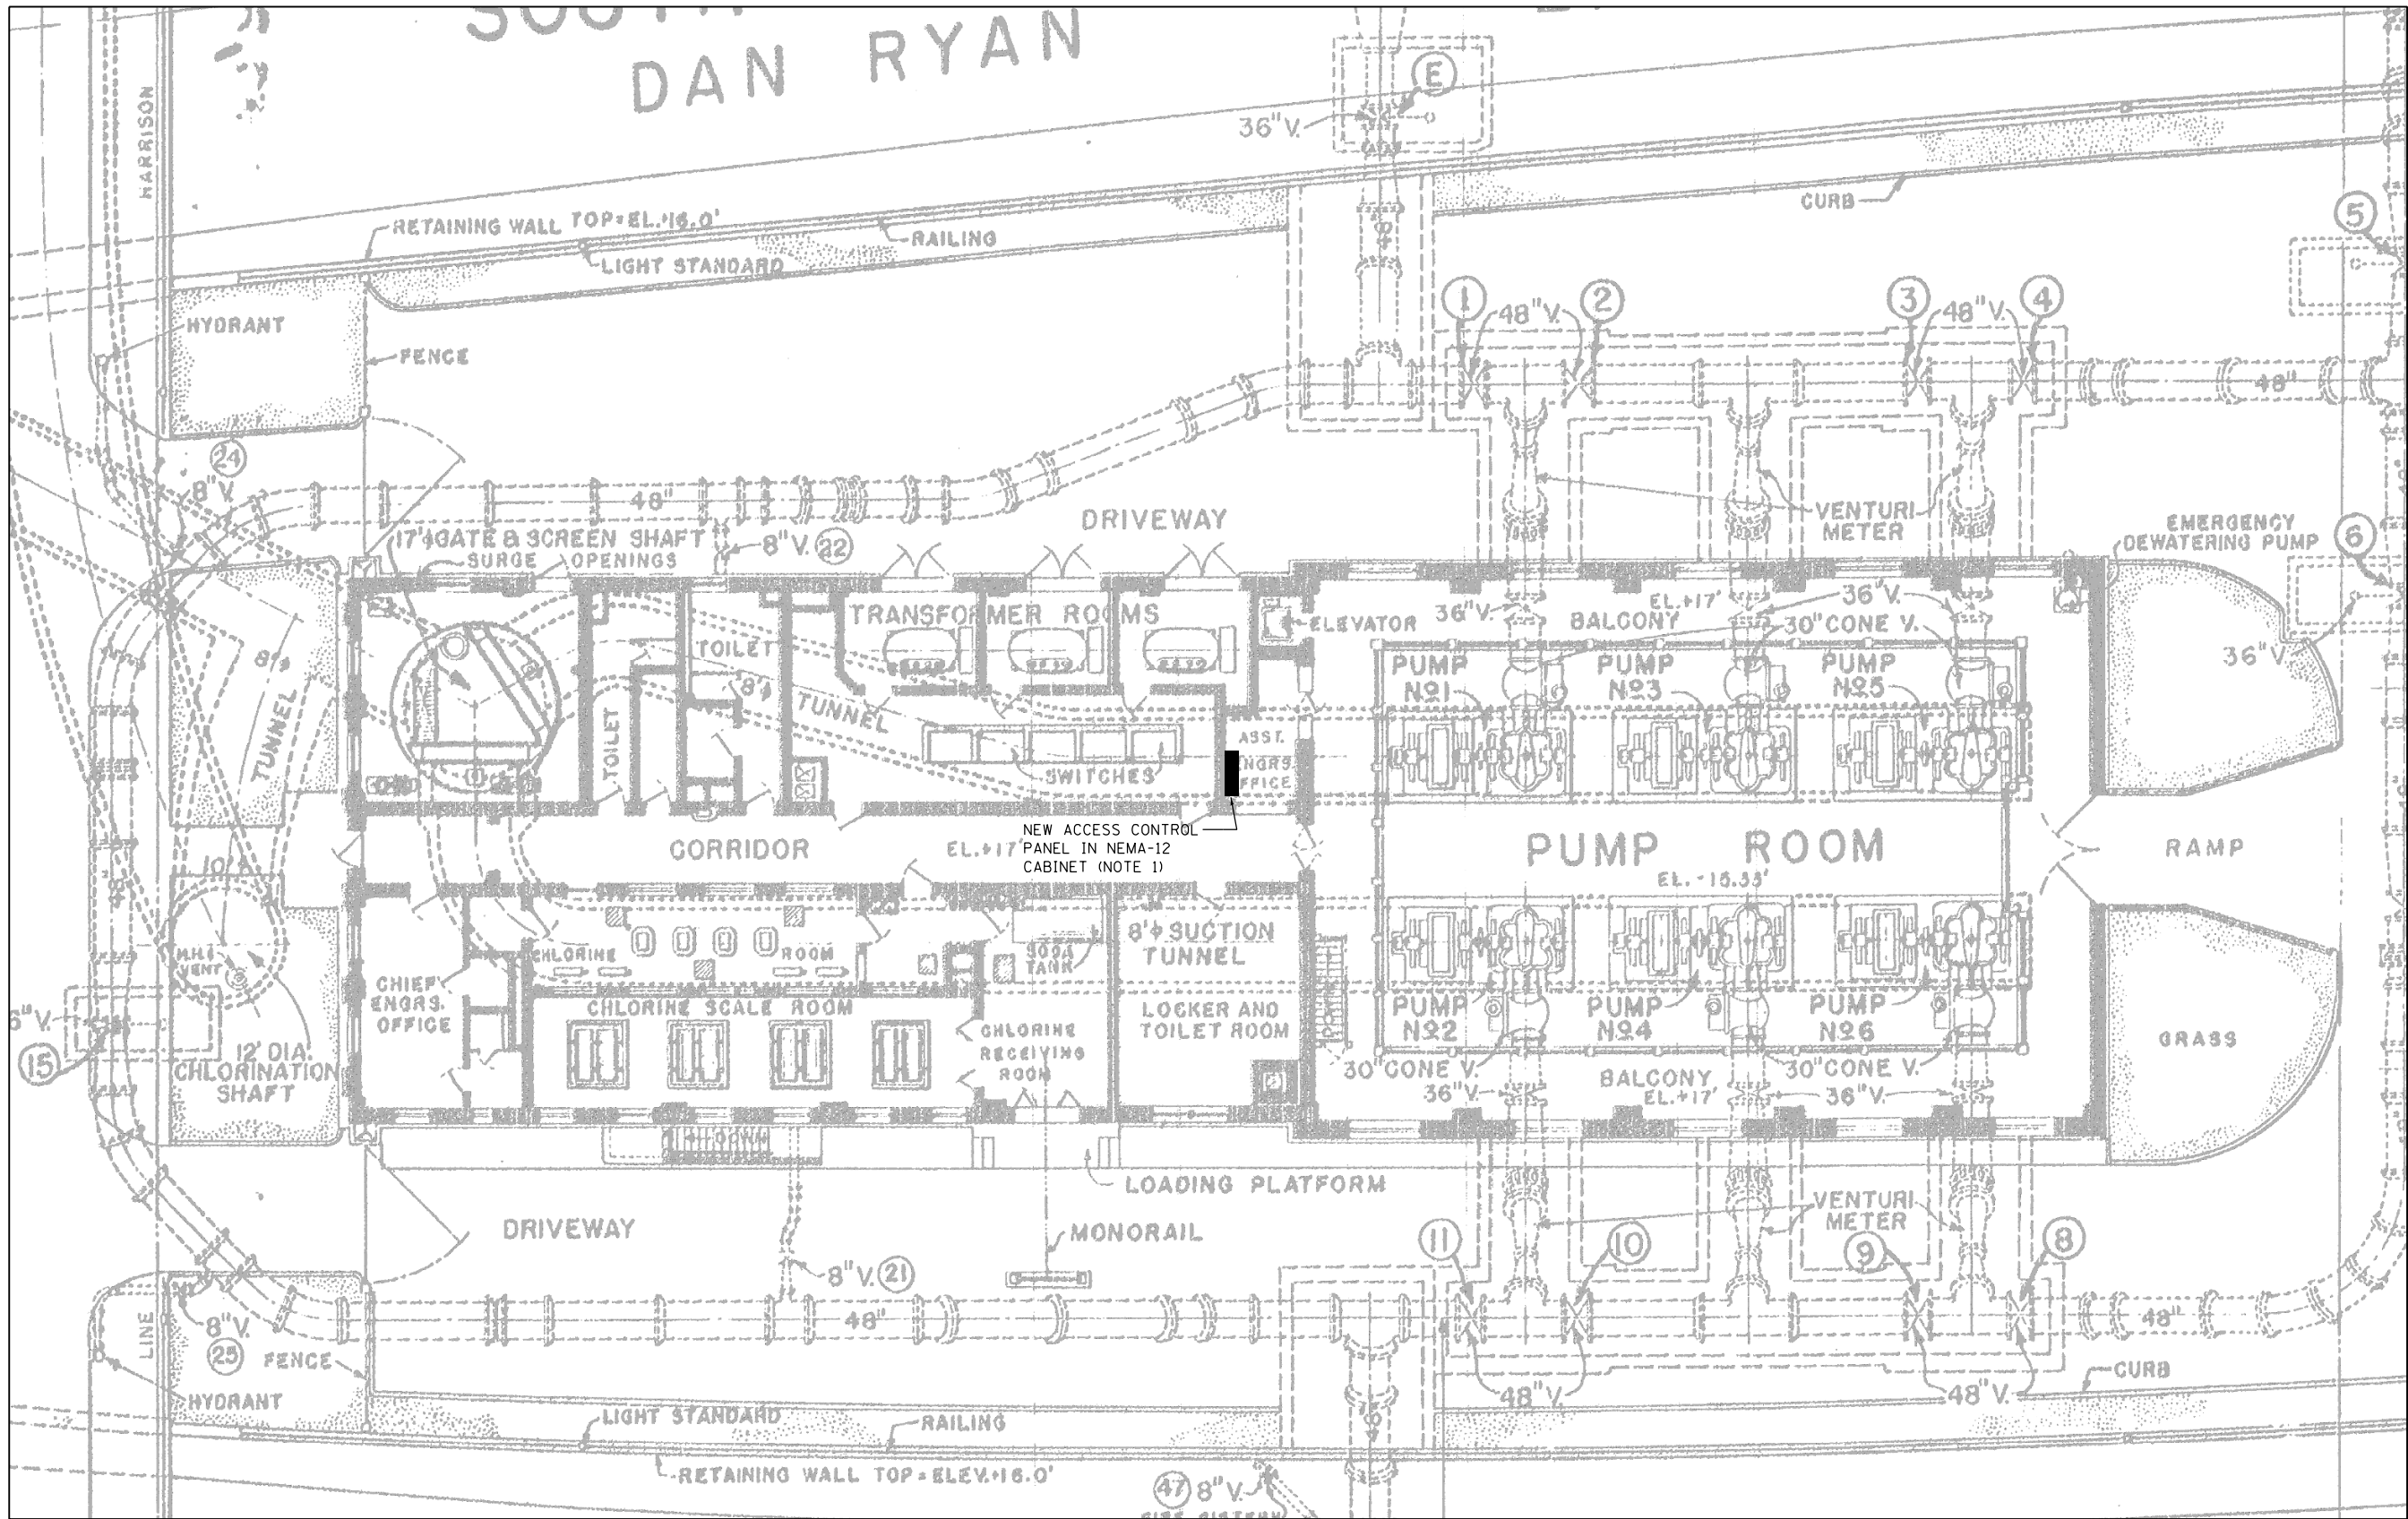

NOTES:

1. INSTALL CABINET ON WALL USING GALVANIZED C-CHANNEL SUPPORTS TO BE ANCHORED TO WALL.

FILE PATH = p:\388035-p\m\1\escomon\me\local\p\AECD\000\Documents\01_Americas\Transportation\62629938_Circle\Phase_1\000_CAD\005_Roadway\Sheets\60W71_Contract\0160W71-Sht-Fence-ELEC-02.dgn



D160W71-Sht-Fence-ELEC-02.dgn
 USER NAME = chiuw
 PLOT SCALE = 2.0000' / in.
 PLOT DATE = 2/20/2014

DESIGNED -	BMW	REVISED -	
DRAWN -	BMW	REVISED -	
CHECKED -	WDS	REVISED -	
DATE -	02/19/14	REVISED -	

STATE OF ILLINOIS
DEPARTMENT OF TRANSPORTATION

GATE OPERATOR
ELECTRICAL PLAN

SCALE: N.T.S. SHEET 2 OF 4 SHEETS STA. TO STA.

F.A.I. RTE.	SECTION	COUNTY	TOTAL SHEETS	SHEET NO.
90/94/290	2013-036R	COOK	256	91B
CONTRACT NO. 60W71				
ILLINOIS FED. AID PROJECT				