



TYPICAL SPLICE DETAIL

N.T.S.

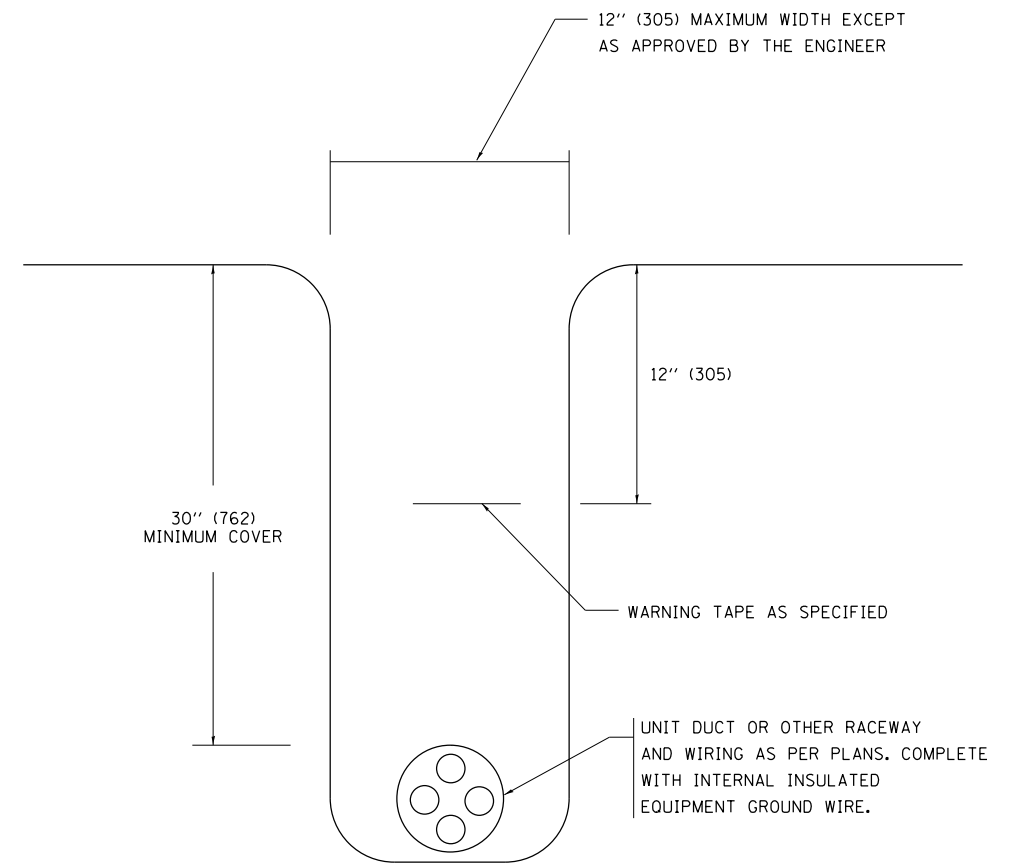

TYPICAL WIRING IN TRENCH DETAIL

N.T.S.

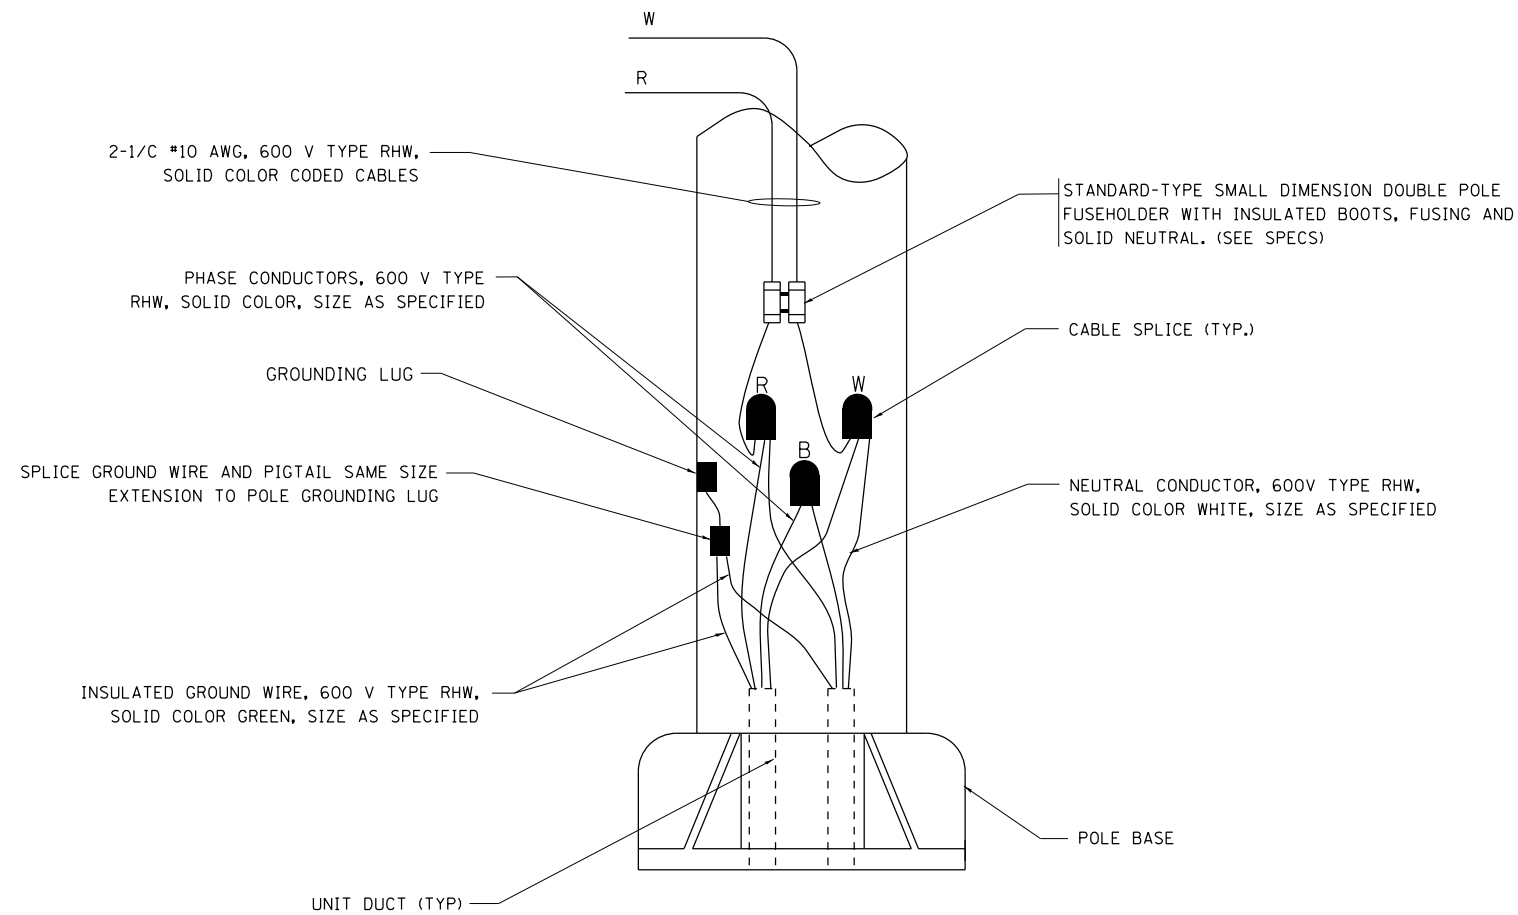

POLE WIRING DETAIL

N.T.S.

FILE PATH = p:\388035\pmt\escomonline\local\p\AECOM\Documents\01_Americas\Transportation\62629938_Circle\Phase_1\000_CAD\005_Roadway_Sheets\60W71_Contract\0160W71-SHT-01-Detail-09-1BE-702.dgn



D160W71-SHT-01-Detail-09-1BE-702.dgn
 USER NAME = chitua
 PLOT SCALE = 50.000' / in.
 PLOT DATE = 12/19/2013

DESIGNED -	REVISIONS	08-08-03
DRAWN -	REVISIONS	
CHECKED -	REVISIONS	
DATE - 12/20/13	REVISIONS	

**STATE OF ILLINOIS
 DEPARTMENT OF TRANSPORTATION**

**MISC. ELECTRICAL DETAILS
 SHEET A**

SCALE: SHEET OF SHEETS STA. TO STA.

F.A.I. RTE.	SECTION	COUNTY	TOTAL SHEETS	SHEET NO.
90/94/290	2013-036R	COOK	256	224
BE-702			CONTRACT NO. 60W71	
ILLINOIS FED. AID PROJECT				