
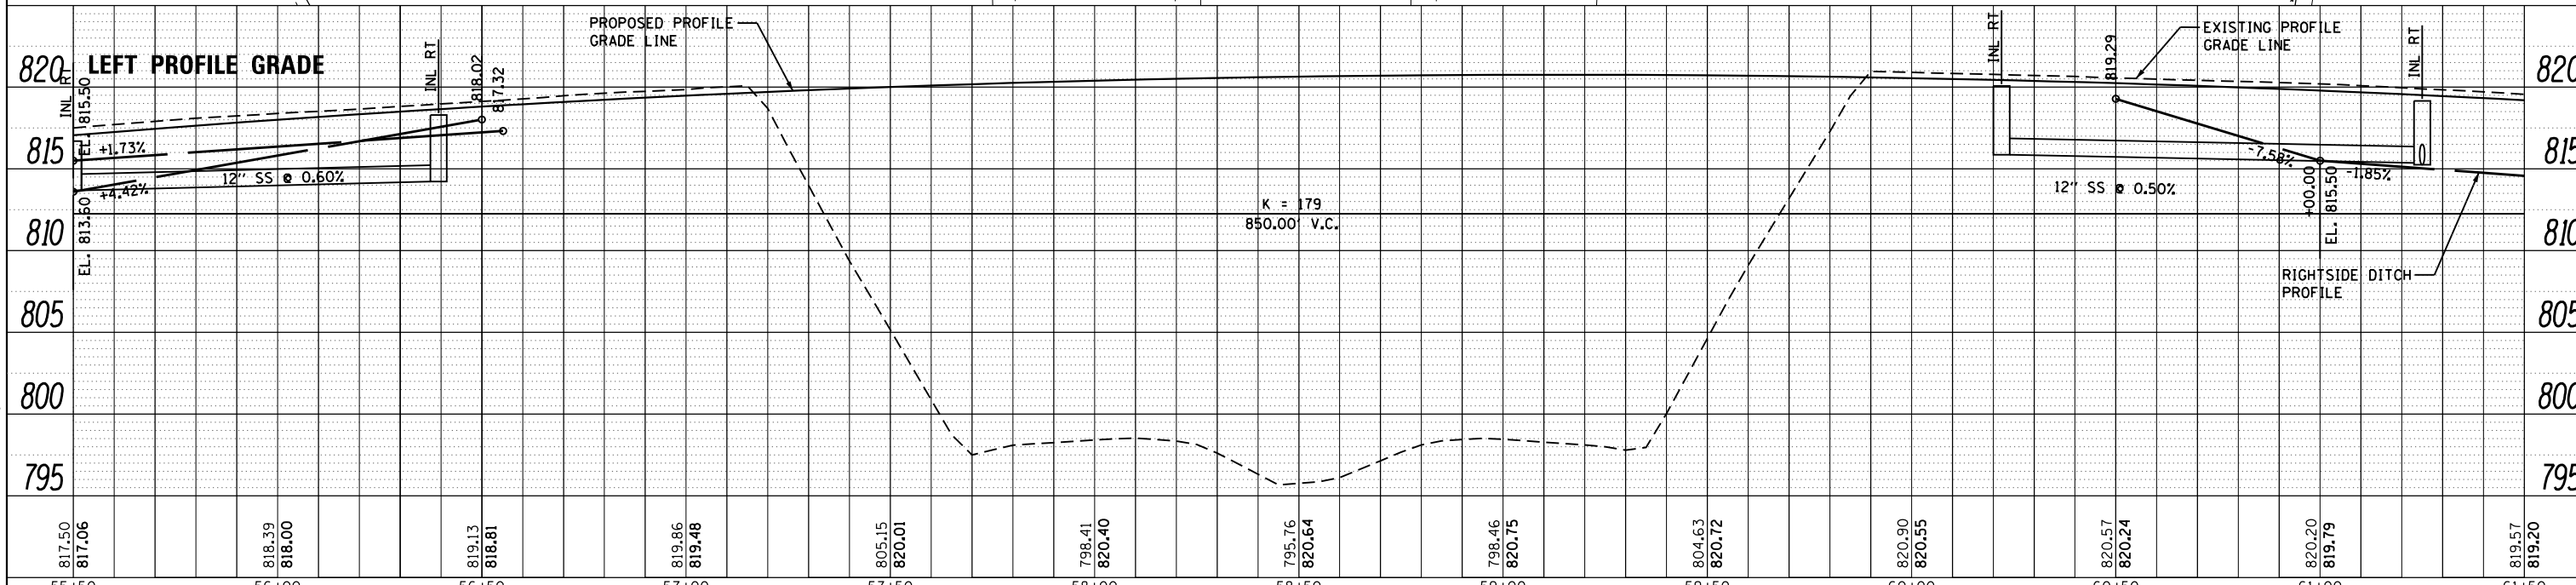


DATE	
BY	
PLAN	SURVEYED
	PLOTTED
	NOTE BOOK
	NO.
	CHECKED
	FILE NAME

DATE	
BY	
PROFILE	SURVEYED
	PLOTTED
	GRADES CHECKED
	NOTE BOOK
	NO.
	CHECKED
	STRUCTURE
	NOTATIONS
	CHP/D

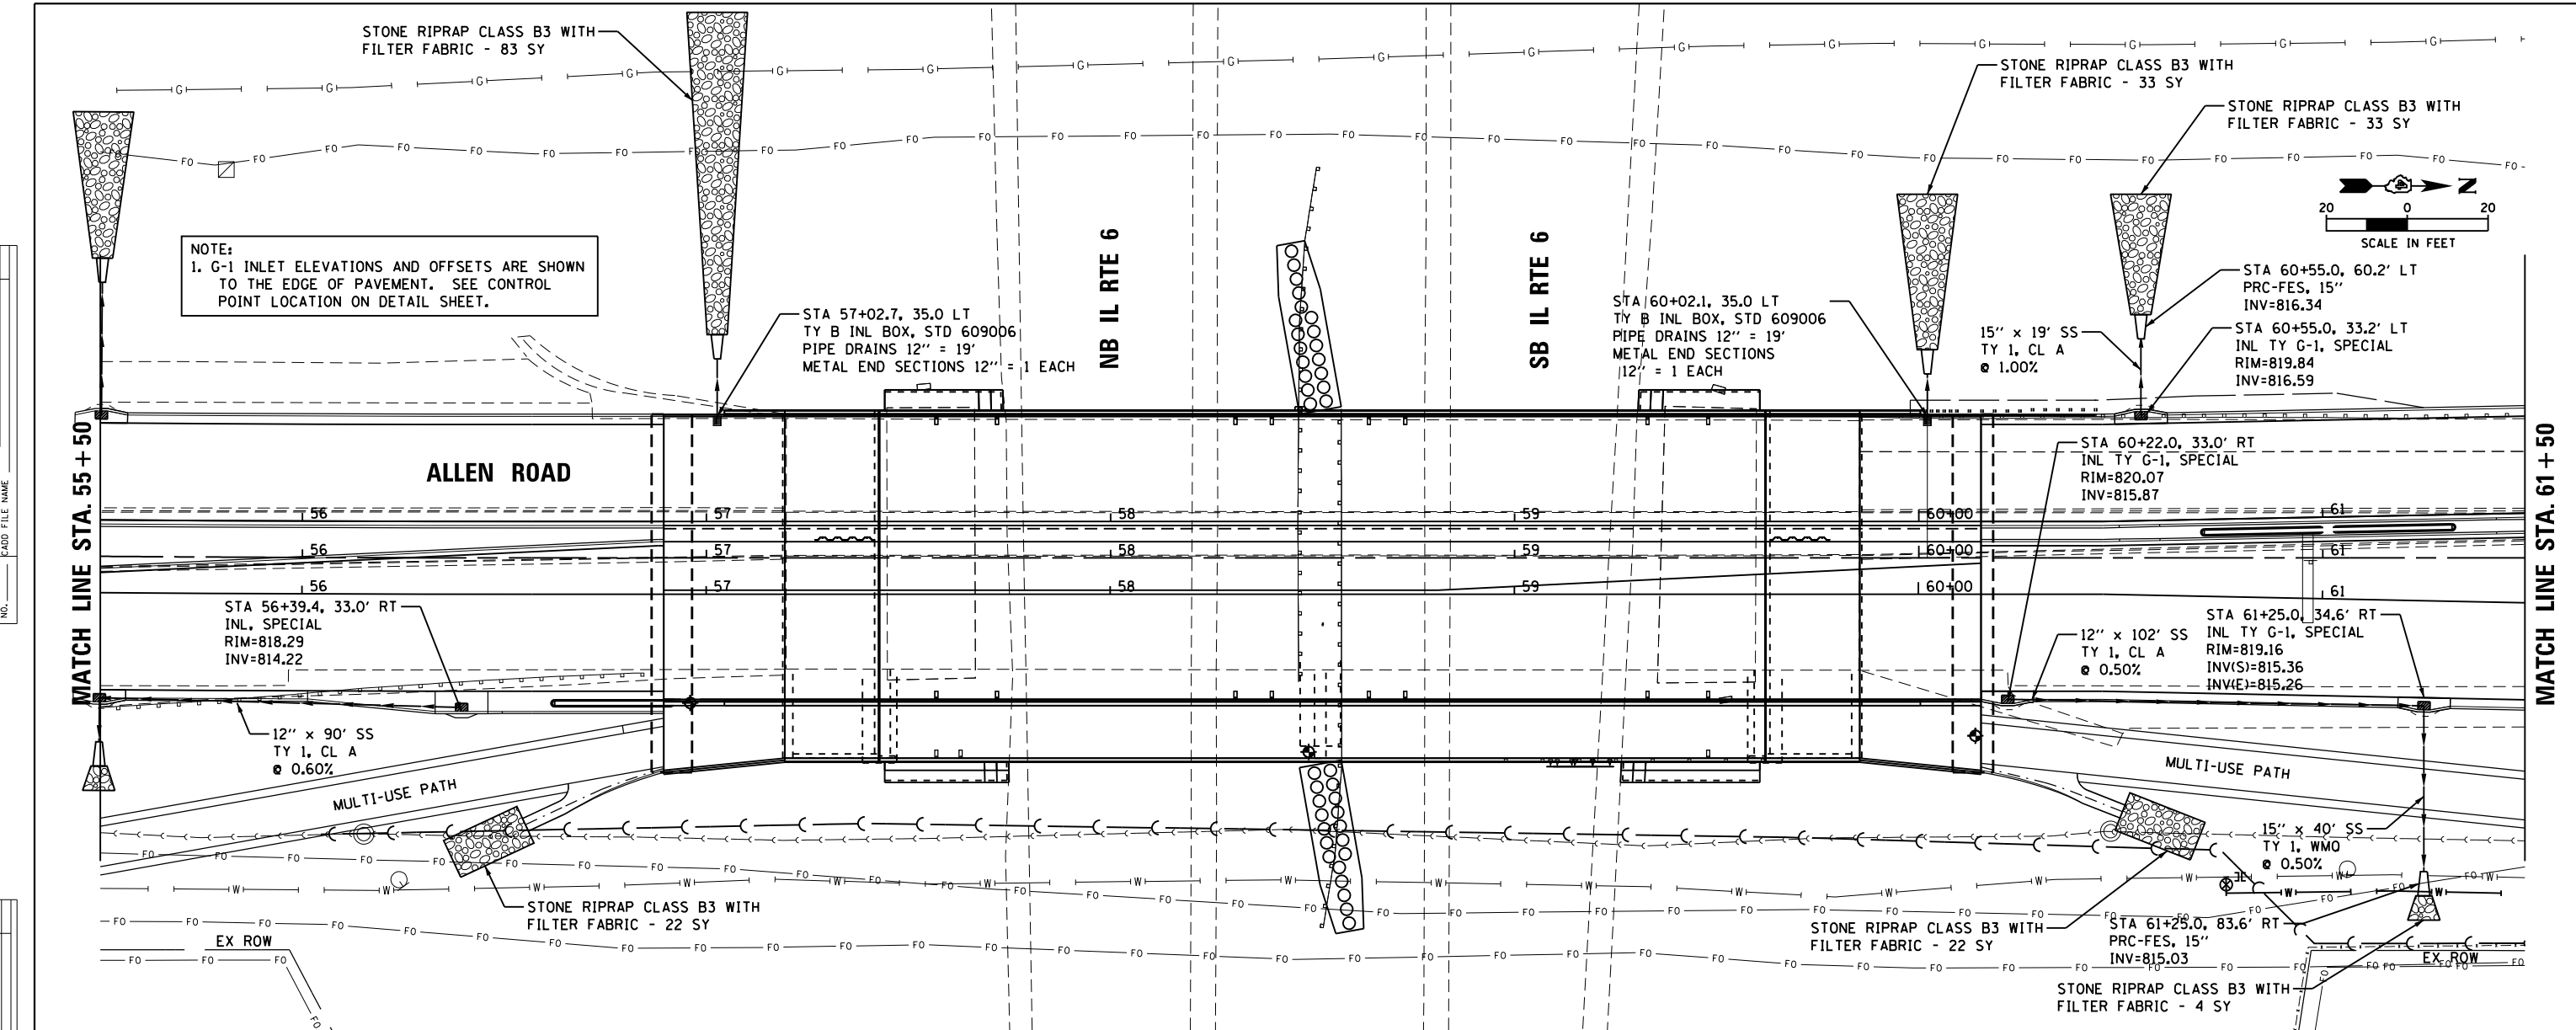

PRAIRIE ENGINEERS OF ILLINOIS, P.C.

FILE NAME =	USER NAME = bbeckstrom	DESIGNED - BAB	REVISED -
I:\Jobs\2013\11301 Allen Road Peoria\Civil	Microstation\0468683-shd-drain3.dgn	DRAWN - BAB	REVISED -
Default	PLOT SCALE = 40.0000' / in.	CHECKED - LDK	REVISED -
	PLOT DATE = 2/18/2014	DATE - 1/24/14	REVISED -

STATE OF ILLINOIS
DEPARTMENT OF TRANSPORTATION

ALLEN ROAD IMPROVEMENTS
STORM SEWER PLAN AND PROFILE - ALLEN ROAD
SCALE: 1" = 20' SHEET 201 OF 487 SHEETS STA. 55+50 TO STA. 61+50

F.A. RTE.	SECTION	COUNTY	TOTAL SHEETS	SHEET NO.
6584	105; (72-7)HBY	PEORIA	487	201
6585				
CONTRACT NO. 68683				
ILLINOIS FED. AID PROJECT				