 


OVERHEAD SIGN STRUCTURE


I-74 EB - MM 172.83

STRUCTURE NO.

5 S 010 I072 R172.83



SITE PLAN / CONDUIT & CABLE LAYOUT

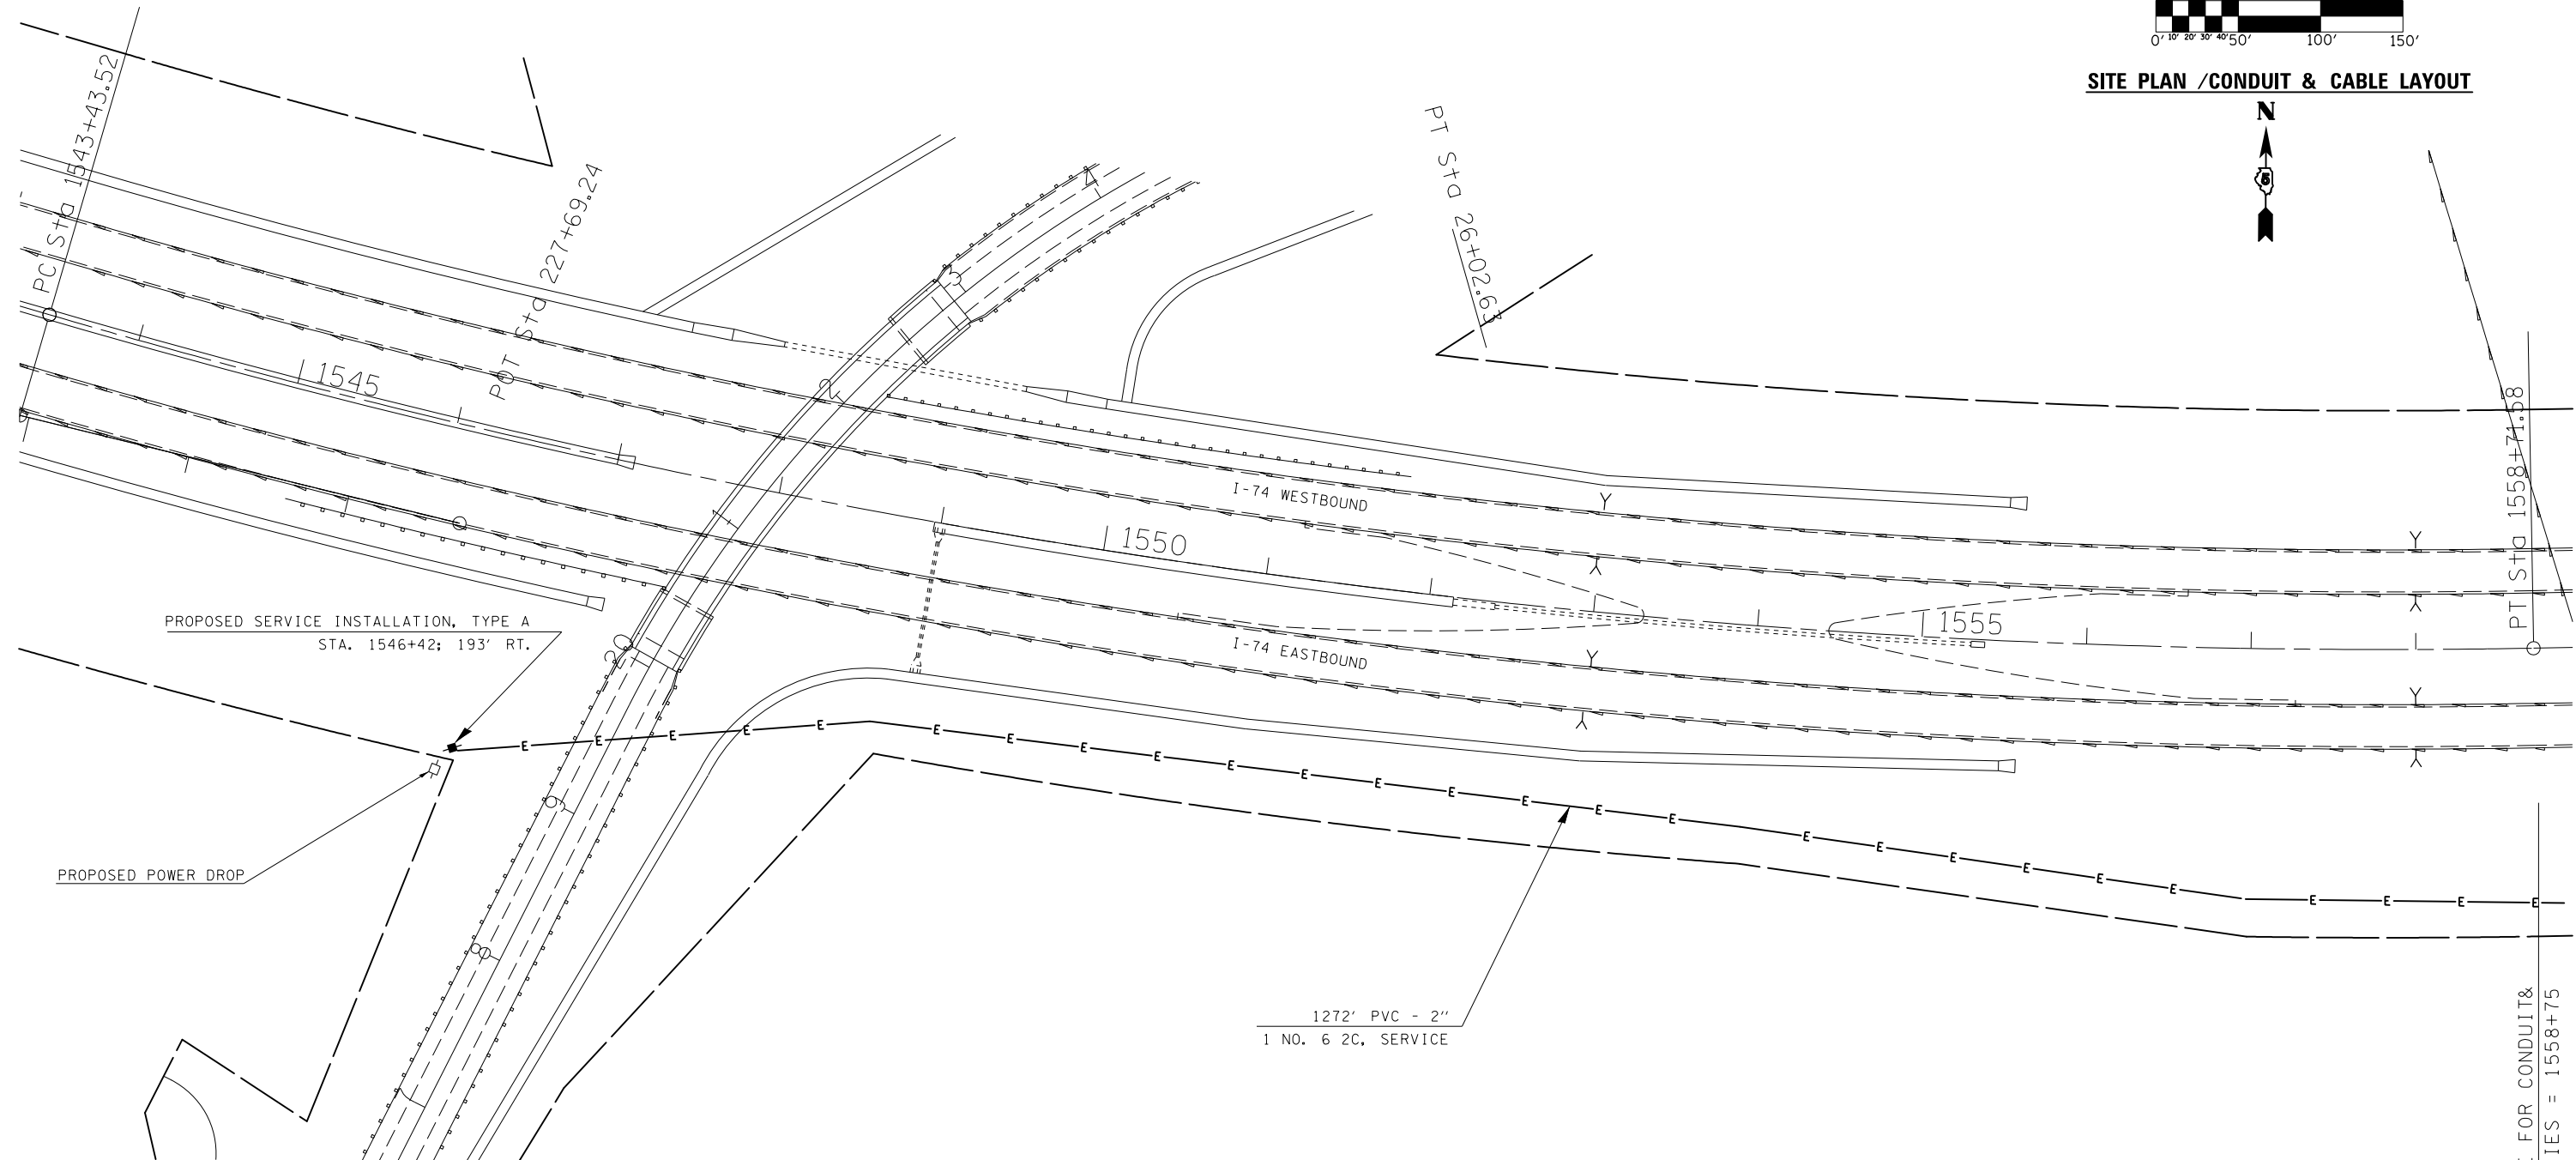

MATCH LINE FOR CONDUIT &
CABLE QUANTITIES = 1558+75

FILE NAME =	USER NAME = biggsrd	DESIGNED -	REVISED -
c:\pw\work\p1dot\biggsrd\d0340463\PTZ	camera plans.dgn	DRAWN -	REVISED -
	PLOT SCALE = 100.0000' / in.	CHECKED -	REVISED -
\$MODELNAME\$	PLOT DATE = 2/7/2014	DATE -	REVISED -

**STATE OF ILLINOIS
DEPARTMENT OF TRANSPORTATION**

SCALE: SHEET OF SHEETS STA. TO STA.

F.A.P. RTE.	SECTION	COUNTY	TOTAL SHEETS	SHEET NO.
VAR.	FY2014 ITS-1	CHAMPAIGN	74	16
CONTRACT NO. 70A26			ILLINOIS FED. AID PROJECT	