 




**OVERHEAD SIGN STRUCTURE**

I-74 WB - MM 189.05

**STRUCTURE NO.  
5 S 010 I074 L189.05**



 **SITE PLAN /CONDUIT & CABLE LAYOUT**

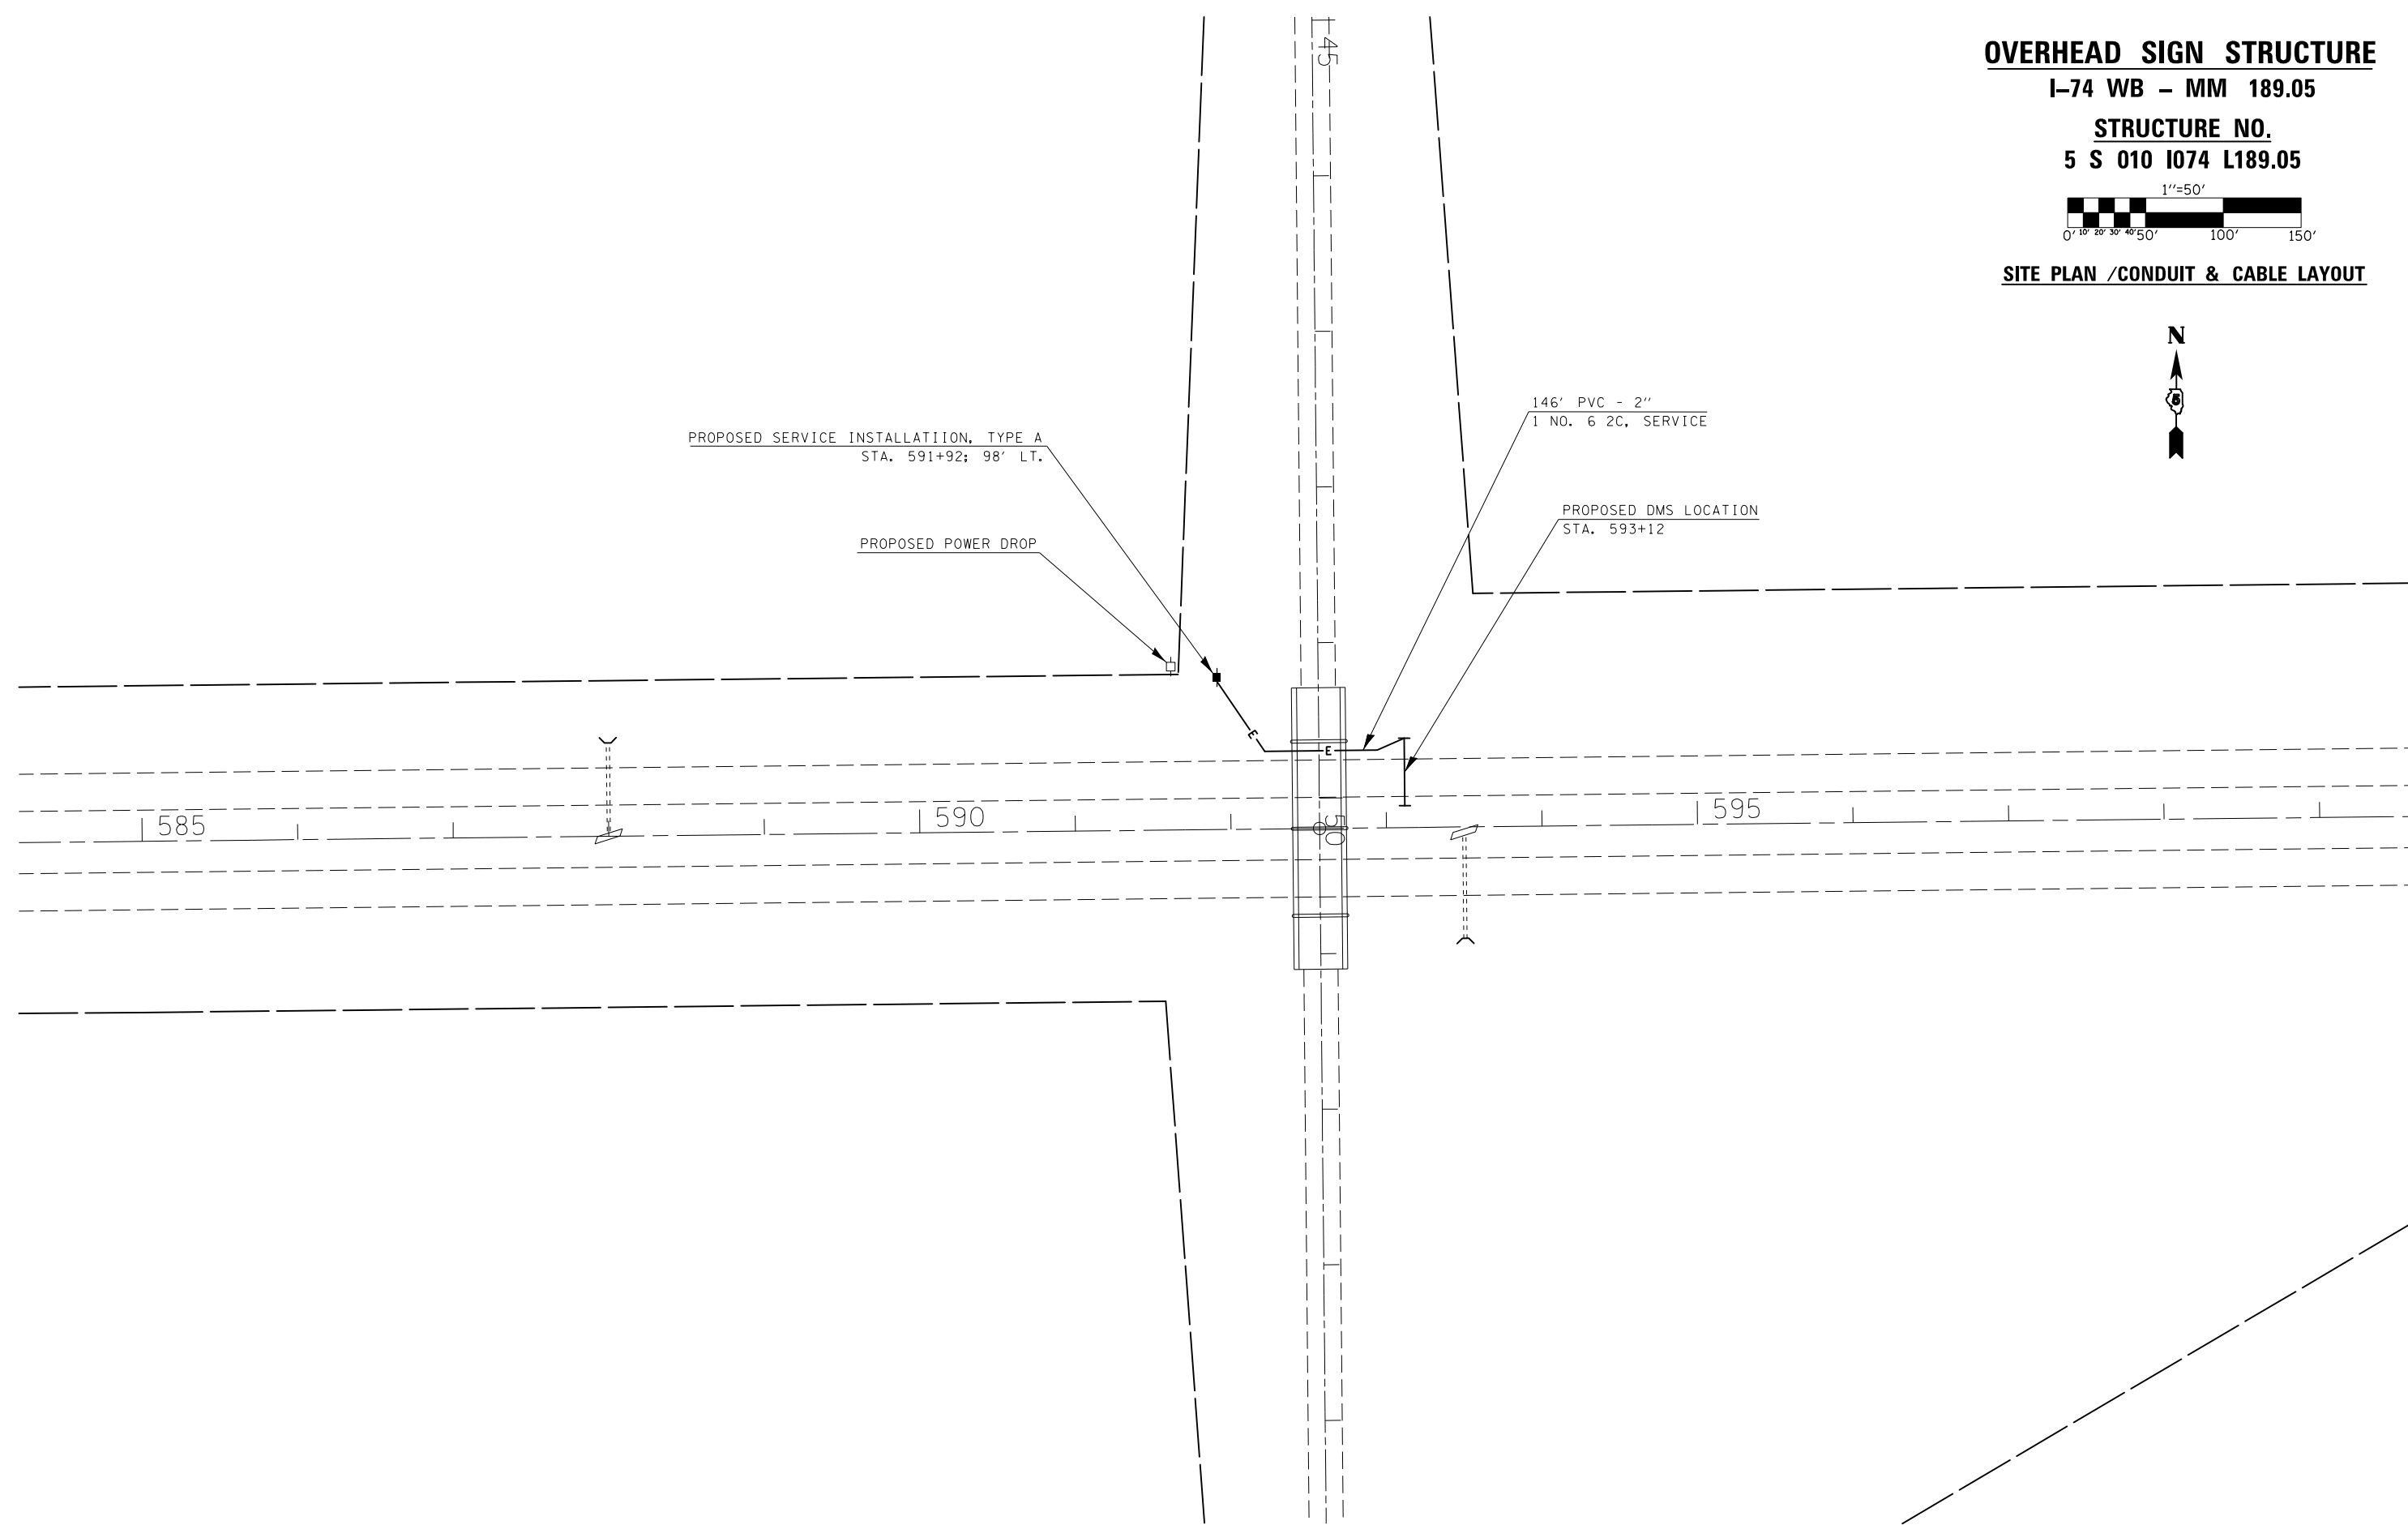

|  |                              |            |           |   |        |              |           |    |        |                    |         |                           |         |        |              |           |  |
|--|------------------------------|------------|-----------|---|--------|--------------|-----------|----|--------|--------------------|---------|---------------------------|---------|--------|--------------|-----------|--|
| FILE NAME =                            | USER NAME = biggsrd          | DESIGNED - | REVISED - | <b>STATE OF ILLINOIS<br/>DEPARTMENT OF TRANSPORTATION</b> | SCALE: |              | SHEET     | OF | SHEETS | STA.               | TO STA. | F.A.P. RTE.               | SECTION | COUNTY | TOTAL SHEETS | SHEET NO. |  |
| et:\pw\work\p\dot\biggsrd\d0340463\PTZ | camera plans.dgn             | DRAWN -    | REVISED - |   | VAR.   | FY2014 ITS-1 | CHMAPAIGN | 74 | 21     | CONTRACT NO. 70A26 |         | ILLINOIS FED. AID PROJECT |         |        |              |           |  |
| \$MODELNAME\$                          | PLOT SCALE = 100.0175' / in. | CHECKED -  | REVISED - |   |        |              |           |    |        |                    |         |                           |         |        |              |           |  |
|  | PLOT DATE = 2/7/2014         | DATE -     | REVISED - |   |        |              |           |    |        |                    |         |                           |         |        |              |           |  |