


CABLE / CONDUIT SCHEDULE	
(A)	UNIT DUCT, 600V, 2-1C NO. 6, 1/C NO. 8 GROUND, (XLP-TYPE USE), 1" DIA POLYETHYLENE
(B)	UNIT DUCT, 600 V, 2-1C NO. 4, 1/C NO. 6 GROUND, (XLP-TYPE USE), 1" DIA POLYETHYLENE
(C)	ELECTRIC CABLE IN CONDUIT, 600V, (XLP-TYPE USE), 2-1C NO. 4, 2-1C NO. 6 1/C NO. 8 GROUND 1/C NO. 8 GROUND IN 2" DIA PVC CONDUIT EMBEDDED IN STRUCTURE

LEGEND	
	UNIT DUCT SIZE AS NOTED
	PROPOSED COILABLE NON-METALLIC CONDUIT, 2 1/2" DIA UNLESS NOTED OTHERWISE, SCHEDULE 80
	PROPOSED LIGHTING CONTROLLER
	PROPOSED JUNCTION BOX, STAINLESS STEEL ATTACHED TO STRUCTURE, 12" x 12" x 8"
	PROPOSED LIGHTING UNIT, 45 FT WEATHERING STEEL POLE, TENON MOUNT, 250 W HPS MULTIMOUNT LUMINAIR
	PROPOSED LIGHTING UNIT, 45 FT WEATHERING STEEL POLE, TWIN TENON, 2-250W HPS LUMINAIRES
	CONDUIT EMBEDDED IN STRUCTURE, 2" DIA PVC

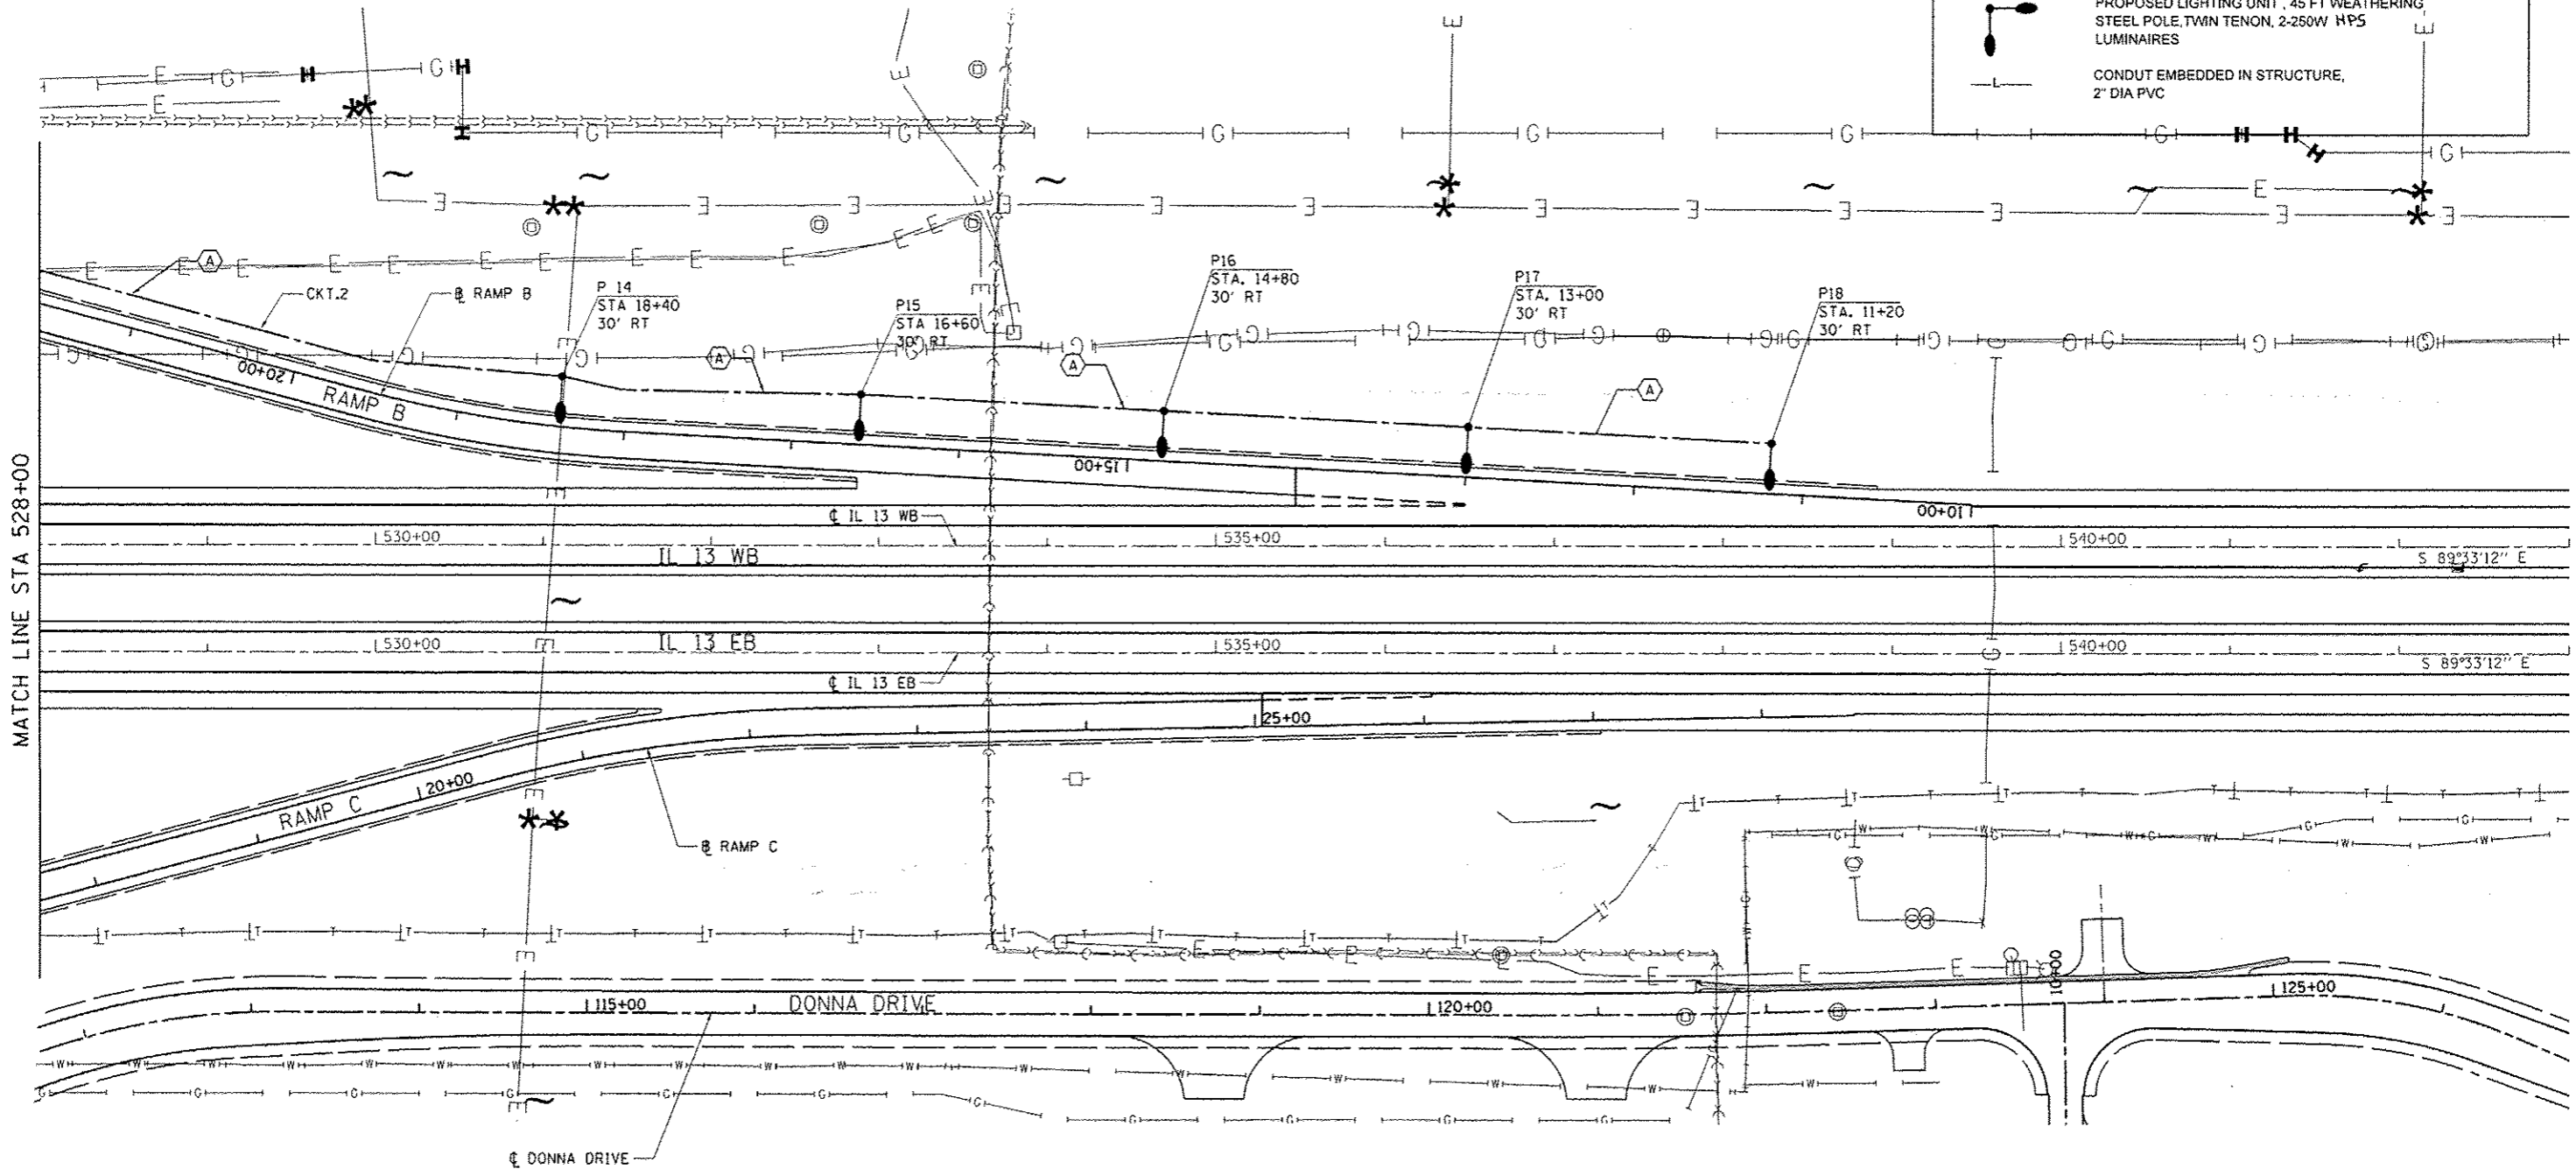

MATCH LINE STA 528+00



FILE NAME : c:\p\work\p\p\dst\lavender\ba\0363618\0363618.dgn	USER NAME : #USER#	DESIGNED - KN	REVISD -
	78221-shr-light-03.dgn	DRAWN - AS	REVISD -
	PLOT SCALE : 100.0000 / in.	CHECKED -	REVISD -
	PLOT DATE : 1/31/2014	DATE -	REVISD -

STATE OF ILLINOIS
DEPARTMENT OF TRANSPORTATION

LIGHTING PLANS
IL 13

SCALE: 1"=50' SHEET NO. 3 OF 5 SHEETS STA. 528+00.00 TO STA. 543+00.00

F.A.P. RTE.	SECTION	COUNTY	TOTAL SHEETS	SHEET NO.
331	11-3R-2, N-4, TS-4, HBK-1	WILLIAMSON	733	355
DRAWING NO. LT-03		CONTRACT NO. 78221		
ILLINOIS FED. AID PROJECT				