
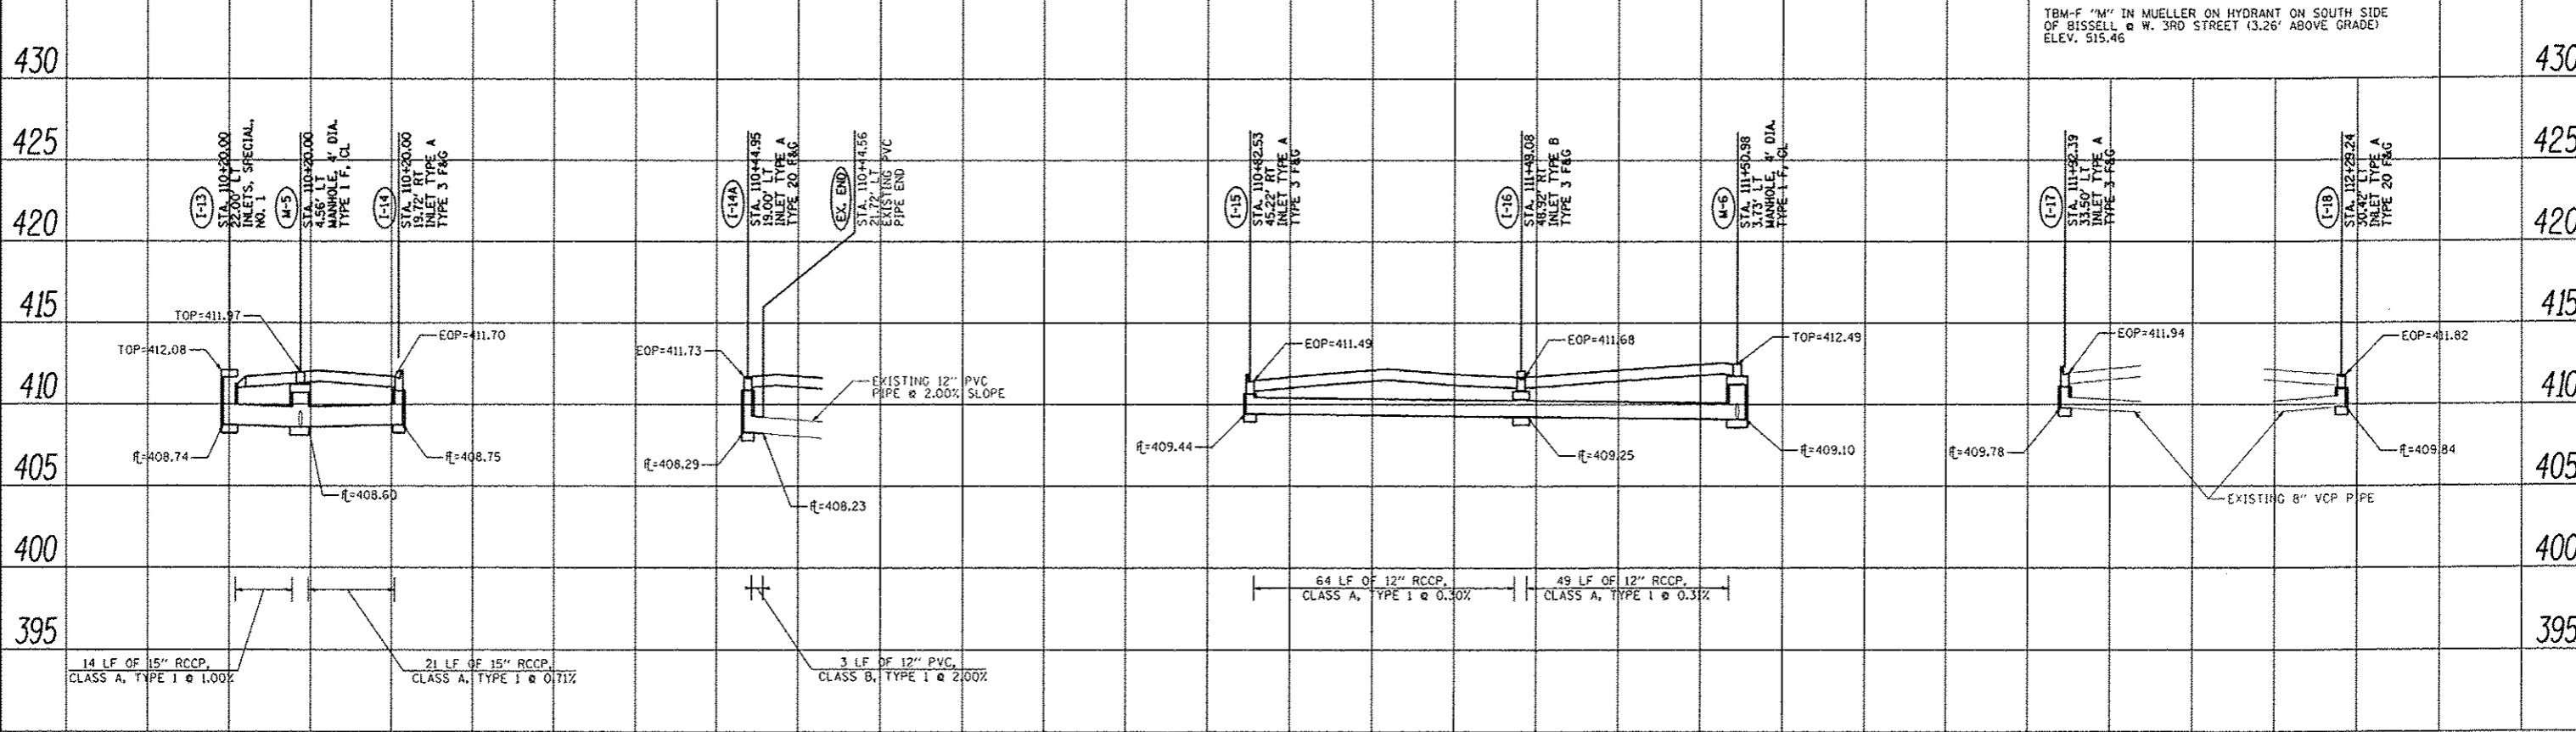


PLAN	SURVEYED	DATE
NOTE BOOK	PLotted	
NO.	AT OWNERS RISK	
	FILE NAME	

PROFILE	SURVEYED	DATE
NOTE BOOK	PLotted	
NO.	AT OWNERS RISK	
	FILE NAME	

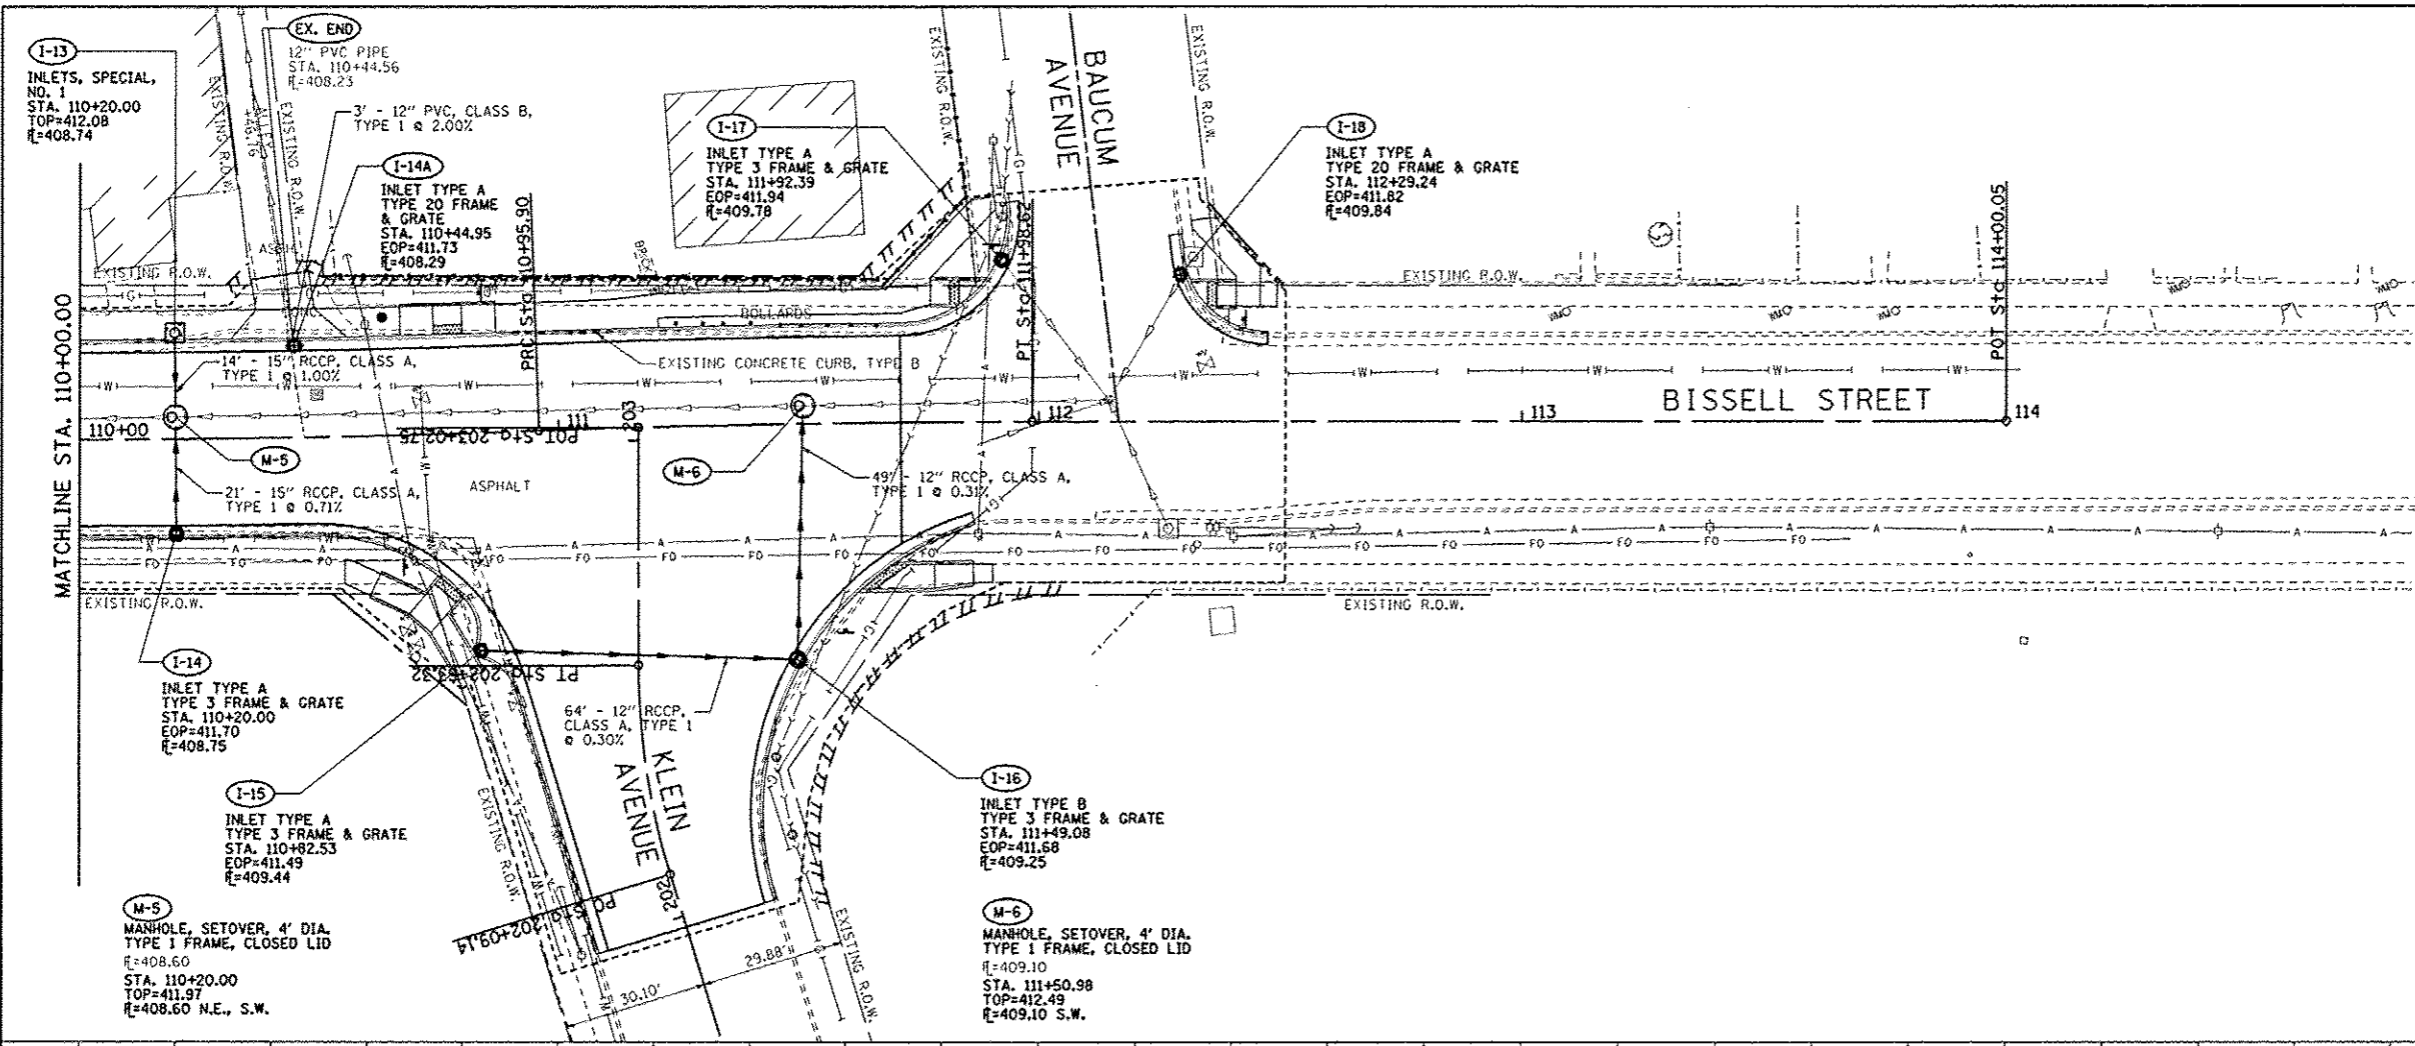

FILE NAME	USER NAME: rcmash	DESIGNED: SAS	REVISED:	CITY OF MADISON BISSSELL STREET	DRAINAGE PLAN & PROFILE	F.A.U. RTE. 9104	SECTION 10-00058-00-PV	COUNTY MADISON	TOTAL SHEETS 53	SHEET NO. 33		
PLOT SCALE: 1"=20'	CHECKED: BFK	DATE: 12/20/13	REVISED:			SCALE: 1"=20'	SHEET NO. 3 OF 3 SHEETS	STA. 110+00.00 TO STA. 113+00.00	CONTRACT NO. 97530			
PLOT DATE: 12/20/2013	DATE: 12/20/13	REVISED:	ILLINOIS FED. AID PROJECT									