


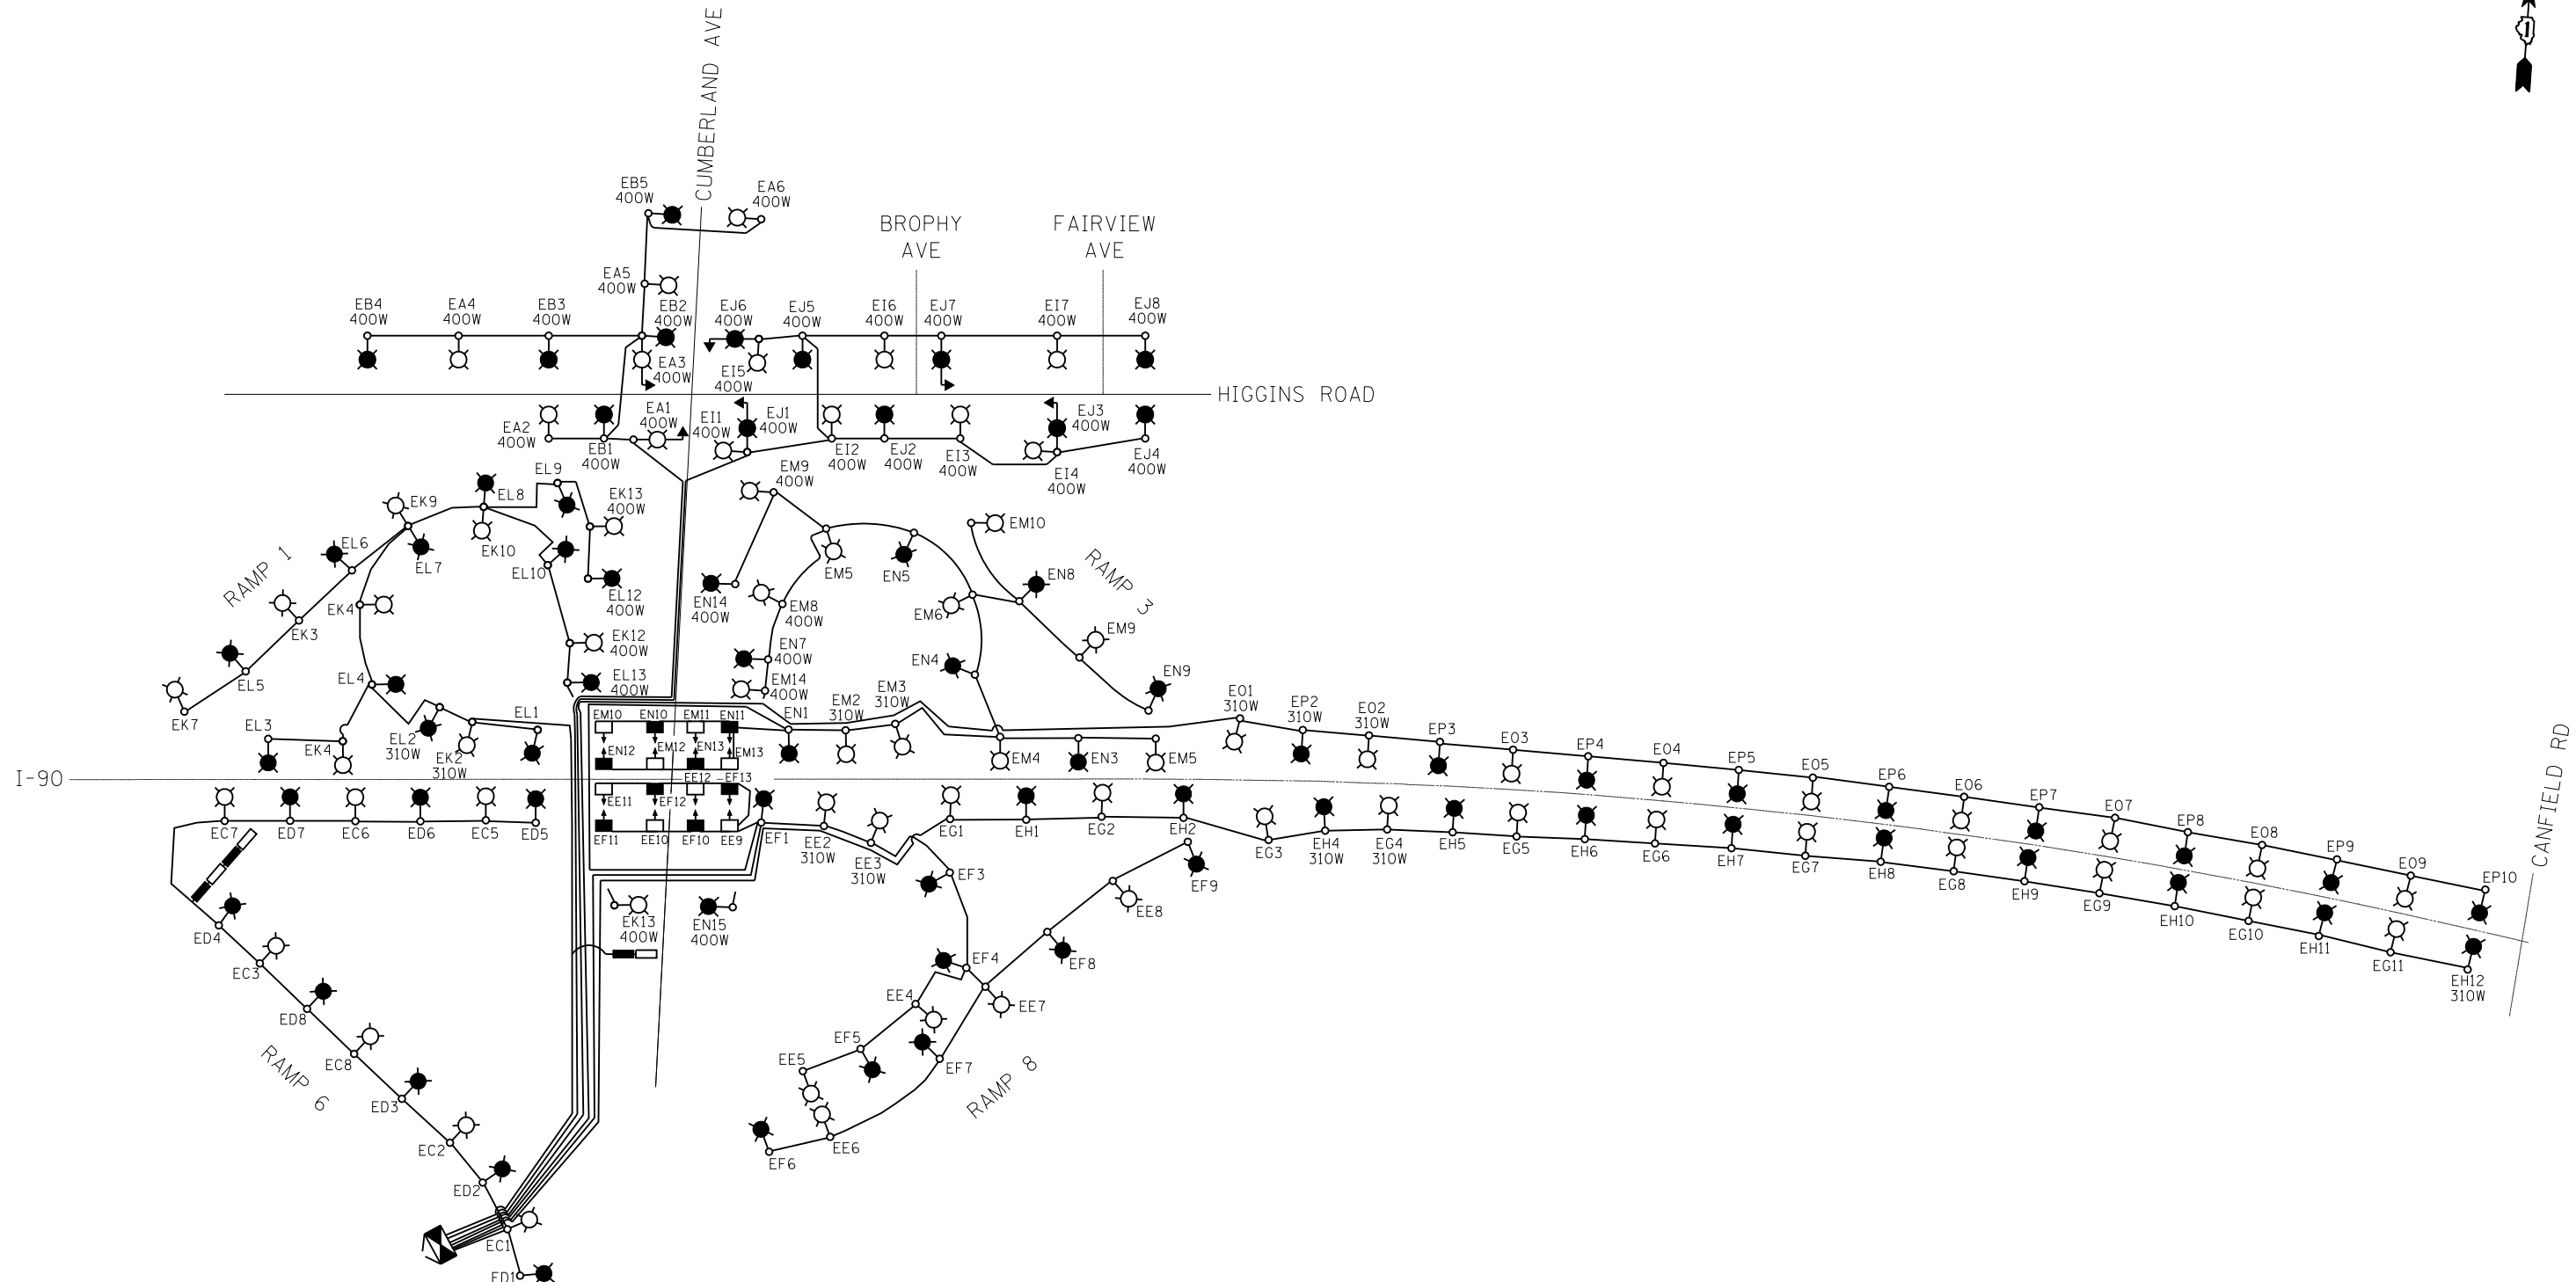

s:\projects\3009 1-90_cumberland-patrick\project work\disciplines\electrical\sheet\DI60J14-sht-light-12.dgn

2/18/2013 2:43:35 PM



LEGEND

- ROADWAY LUMINAIRE ON RED PHASE
- ROADWAY LUMINAIRE ON BLACK PHASE
(ROADWAY LUMINAIRES ARE 200W U.N.O.)
- 100W UNDERPASS LUMINAIRE ON RED PHASE
- 100W UNDERPASS LUMINAIRE ON BLACK PHASE
- SIGN LUMINAIRE ON RED PHASE
- SIGN LUMINAIRE ON BLACK PHASE
- LIGHTING CONTROLLER

USER NAME =	DESIGNED - RAS	REVISED -
	DRAWN - RAS	REVISED -
PLOT SCALE =	CHECKED - MKR	REVISED -
PLOT DATE =	DATE - 2/18/2013	REVISED -



**STATE OF ILLINOIS
DEPARTMENT OF TRANSPORTATION**

**SINGLE LINE DIAGRAM
IDOT CONTROLLER "E"**

SCALE: NONE SHEET NO. 1 OF 1 SHEETS STA. TO STA.

F.A.U. RTE.	SECTION	COUNTY	TOTAL SHEETS	SHEET NO.
2746	1616B	COOK	404	244
CONTRACT NO. 60J14				
ILLINOIS FED. AID PROJECT				

LT-12