


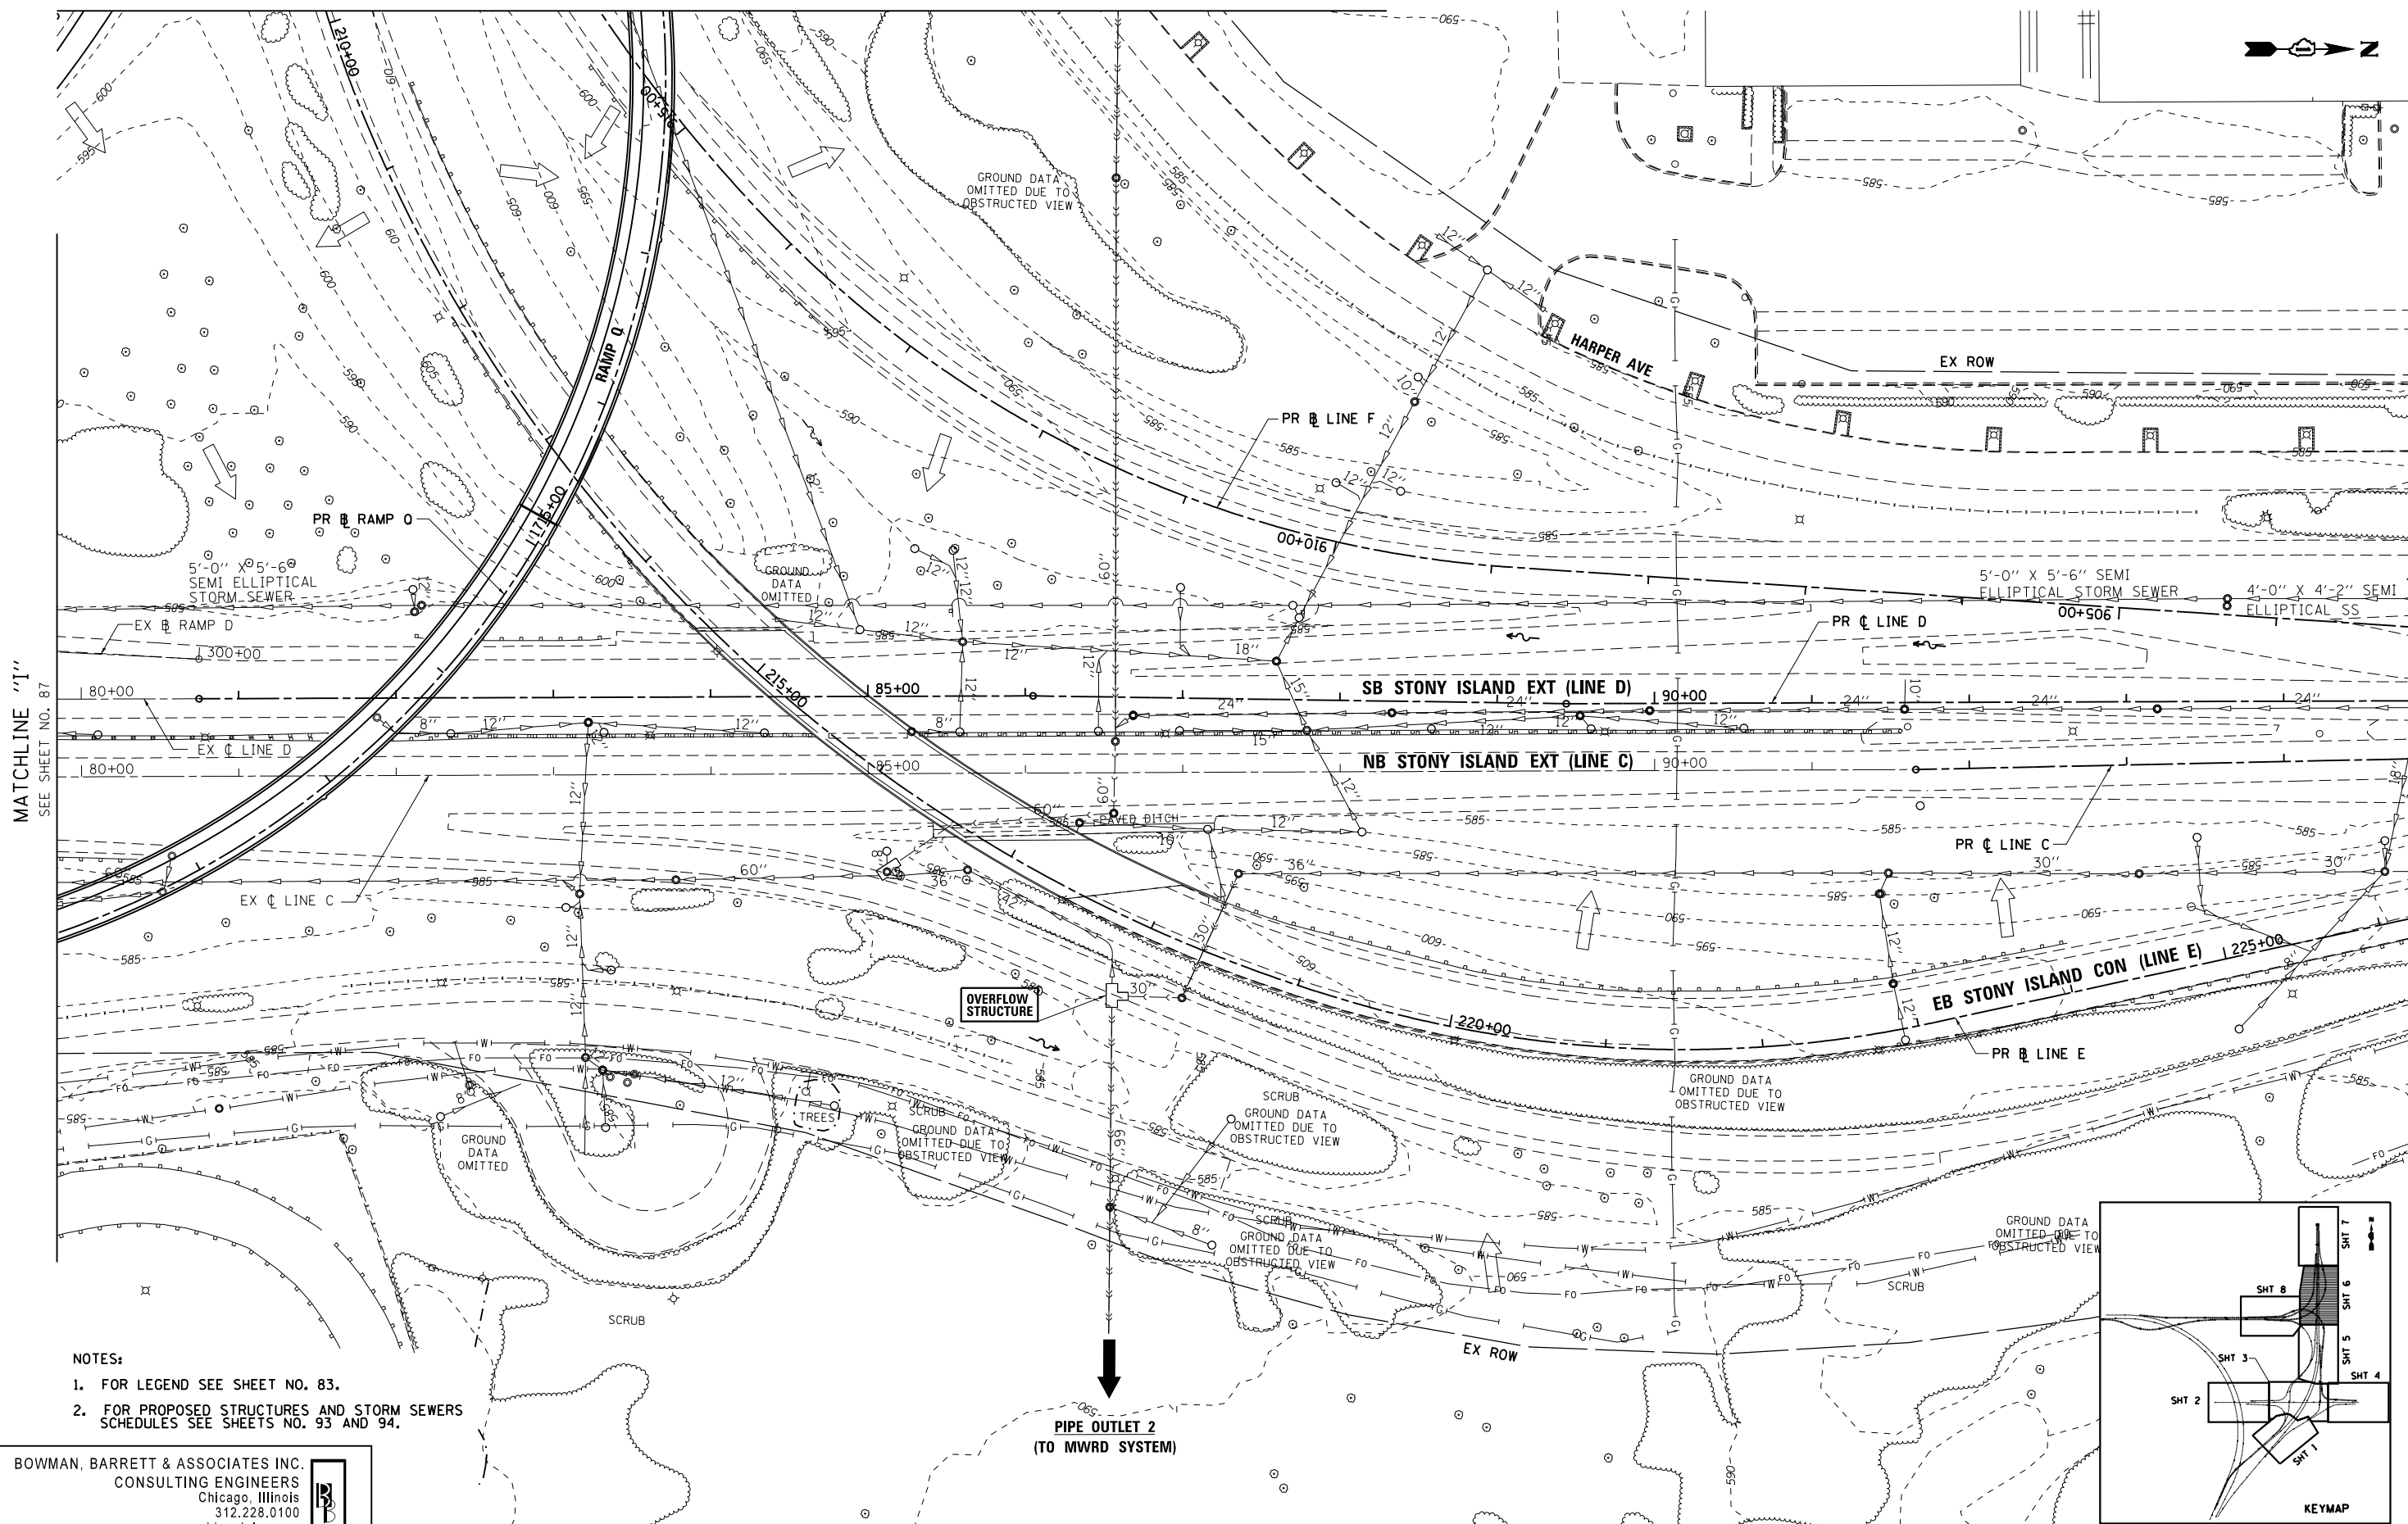

MATCHLINE "I" SEE SHEET NO. 87

MATCHLINE "J" SEE SHEET NO. 89




- NOTES:**
- FOR LEGEND SEE SHEET NO. 83.
 - FOR PROPOSED STRUCTURES AND STORM SEWERS SCHEDULES SEE SHEETS NO. 93 AND 94.

BOWMAN, BARRETT & ASSOCIATES INC.
 CONSULTING ENGINEERS
 Chicago, Illinois
 312.228.0100
 www.bbandainc.com



**PIPE OUTLET 2
 (TO MWRD SYSTEM)**

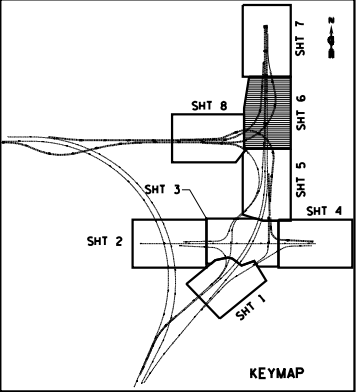

FILE NAME =	USER NAME = default	DESIGNED - JAM	REVISED -
#FILE#		DRAWN - JAM	REVISED -
	PLOT SCALE = #SCALE#	CHECKED - RGR	REVISED -
	PLOT DATE = 12/7/2012	DATE - 11/08/2012	REVISED -

**STATE OF ILLINOIS
 DEPARTMENT OF TRANSPORTATION**

**PROPOSED DRAINAGE PLAN
 STONY ISLAND EXTENSION**

SCALE: 1"=50' SHEET NO. 6 OF 8 SHEETS STA. TO STA.

F.A.I. RTE.	SECTION	COUNTY	TOTAL SHEETS	SHEET NO.
94	2012-060-BR	COOK	285	88
CONTRACT NO. 60V61			ILLINOIS FED. AID PROJECT	

S:\1072-06-CADD\1060\61_Sheets\1060\61-sh1-prp.dwg