
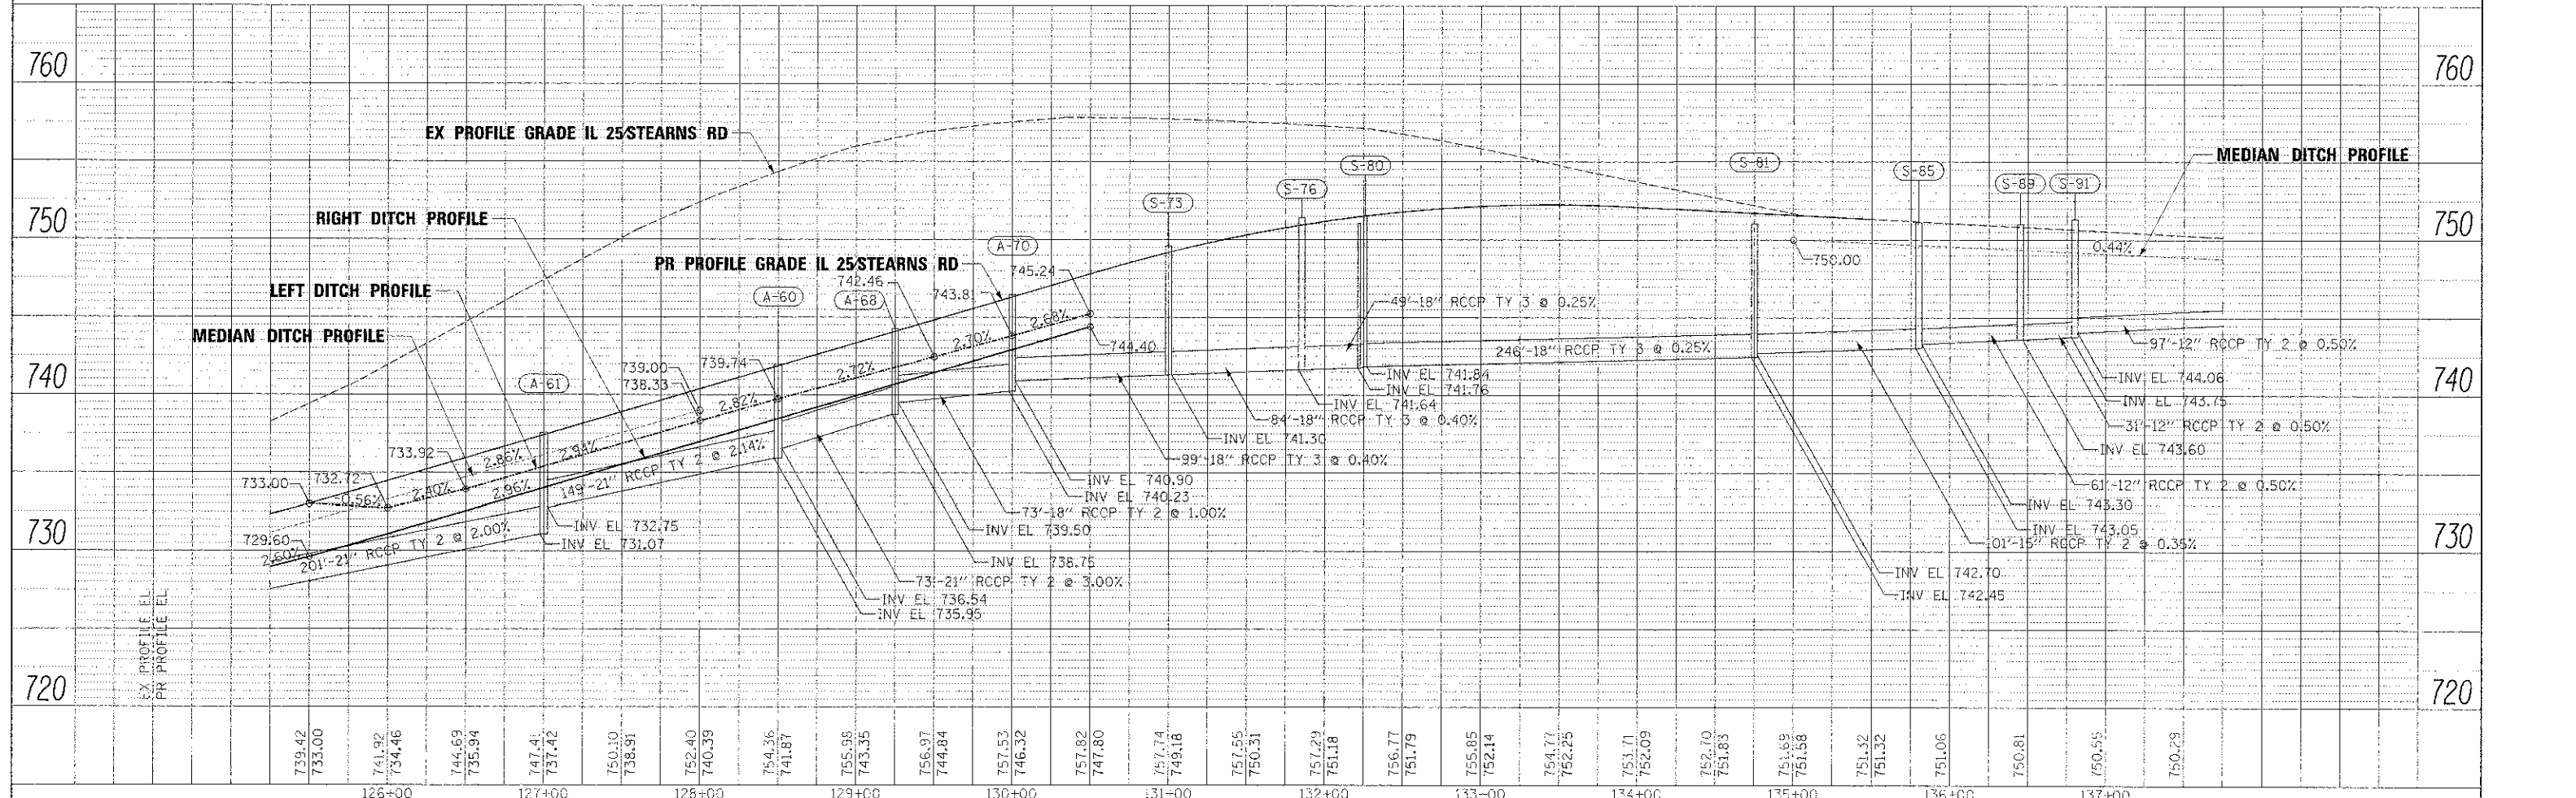


NOTE BOOK  
 REVISIONS  
 NO. DATE  
 CAD FILE NAME

NO. DATE  
 USER NAME  
 PLG DATE

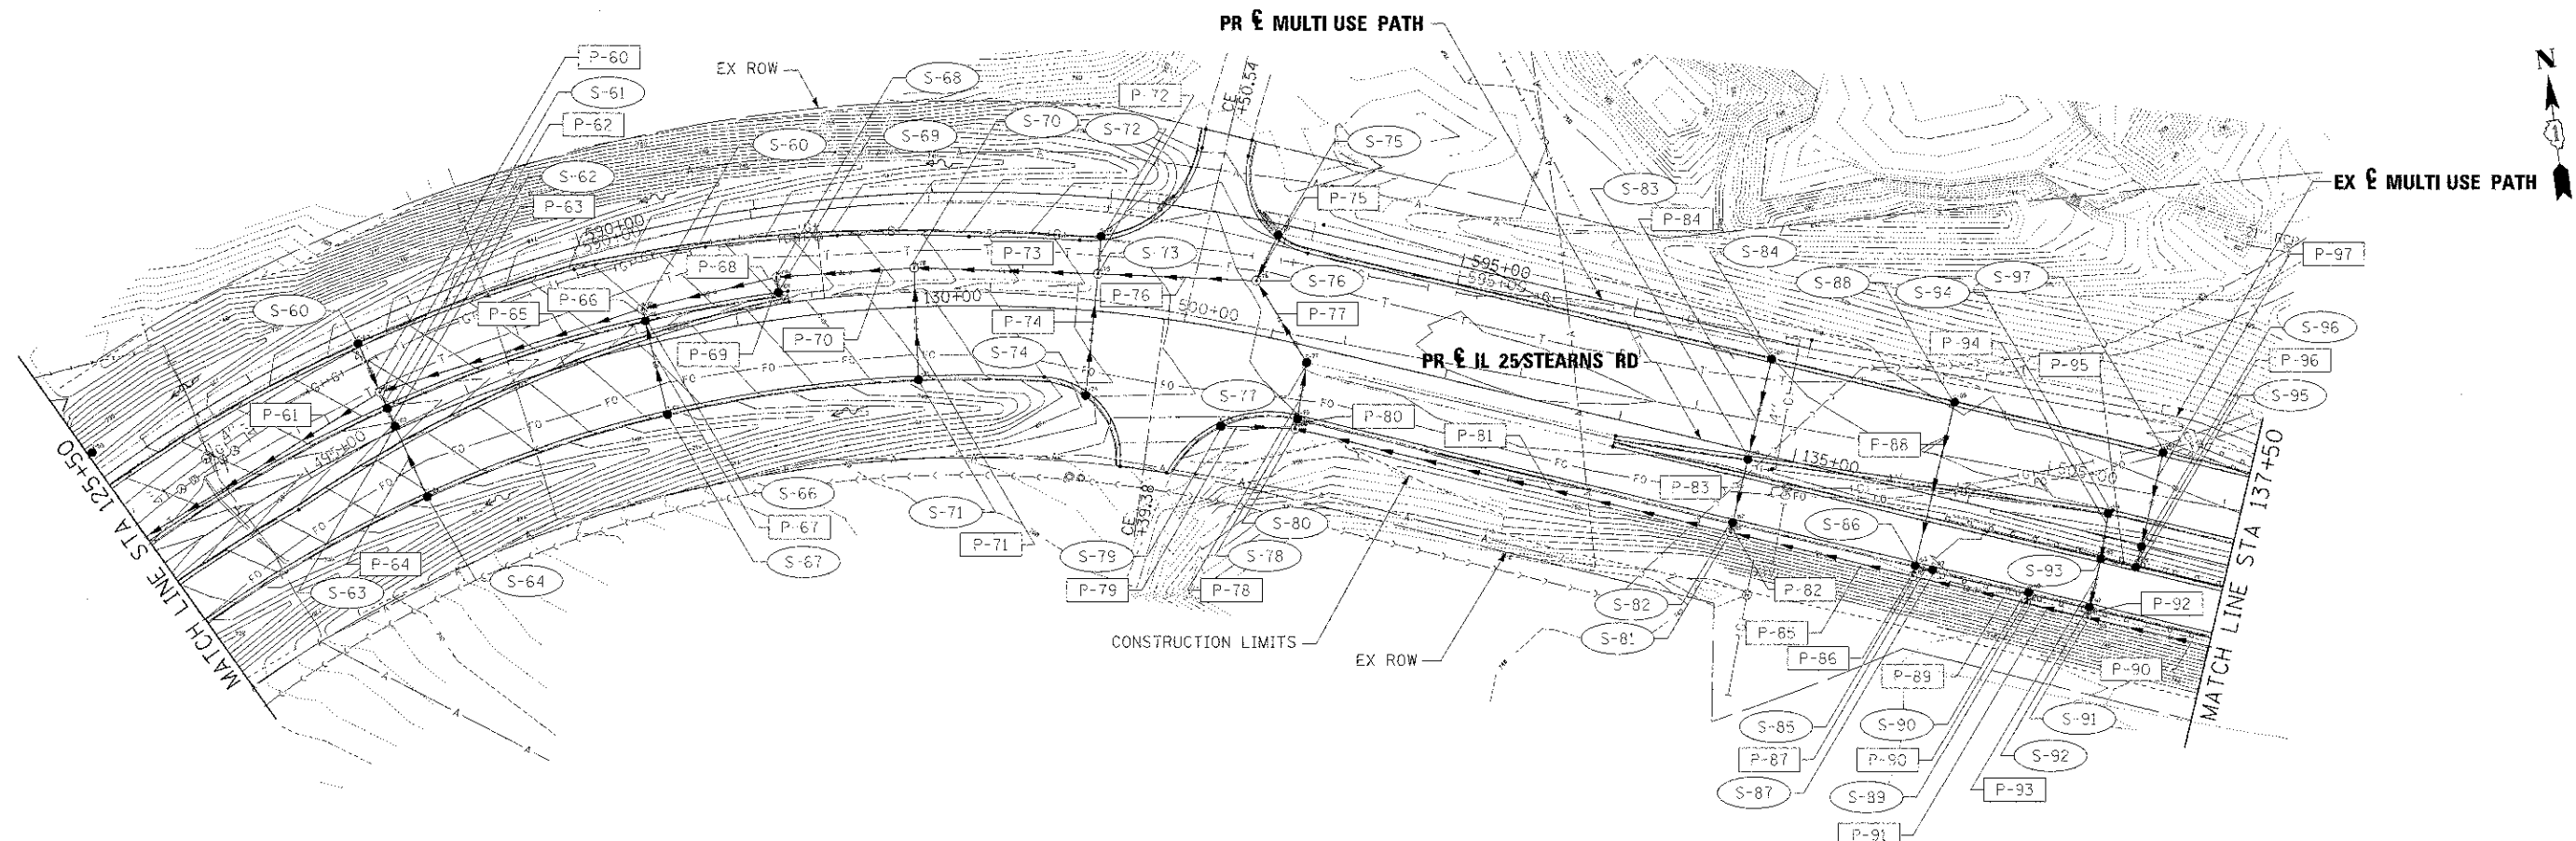

FILE NAME =	DESIGNED AAF	REVISED -		<b>STATE OF ILLINOIS</b> <b>DEPARTMENT OF TRANSPORTATION</b>	<b>DRAINAGE PLANS</b> <b>IL 25 STEARNS RD</b>	SCALE: 1"=50' SHEET NO. 8 OF 10 SHEETS STA. 125+50.00 TO STA. 137+50.00	SECTION 36: 06-00214-18-RP	COUNTY KANE	TOTAL SHEET
ND:63598-18-IL-25-stn-draw-03.dgn	DRAWN TMB	REVISED -							SHEETS NO.
USER NAME = thbank	CHECKED JHM	REVISED -							45   152
PLG DATE = 1/17/2013	DATE 01/18/2013	REVISED -							CONTRACT NO. 63598

ILLINOIS FED. AID PROJECT