


STA. 943+75 LT.
 EXIST. 15" PIPE CS/AA
 EXIST. DOUBLE GUTTER OUTLET W/ 2
 TY. B GRATE, STD. 1795.
 PROP. CONSTRUCT DOUBLE OUTLET FOR
 TY. 2B GUTTER, STD. 606211-03 (MOD.)
 GRATE ELEV: 524.09
 USFL: 522.34
 DSFL: 519.00
 SEE SHEET NO. 12, 13

STA. 947+95 LT.
 EXIST. 24" RCCP
 EXIST. DOUBLE GUTTER OUTLET W/ 2
 TY. B GRATE, STD. 1795 (MOD.)
 PROP. CONSTRUCT DOUBLE OUTLET FOR
 TY. 2B GUTTER, STD. 606211-03 (MOD.)
 USFL: 523.95
 DSFL: 522.70
 SEE SHEET NO. 22

STA. 957+62 LT.
 EXIST. 24" RCCP
 EXIST. DOUBLE GUTTER OUTLET W/ 2
 TY. B GRATE, STD. 1795 (MOD.)
 PROP. CONSTRUCT DOUBLE OUTLET FOR
 TY. 2B GUTTER, STD. 606211-03 (MOD.)
 USFL: 521.90
 DSFL: 521.25
 SEE SHEET NO. 23

STA. 963+50 LT.
 EXIST. 24" RCCP
 EXIST. DOUBLE GUTTER OUTLET W/ 2
 TY. B GRATE, STD. 1795 (MOD.)
 PROP. CONSTRUCT DOUBLE OUTLET FOR
 TY. 2B GUTTER, STD. 606211-03 (MOD.)
 USFL: 523.00
 DSFL: 521.52
 SEE SHEET NO. 24

STA. 968+88 LT.
 EXIST. DOUBLE GUTTER OUTLET W/ 2
 TY. B GRATE, STD. 1795
 PROP. CONSTRUCT DOUBLE OUTLET FOR
 TY. 2B GUTTER, STD. 606211-03 (MOD.)
 SEE SHEET NO. 12, 13

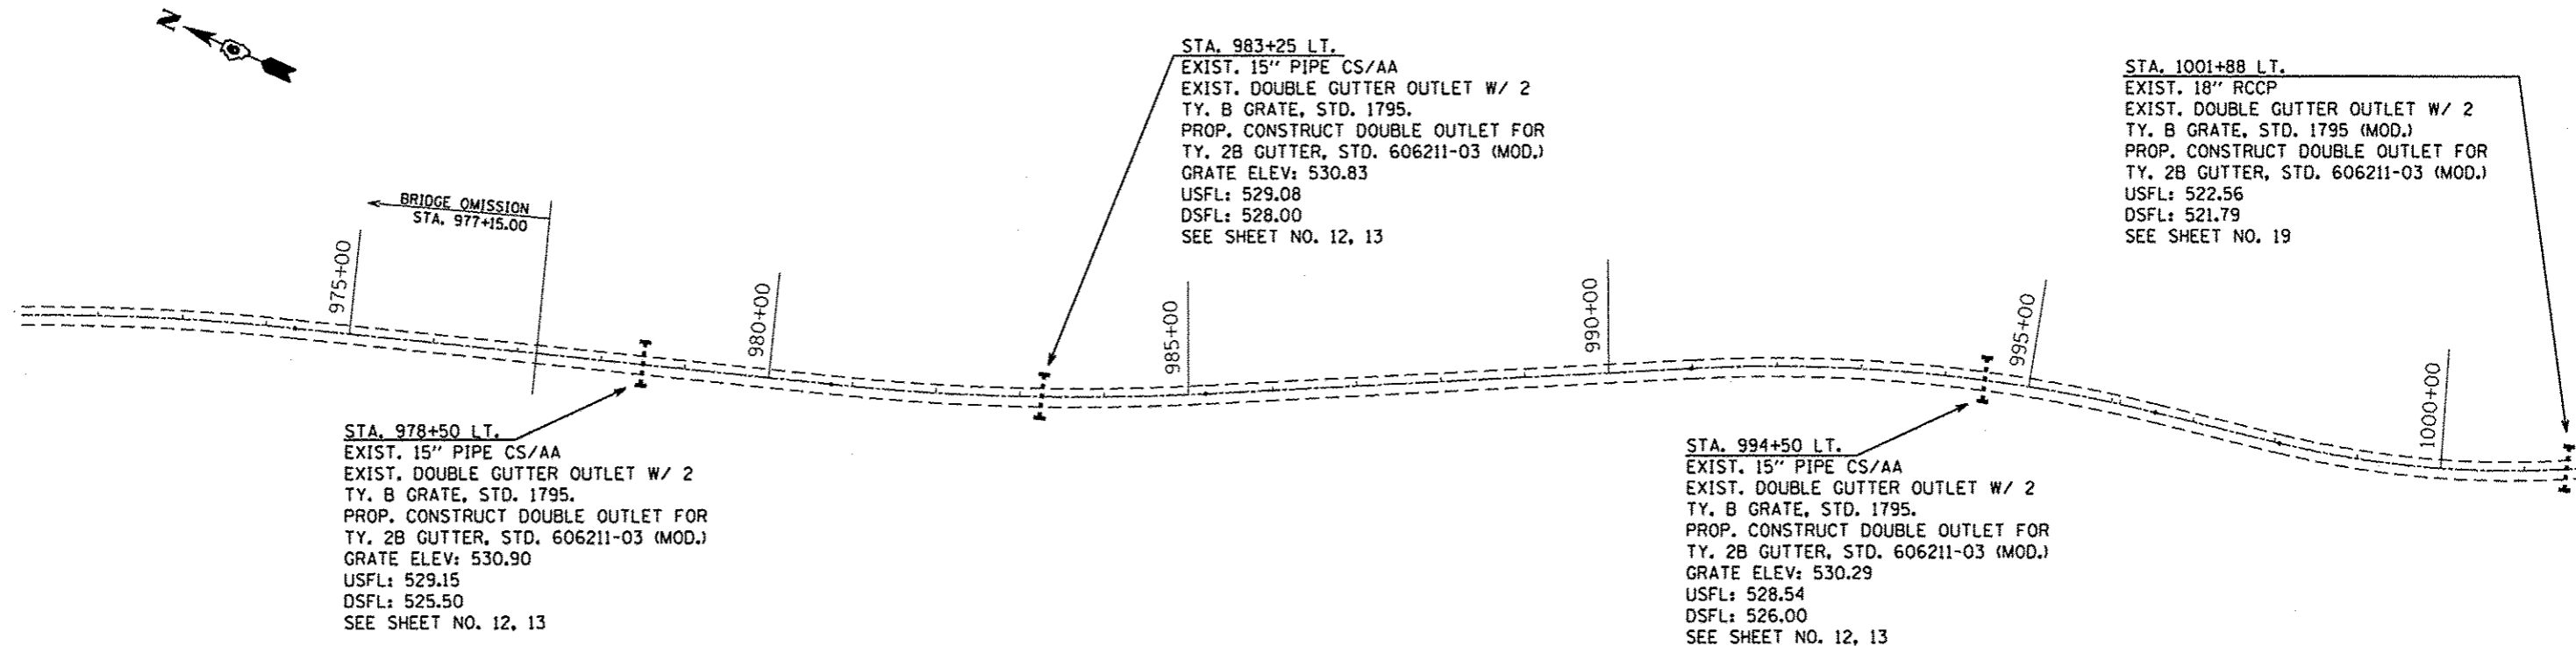

STA. 978+50 LT.
 EXIST. 15" PIPE CS/AA
 EXIST. DOUBLE GUTTER OUTLET W/ 2
 TY. B GRATE, STD. 1795.
 PROP. CONSTRUCT DOUBLE OUTLET FOR
 TY. 2B GUTTER, STD. 606211-03 (MOD.)
 GRATE ELEV: 530.90
 USFL: 529.15
 DSFL: 525.50
 SEE SHEET NO. 12, 13

STA. 983+25 LT.
 EXIST. 15" PIPE CS/AA
 EXIST. DOUBLE GUTTER OUTLET W/ 2
 TY. B GRATE, STD. 1795.
 PROP. CONSTRUCT DOUBLE OUTLET FOR
 TY. 2B GUTTER, STD. 606211-03 (MOD.)
 GRATE ELEV: 530.83
 USFL: 529.08
 DSFL: 528.00
 SEE SHEET NO. 12, 13

STA. 994+50 LT.
 EXIST. 15" PIPE CS/AA
 EXIST. DOUBLE GUTTER OUTLET W/ 2
 TY. B GRATE, STD. 1795.
 PROP. CONSTRUCT DOUBLE OUTLET FOR
 TY. 2B GUTTER, STD. 606211-03 (MOD.)
 GRATE ELEV: 530.29
 USFL: 528.54
 DSFL: 526.00
 SEE SHEET NO. 12, 13

STA. 1001+88 LT.
 EXIST. 18" RCCP
 EXIST. DOUBLE GUTTER OUTLET W/ 2
 TY. B GRATE, STD. 1795 (MOD.)
 PROP. CONSTRUCT DOUBLE OUTLET FOR
 TY. 2B GUTTER, STD. 606211-03 (MOD.)
 USFL: 522.56
 DSFL: 521.79
 SEE SHEET NO. 19

FILE NAME *	USER NAME * ahahdm	DESIGNED -	REVISED -	STATE OF ILLINOIS DEPARTMENT OF TRANSPORTATION	DRAINAGE PLANS	F.A.P. RTE.	SECTION	COUNTY	TOTAL SHEETS	SHEET NO.	
Plot Scale * N/A	Drawn - DMS	Checked -	Revised -			510	(120)T	HANCOCK	28	9	
Plot Date * Nov-28-2012 10:00:29AM	DATE -	REVISED -	REVISED -			CONTRACT NO. 72F73					
Default	DATE -	REVISED -	REVISED -			ILLINOIS FED. AID PROJECT					

SCALE: N/A SHEET 4 OF 6 SHEETS STA. 942+50 TO STA. 1002+00