
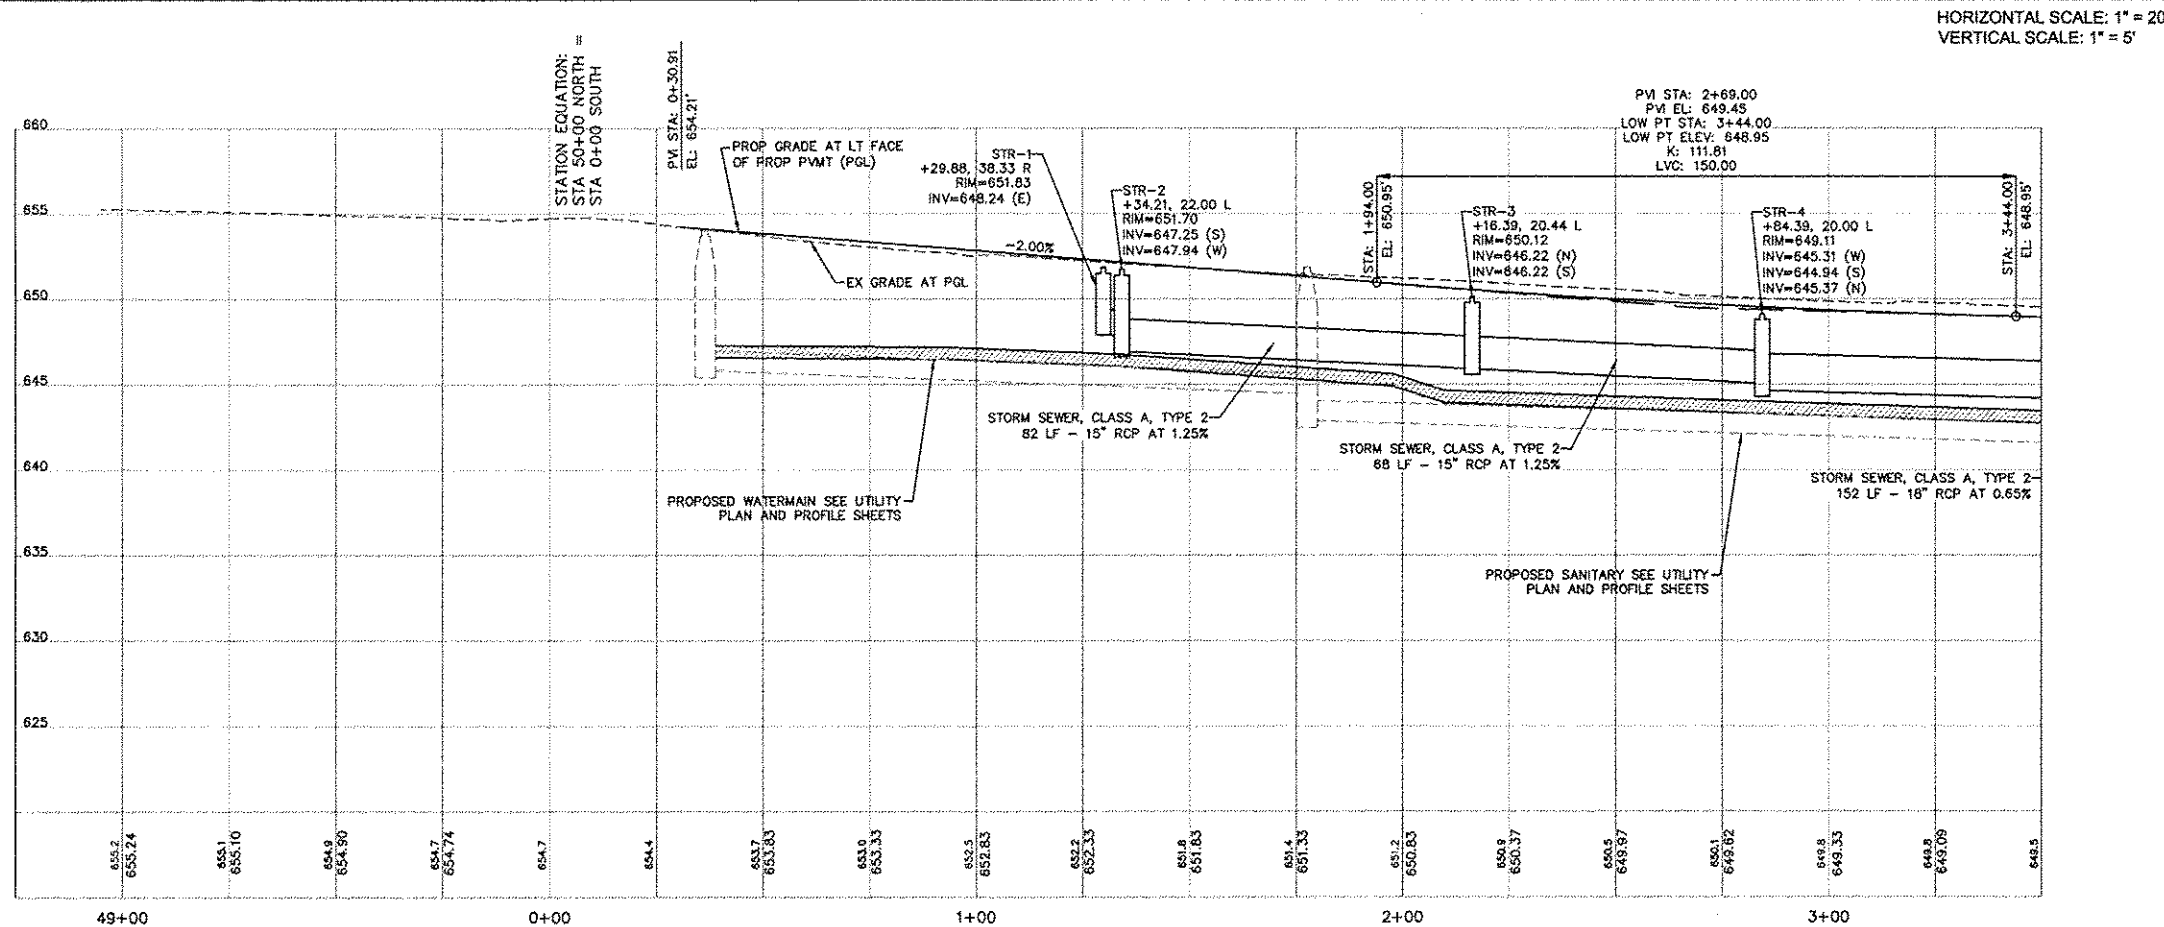


G:\2010MUNWA10M008-Geneseo-S.State St. SewerWaterDrawings\Plot\A10M008 DRAINAGE PLAN PROFILES.dwg, 3/7/2013 9:36:56 AM, jelfm

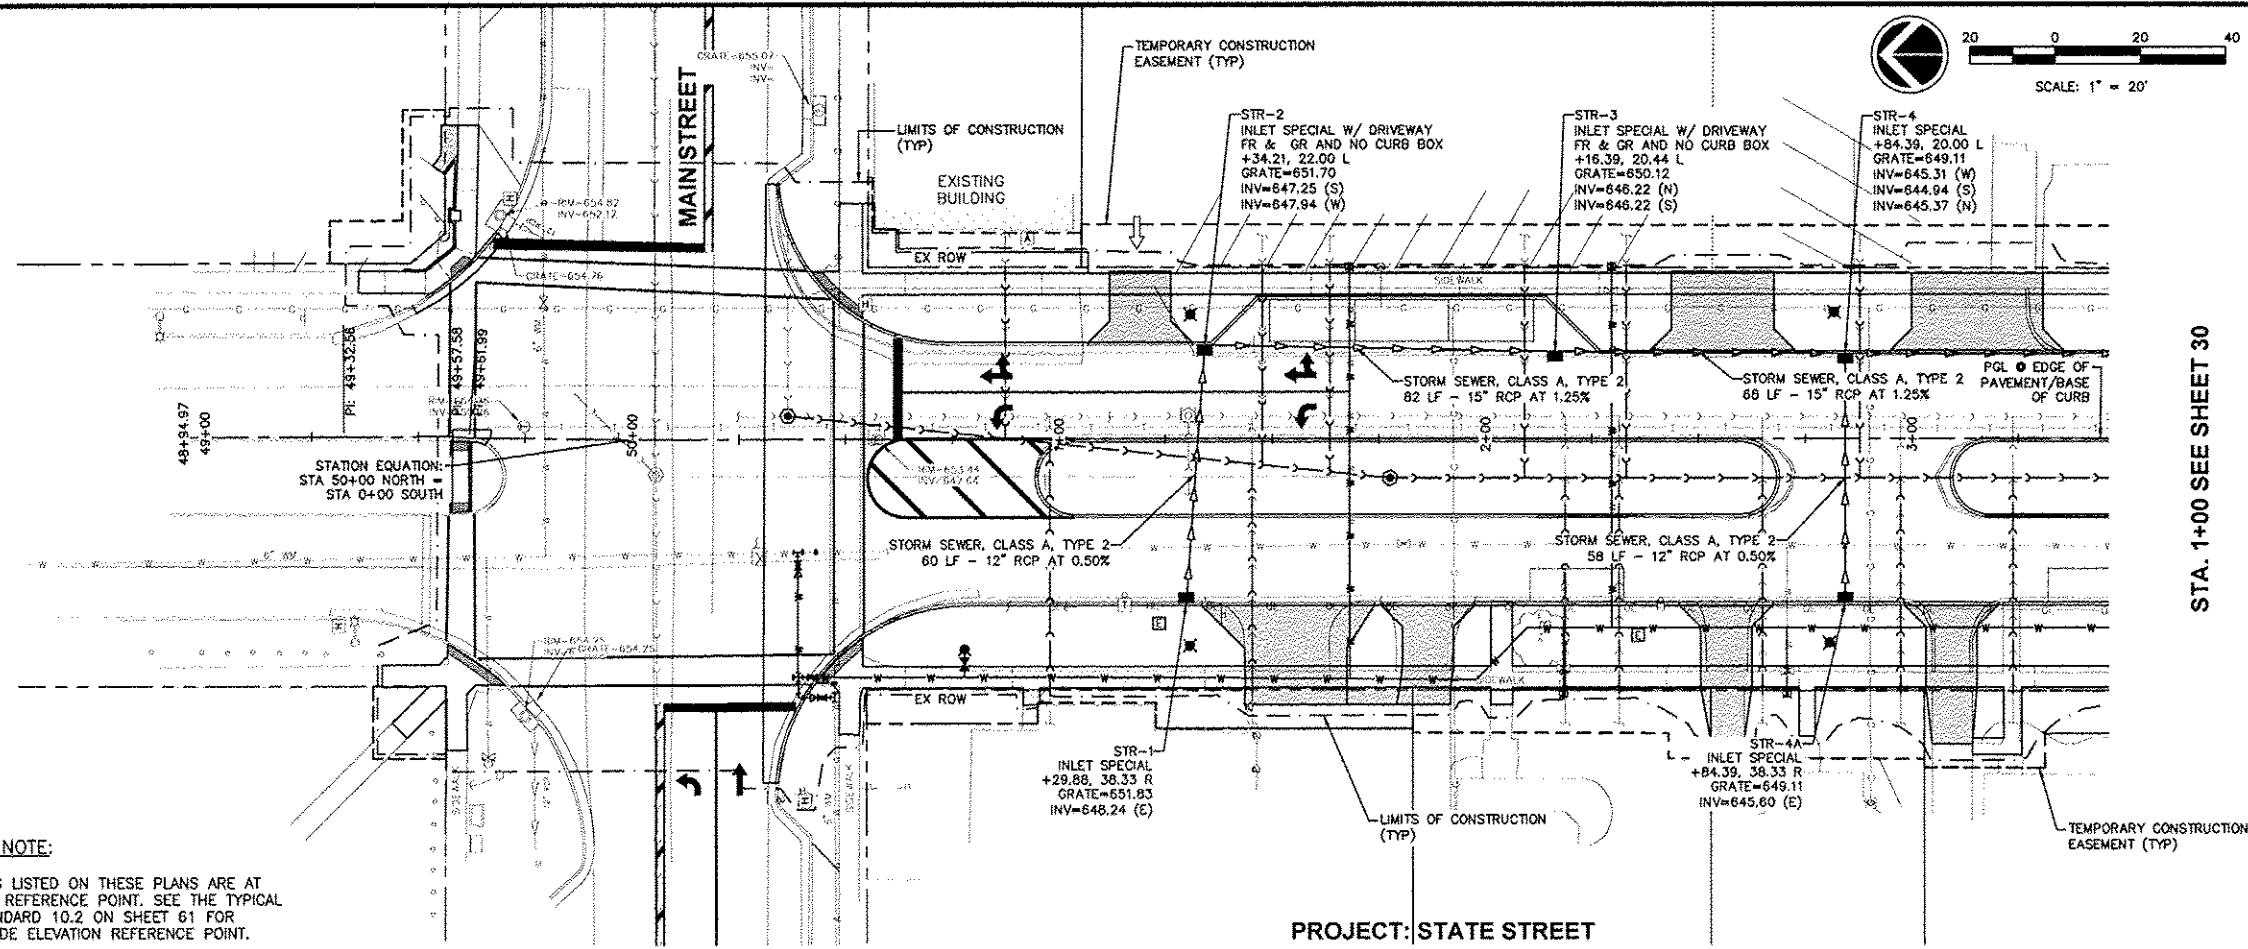

NO.	REVISIONS DESCRIPTION	DATE

Missman, inc.
 Professional Engineers & Land Surveyors

Rock Island, IL • Bettendorf, IA • Rockford, IL • Sycamore, IL
 (309) 780-7644 • (663) 344-0260 • (815) 965-6400 • (815) 995-3825
 www.missman.com

STATE STREET RE-CONSTRUCTION
 GENESE0, ILLINOIS

DRAINAGE PLAN AND PROFILE - 1

Missman Project No: A10M008
 File Name: A10M008 DRAINAGE PLAN
 © COPYRIGHT 2013 ALL RIGHTS RESERVED
 Field Book No: #####
 Drawn By: WKS
 Checked By: JLM
 Date: 11/19/2012

29
 Sheet 29 of 99

IL DESIGN FIRM NO. 184-000843