


STATE OF ILLINOIS
DEPARTMENT OF TRANSPORTATION


ROUTE NO.	SECTION	COUNTY	TOTAL SHEETS	SHEET NO.
F.A.P.	05-00130-00-BR	WILL	40	10
FED. ROAD DIST. NO. 7		ILLINOIS	FED. AID PROJECT	

CONTRACT NO. 83889

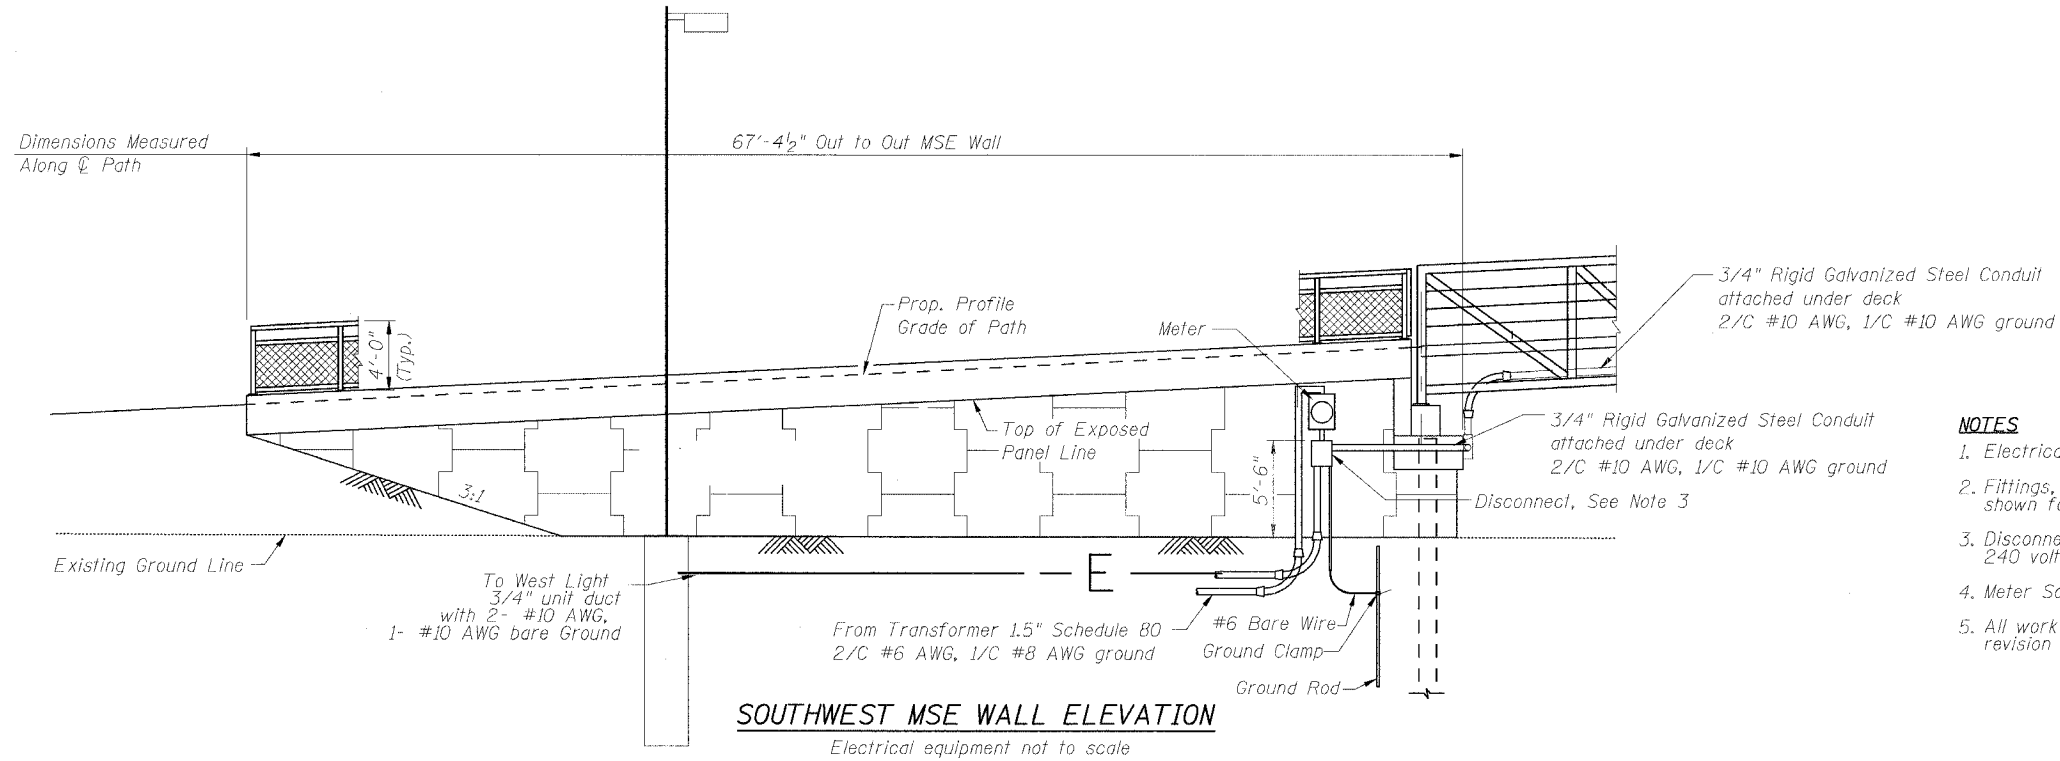

NOTES

1. Electrical items are shown not to scale for clarity.
2. Fittings, elbows, LBs, expansion joints and other misc. fittings and brackets are not shown for clarity. All items required to complete the work shall be included.
3. Disconnect shall be lockable in the on and off positions. Breaker shall be rated for 240 volts, 2 pole 30 amps.
4. Meter Socket must be certified for use with Commonwealth Edison.
5. All work to conform to Section 800 of IDOT Standard specifications and the latest revision of the NEC.

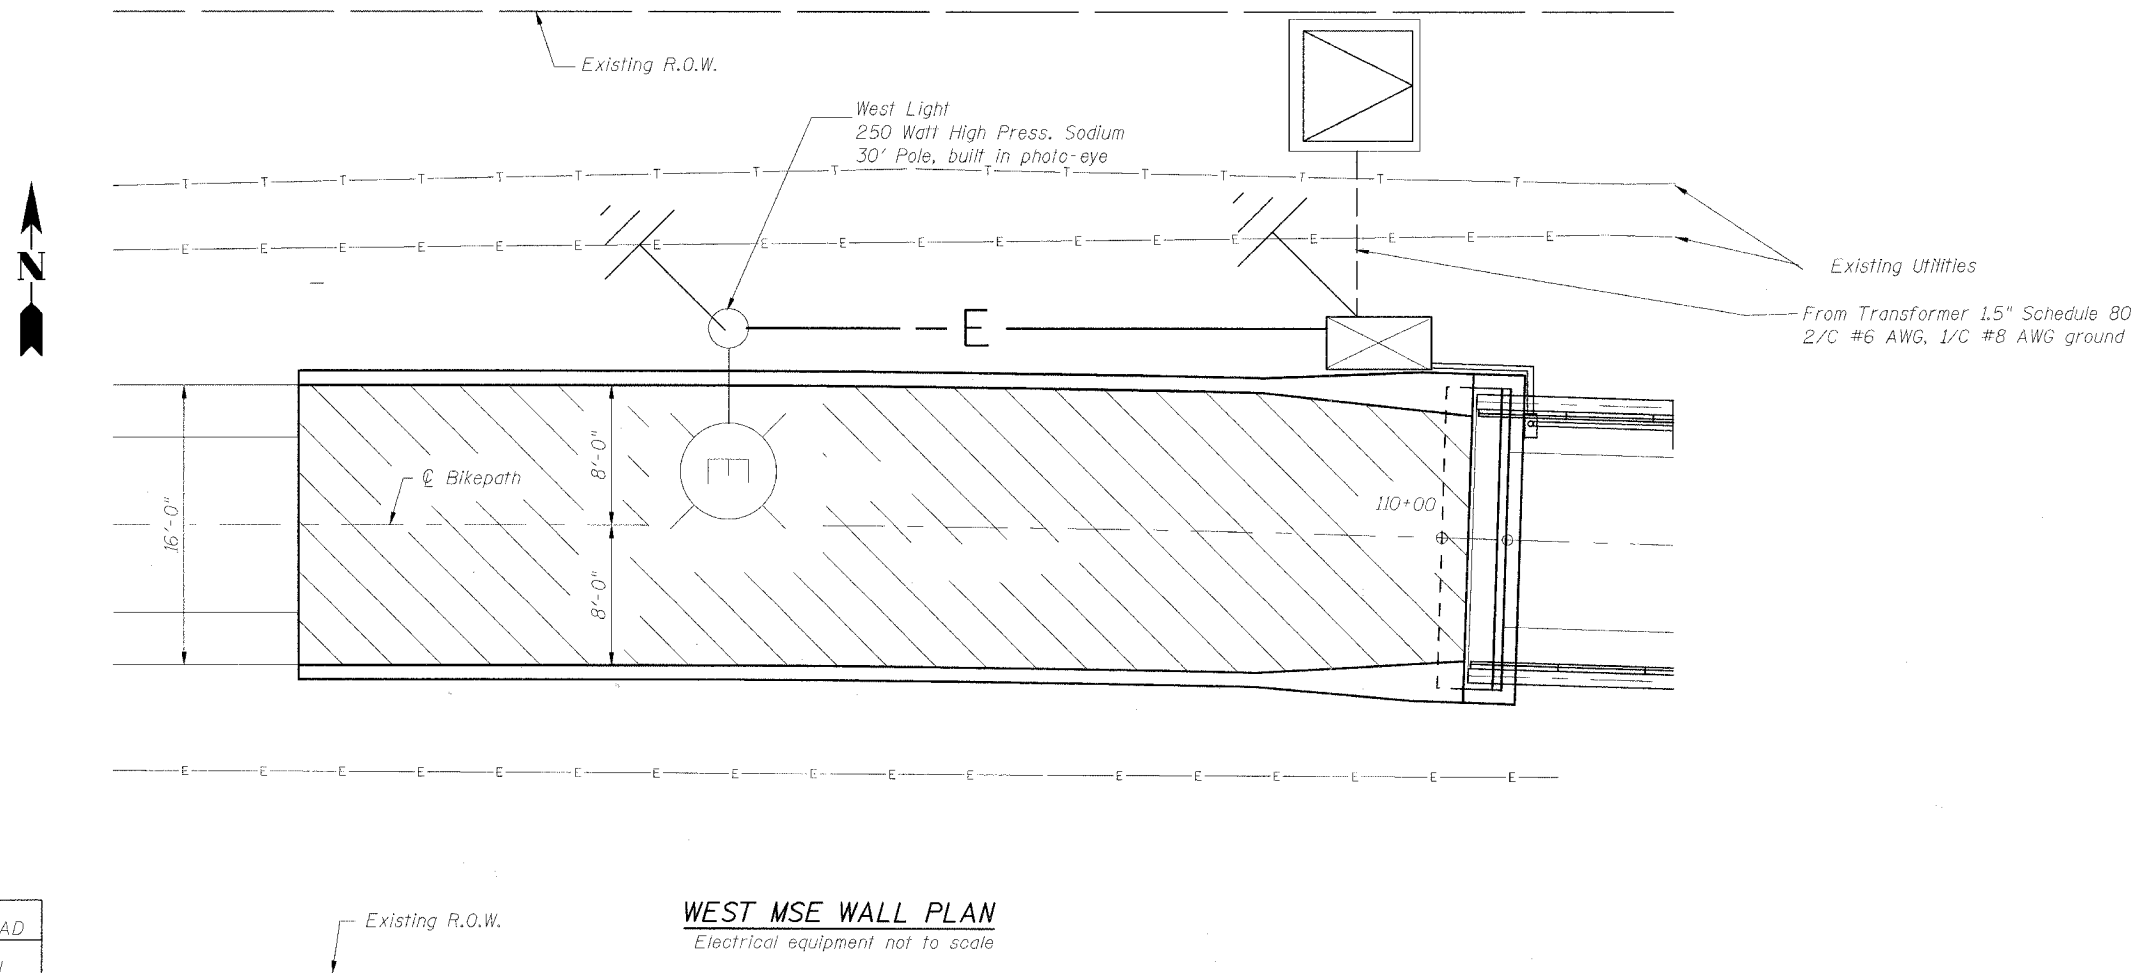

DESIGNED	DAD
CHECKED	DL
DRAWN	SOI
CHECKED	

REVISIONS	
NAME	DATE

ILLINOIS DEPARTMENT OF TRANSPORTATION
WEST MSE PLAN & ELEV
ELECTRICAL DETAILS
ROUTE 59 PEDESTRIAN BRIDGE
CITY OF NAPERVILLE, WILL COUNTY

URS
100 South Wacker Drive,
Suite 500
Chicago, IL 60606
(312) 939-1000

RTE. 59
STATION 113+02.46
SCALE: N.T.S.

SECTION: 05-00130-00-BR
STRUCTURE NO. 099-6002
DATE: 12-8-2006