
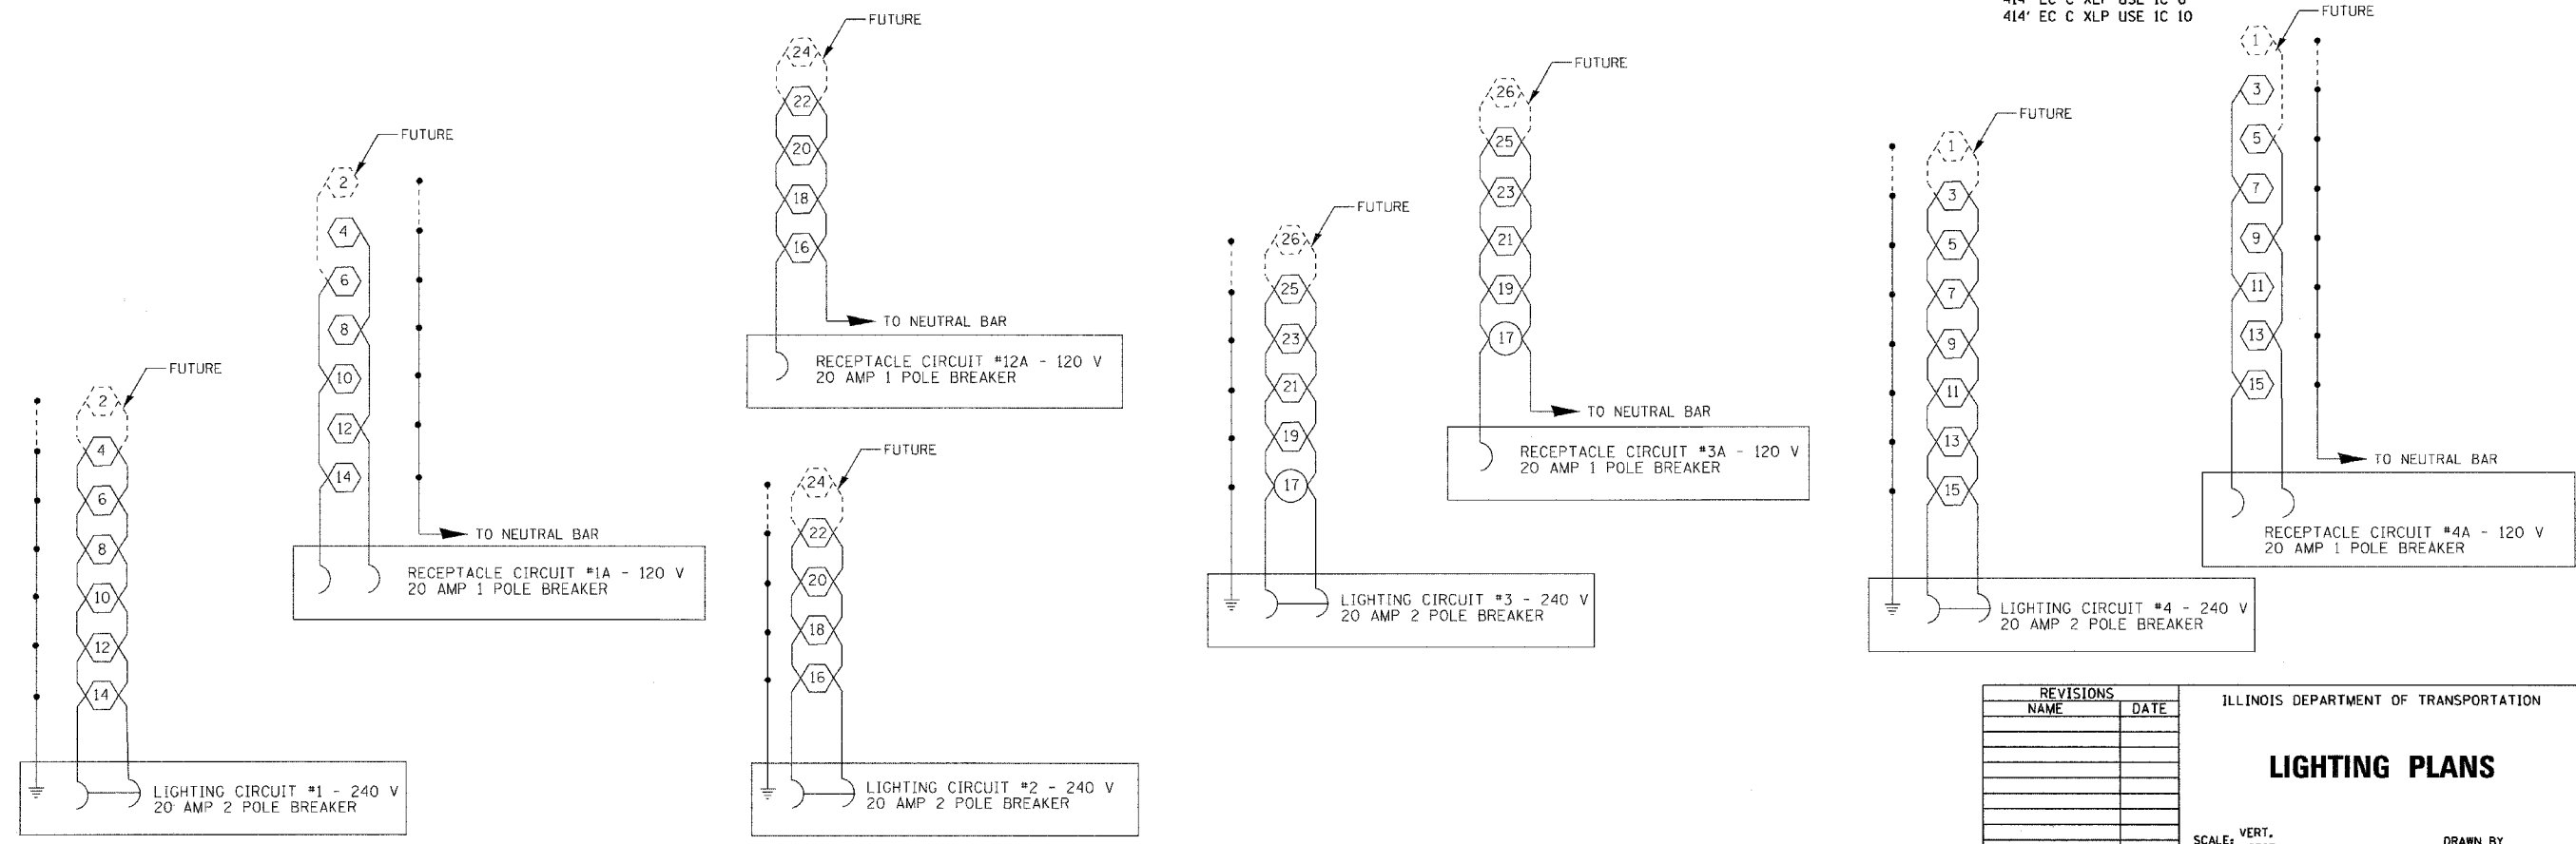


F.A. RTE.	SECTION	COUNTY	TOTAL SHEETS	SHEET NO.
6800	05-00012-00-FF	HENRY	75	50
STA. 10+16.37		TO STA. 16+00		
FED. ROAD DIST. NO.	ILLINOIS	FED. AID PROJECT		

LIGHTING PLANS

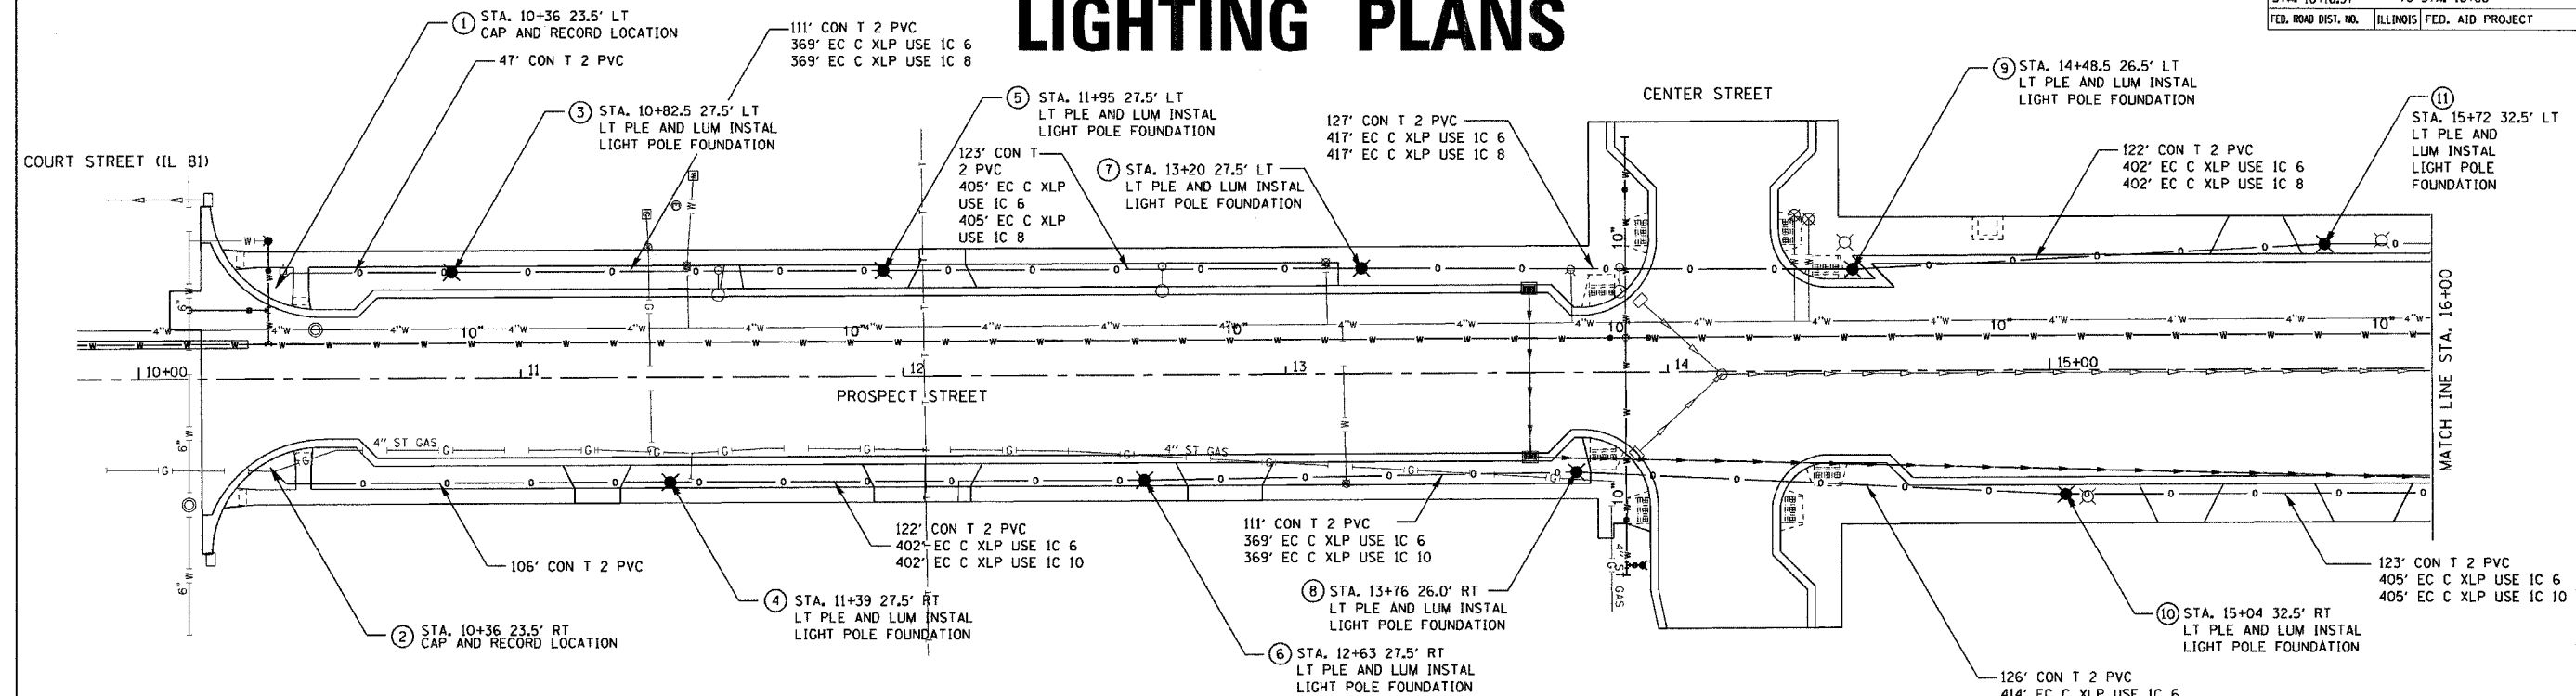

PLOT DATE
 FILE NAME
 PLOT SCALE
 USER NAME

REVISIONS	
NAME	DATE

ILLINOIS DEPARTMENT OF TRANSPORTATION

LIGHTING PLANS

SCALE: VERT.
 HORIZ.
 DATE

DRAWN BY
 CHECKED BY