
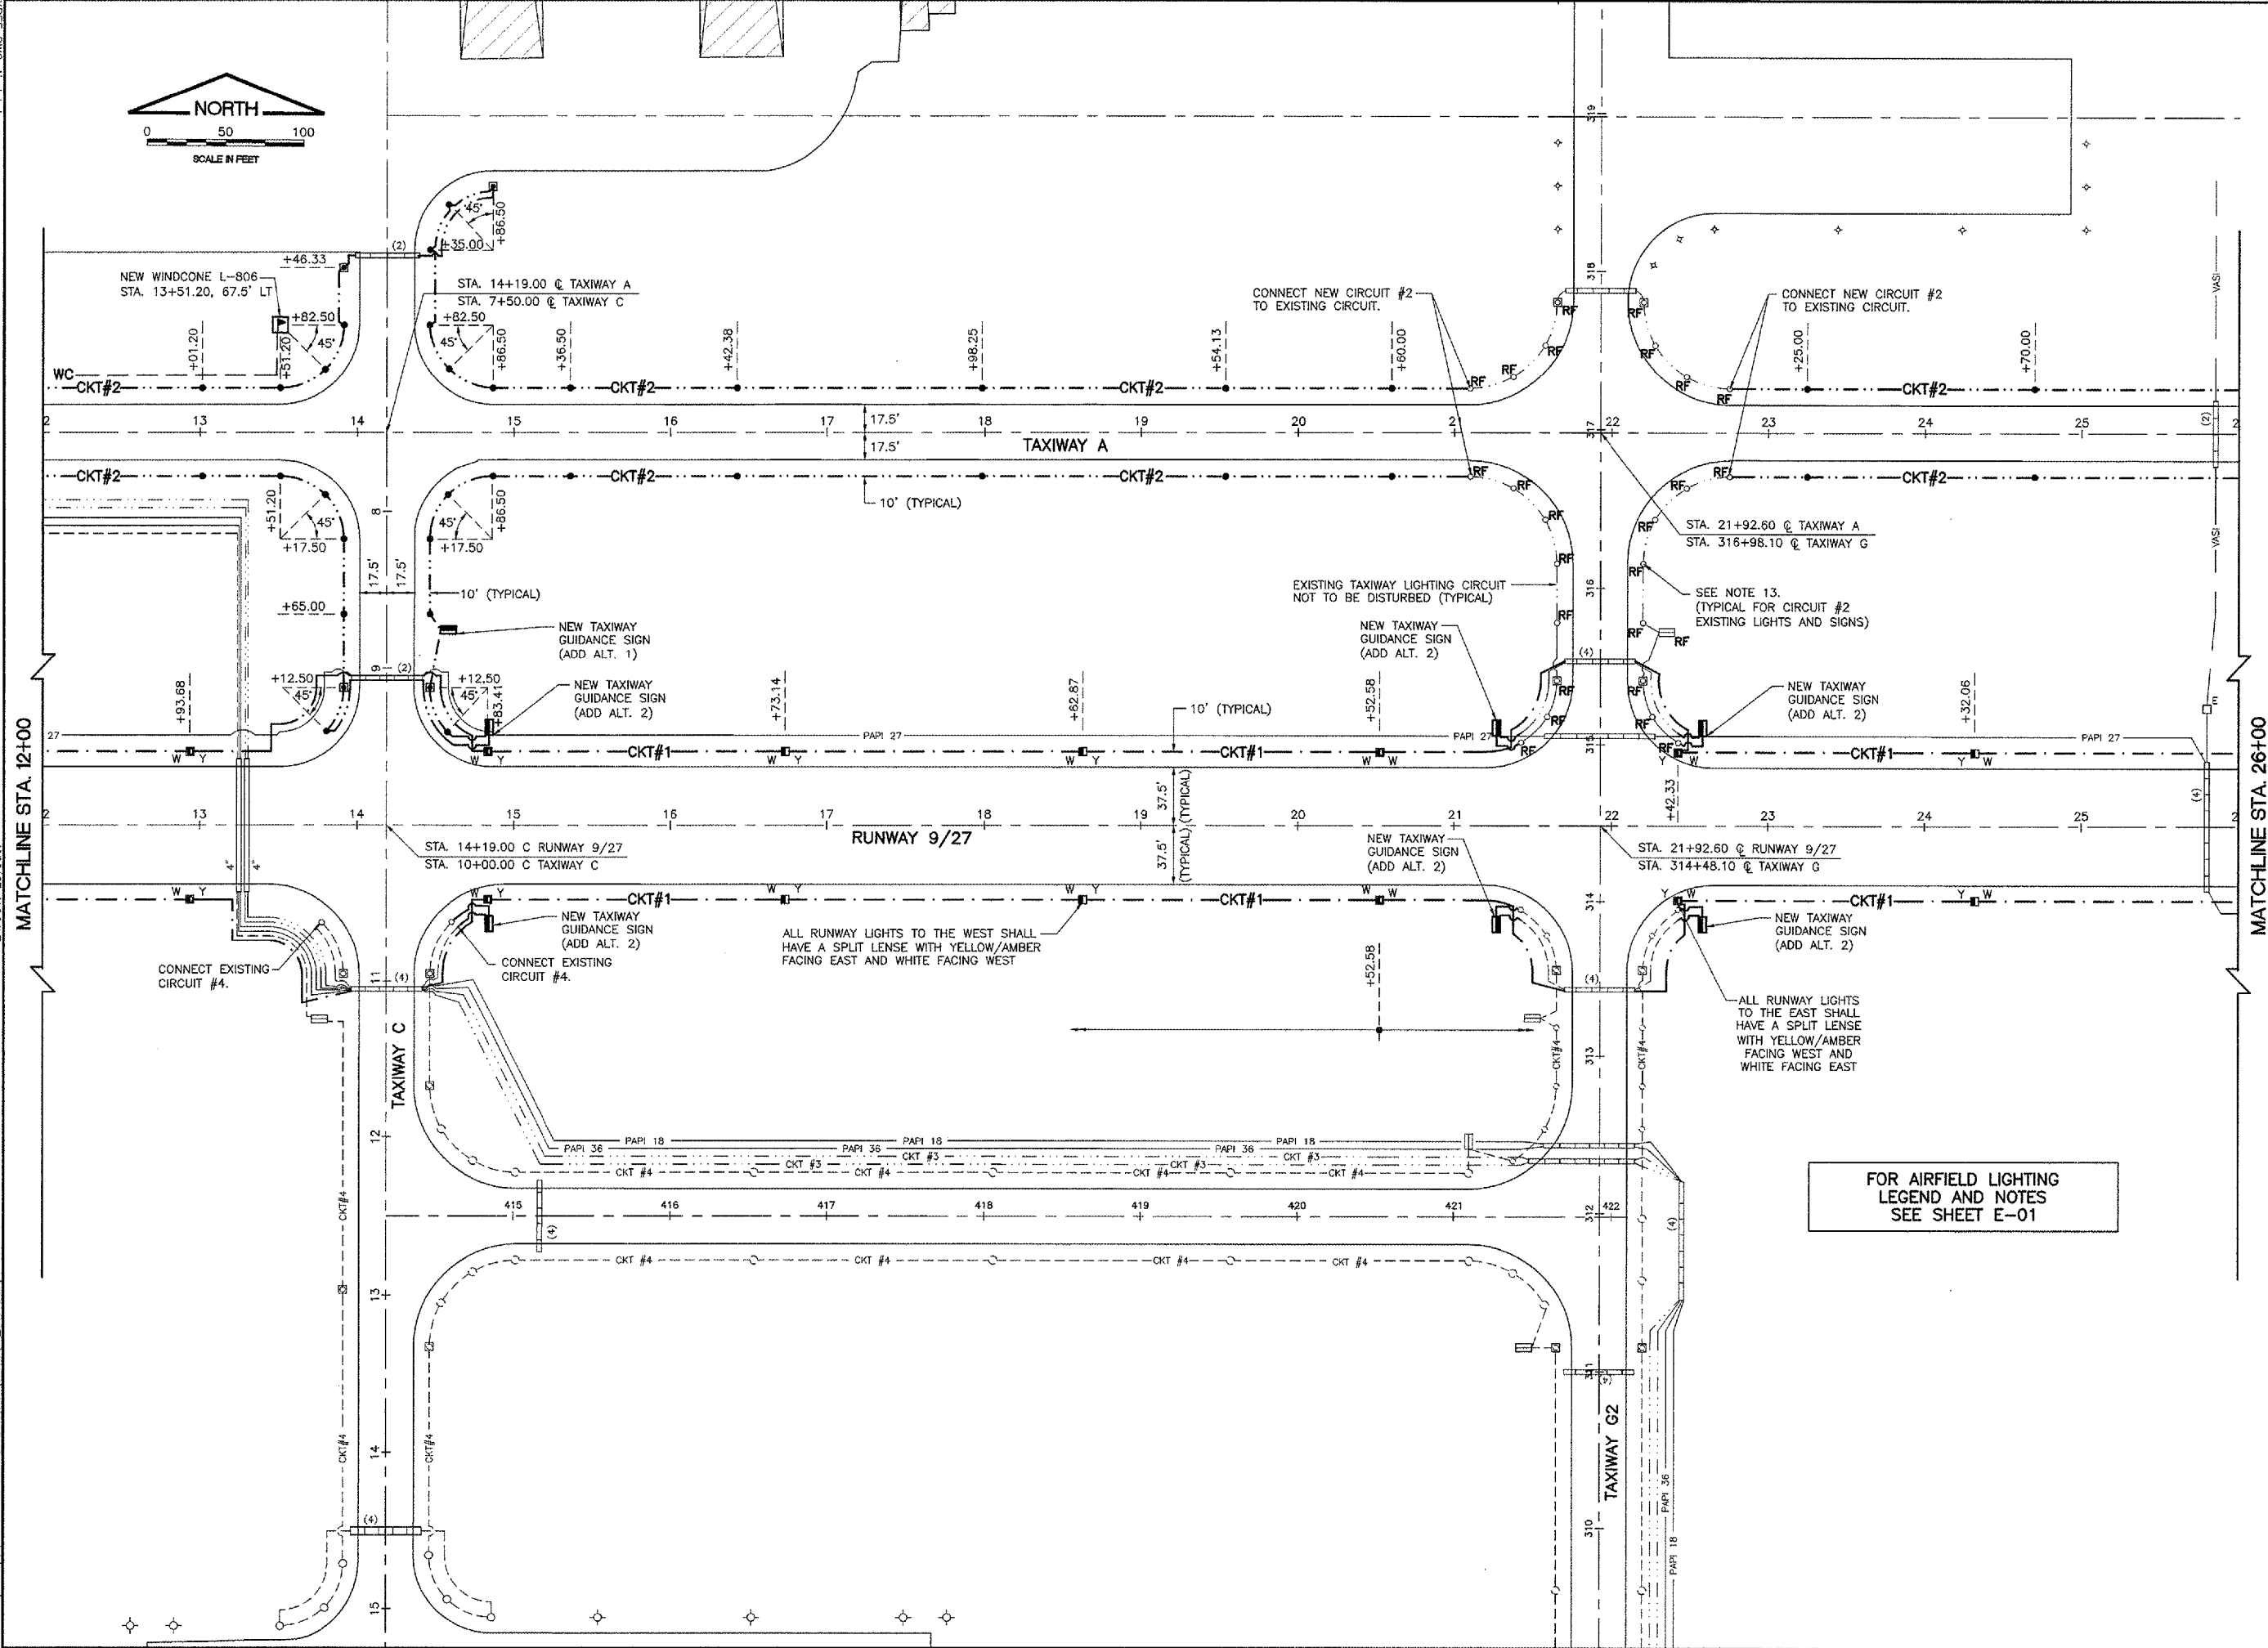


6wmc_dwg_tech.dwg
 1b-dwg
 lan-bose.dwg
 lan-bose-add012.dwg

UPDATE BY: Jason Dove
 LAYOUT: Layout1

DATE: Thursday, March 08, 2007 9:01:12 PM
 FILE: K:\lansing\0629702 Rehab 9-27 Elec\Draw\Sheets\14-elic-2.dwg

 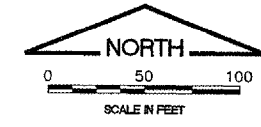


FOR AIRFIELD LIGHTING
 LEGEND AND NOTES
 SEE SHEET E-01

IL CONTRACT: LA036
 IL LETTING ITEM: 2A
 IL PROJECT: IGO-3565
 A.I.P. PROJECT: 3-17-0121-B25

SURVEY BOOK # BOOK #

REVISIONS		
NUMBER	BY	DATE



VILLAGE OF LANSING
 LANSING MUNICIPAL AIRPORT
 LANSING, ILLINOIS

REHABILITATE AIRFIELD LIGHTING SYSTEM
 AIRFIELD LIGHTING PLAN
 RUNWAY 9/27
 STA. 12+00 TO STA. 26+00

© Copyright CMT, Inc.

CMT
 CRAWFORD, MURPHY & TULLY, INC.
 CONSULTING ENGINEERS
 License No. 184-000613

DESIGN BY:	JWD
DRAWN BY:	JRO
CHECKED BY:	DKP
APPROVED BY:	----
DATE:	02 MARCH 2007
JOB No:	06297-02

E-02