


XREF: DWG: tacint.dwg
 15.dwg
 15-base.dwg
 15-base_addtbl.dwg

UPDATE BY: Jason Dove
 LAYOUT: Layout1

DATE: Thursday, March 08, 2007 9:01:17 PM
 FILE: K:\Lansing\0629702 Rehab 9-27 Elec\Draw\Sheets\15.dwg

 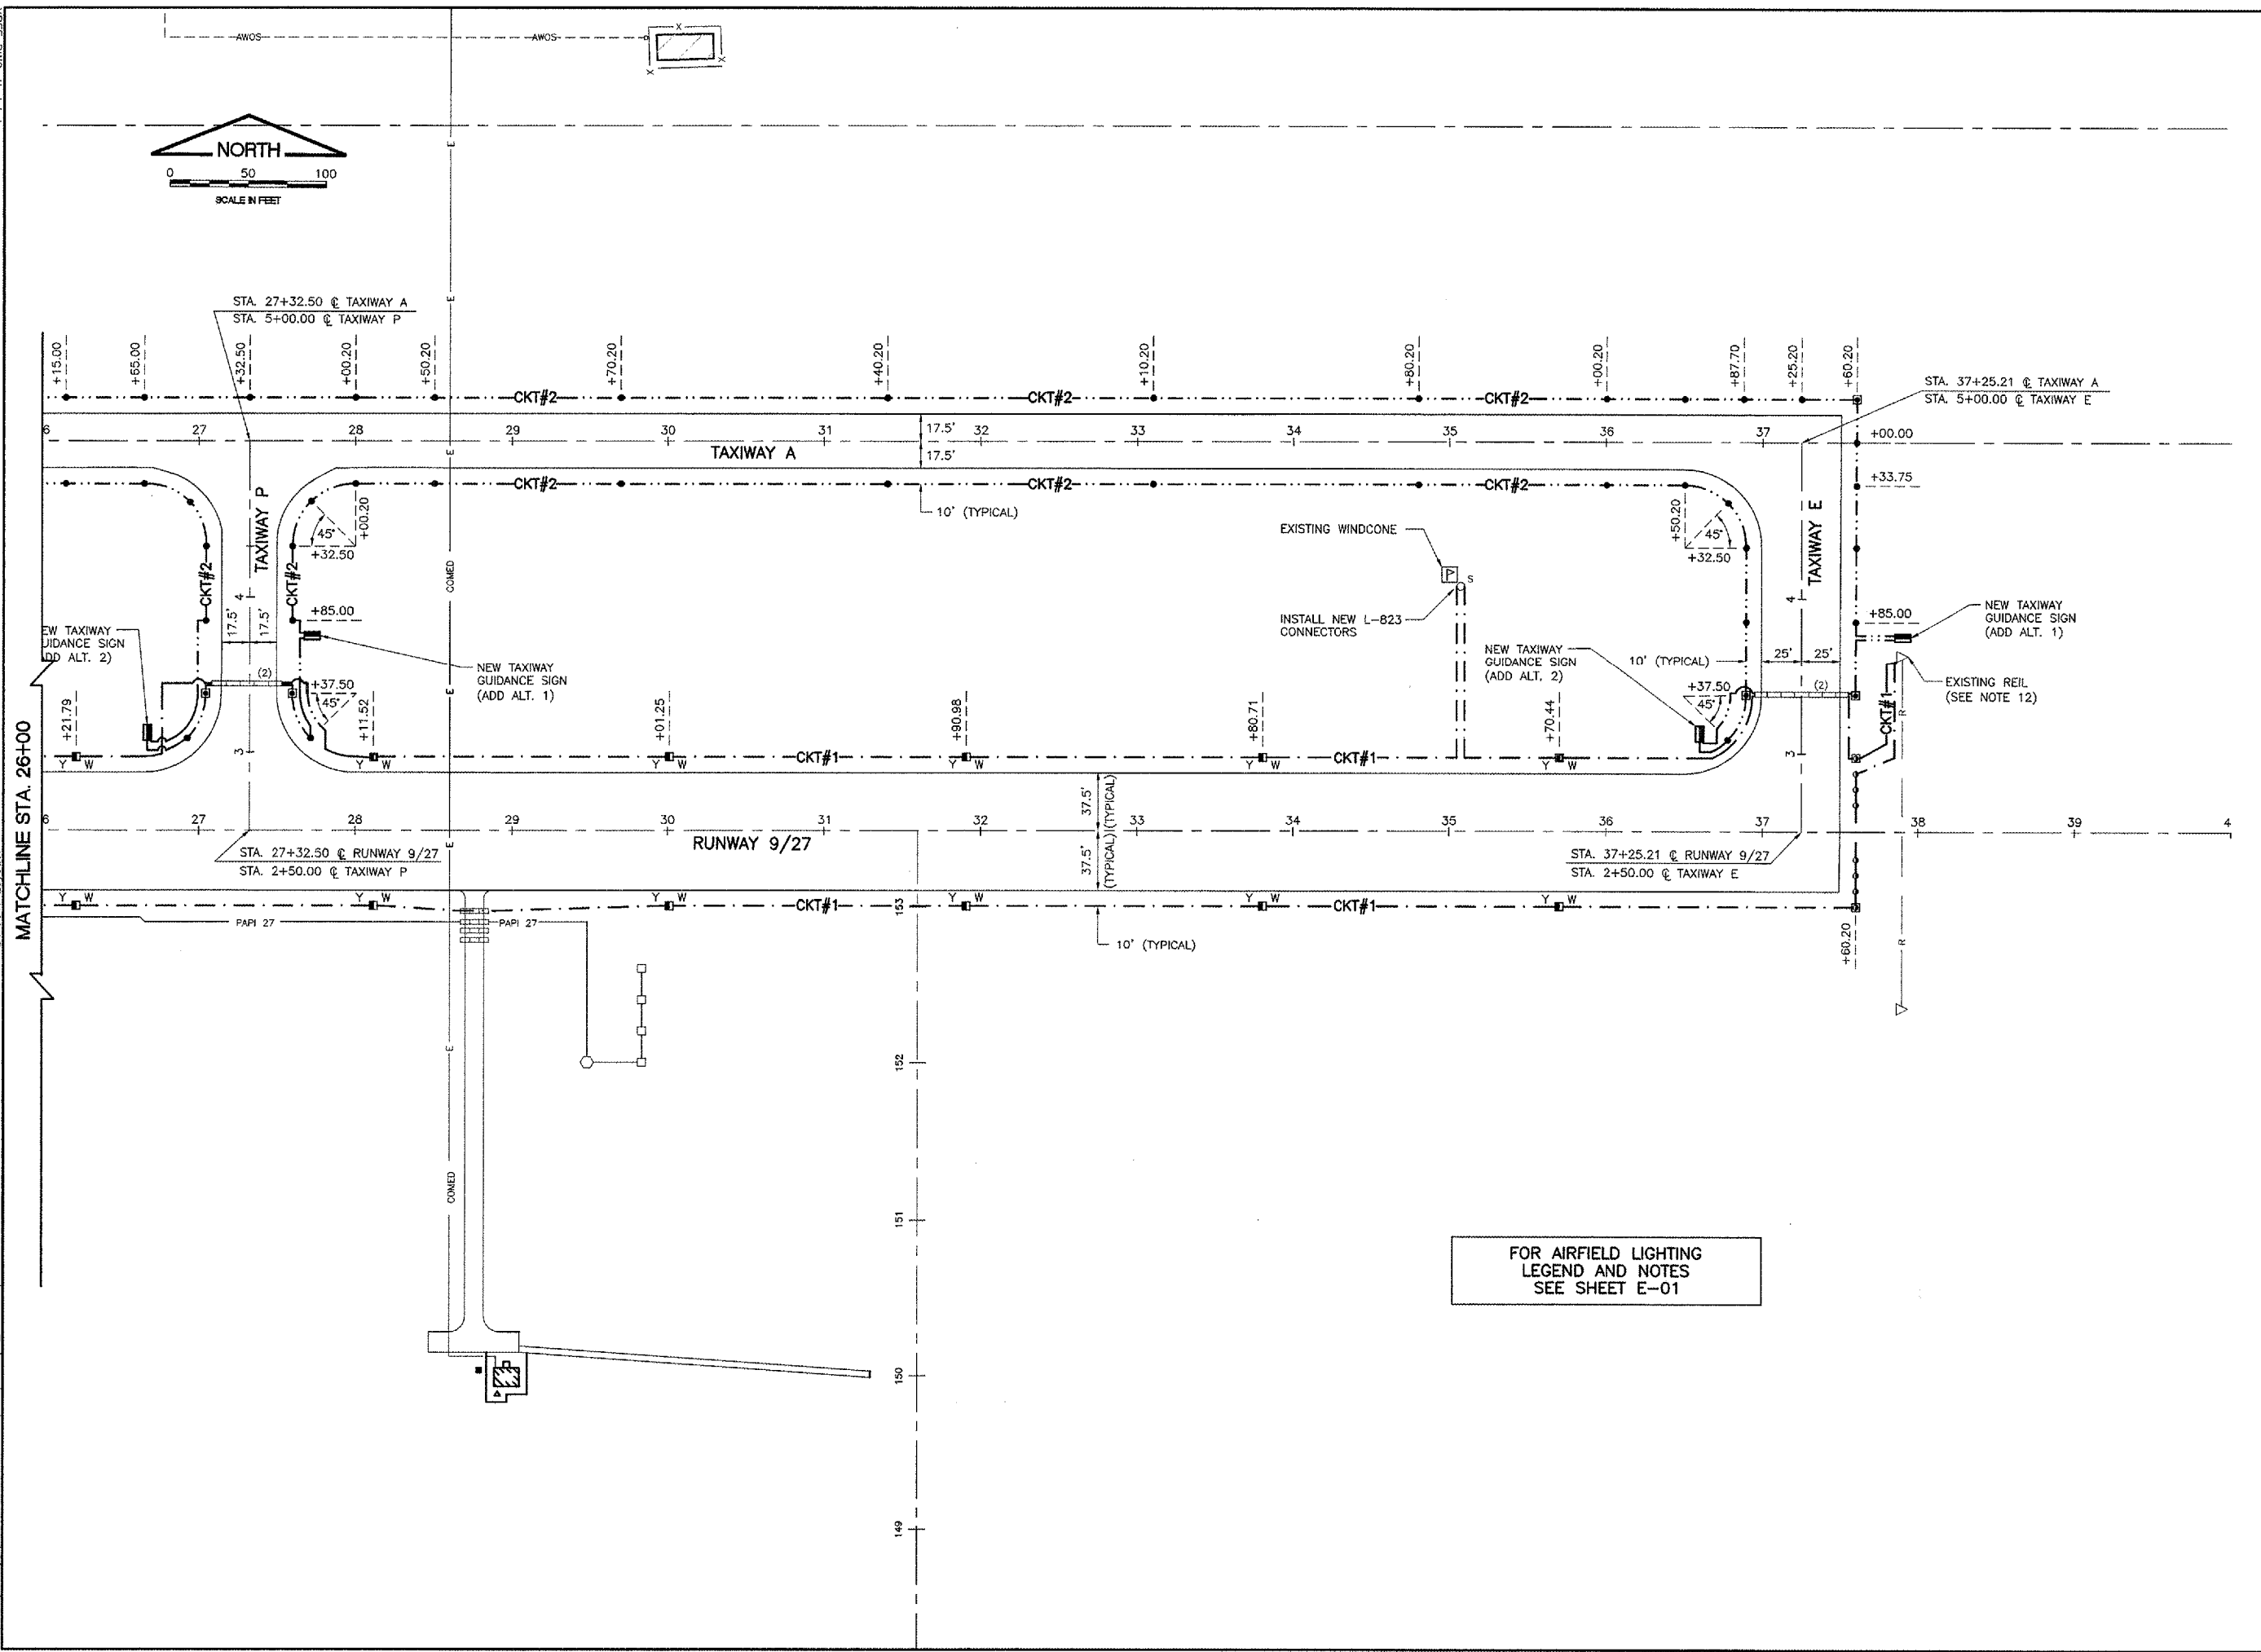


FOR AIRFIELD LIGHTING
 LEGEND AND NOTES
 SEE SHEET E-01

I.L. CONTRACT: **LA036**
 I.L. LETTING ITEM: **2A**
 I.L. PROJECT: **IGQ-3565**
 A.I.P. PROJECT: **3-17-0121-B25**

SURVEY BOOK # BOOK #

REVISIONS		
NUMBER	BY	DATE



**VILLAGE OF LANSING
 LANSING MUNICIPAL AIRPORT
 LANSING, ILLINOIS**

**REHABILITATE AIRFIELD LIGHTING SYSTEM
 AIRFIELD LIGHTING PLAN
 RUNWAY 9/27
 STA. 26+00 TO STA. 40+00**

© Copyright CMT, Inc.
CMT
 CRAWFORD, MURPHY & TILLY, INC.
 CONSULTING ENGINEERS
 License No. 184-000613



DESIGN BY:	JWD
DRAWN BY:	JRO
CHECKED BY:	DKP
APPROVED BY:	---
DATE:	02 MARCH 2007
JOB No:	06297-02

E-03