


5mp 2100pp1-escq-uni  
 5mp/escq-uni  
 5mp.q1  
 5mp.tbl001 : 3/24/07

UPDATE BY: Jason Dove  
 LAYOUT: Layout1

DATE: Thursday, March 08, 2007 9:01:22 PM  
 FILE: K:\Lansing\0629702 Rehab 9-27\_Elec\Draw\Sheets\16\_elec-vault.dwg

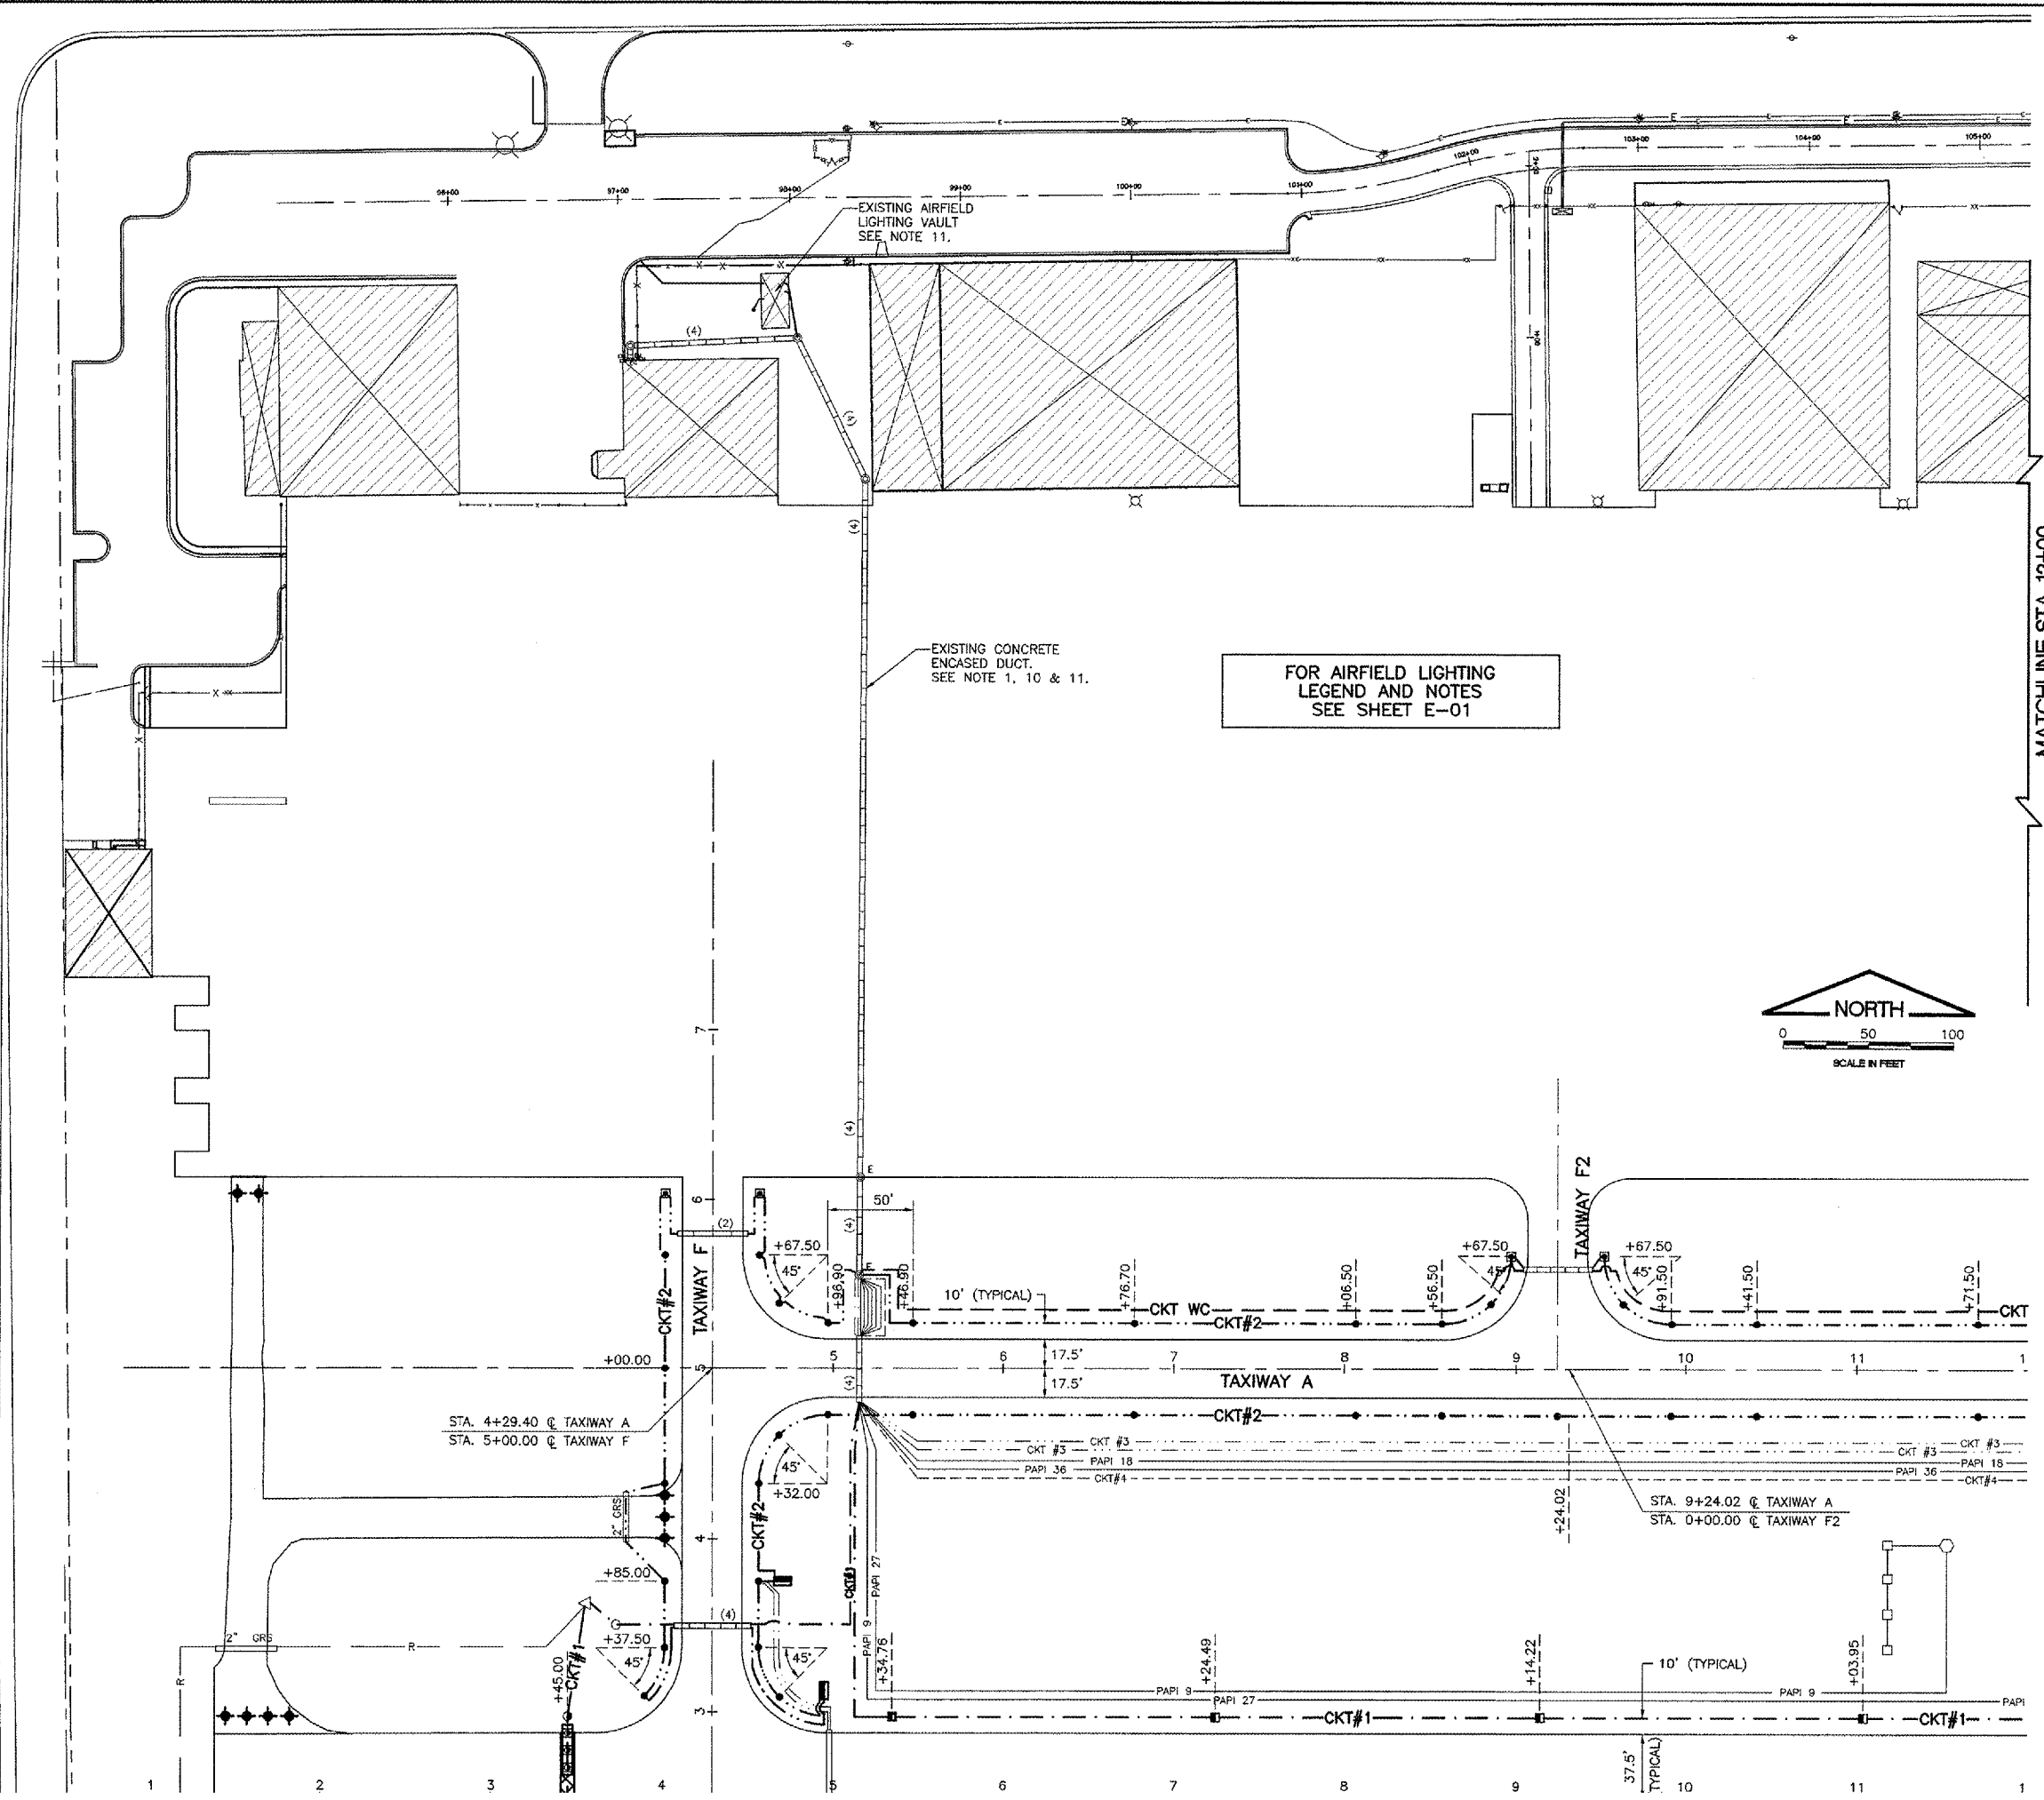

FOR AIRFIELD LIGHTING  
 LEGEND AND NOTES  
 SEE SHEET E-01



MATCHLINE STA. 12+00

IL. CONTRACT: LA036  
 IL. LETTING ITEM: 2A  
 IL. PROJECT: IGQ-3565  
 A.I.P. PROJECT: 3-17-0121-825

SURVEY BOOK # BOOK #

REVISIONS		
NUMBER	BY	DATE

0 1 2  
 THIS BAR IS EQUAL TO 2"  
 AT FULL SCALE (34X22).

VILLAGE OF LANSING  
 LANSING MUNICIPAL AIRPORT  
 LANSING, ILLINOIS

**REHABILITATE AIRFIELD LIGHTING SYSTEM  
 AIRFIELD LIGHTING PLAN  
 ELECTRICAL VAULT SITE**

© Copyright: CMT, Inc.  
  
**CMT**  
 CRAWFORD, MURPHY & TILLY, INC.  
 CONSULTING ENGINEERS  
 License No. 184-000633

Lansing Municipal

DESIGN BY:	AB
DRAWN BY:	JWD
CHECKED BY:	DKP
APPROVED BY:	-----
DATE:	02 MARCH 2007
JOB No:	06297-02

**E-04**

SHEET 16 OF 21 SHEETS