


VILLAGE OF STICKNEY | TOWN OF CICERO
 WEST SIDE OF CICERO AVE.

CHICAGO MOTOR SPEEDWAY/
 SPORTSMANS PARK

NOTE:

THE ENVIRONMENTAL FIRM IS REQUIRED TO CONTINUOUSLY MONITOR FOR WORKER PROTECTION AND SOIL CONTAMINATION AT SEVERAL AREAS. SEE SPECIAL PROVISION AND SUPPLEMENTAL SPECIFICATIONS FOR DETAILS.

IL. RTE. 50 (CICERO AVENUE)

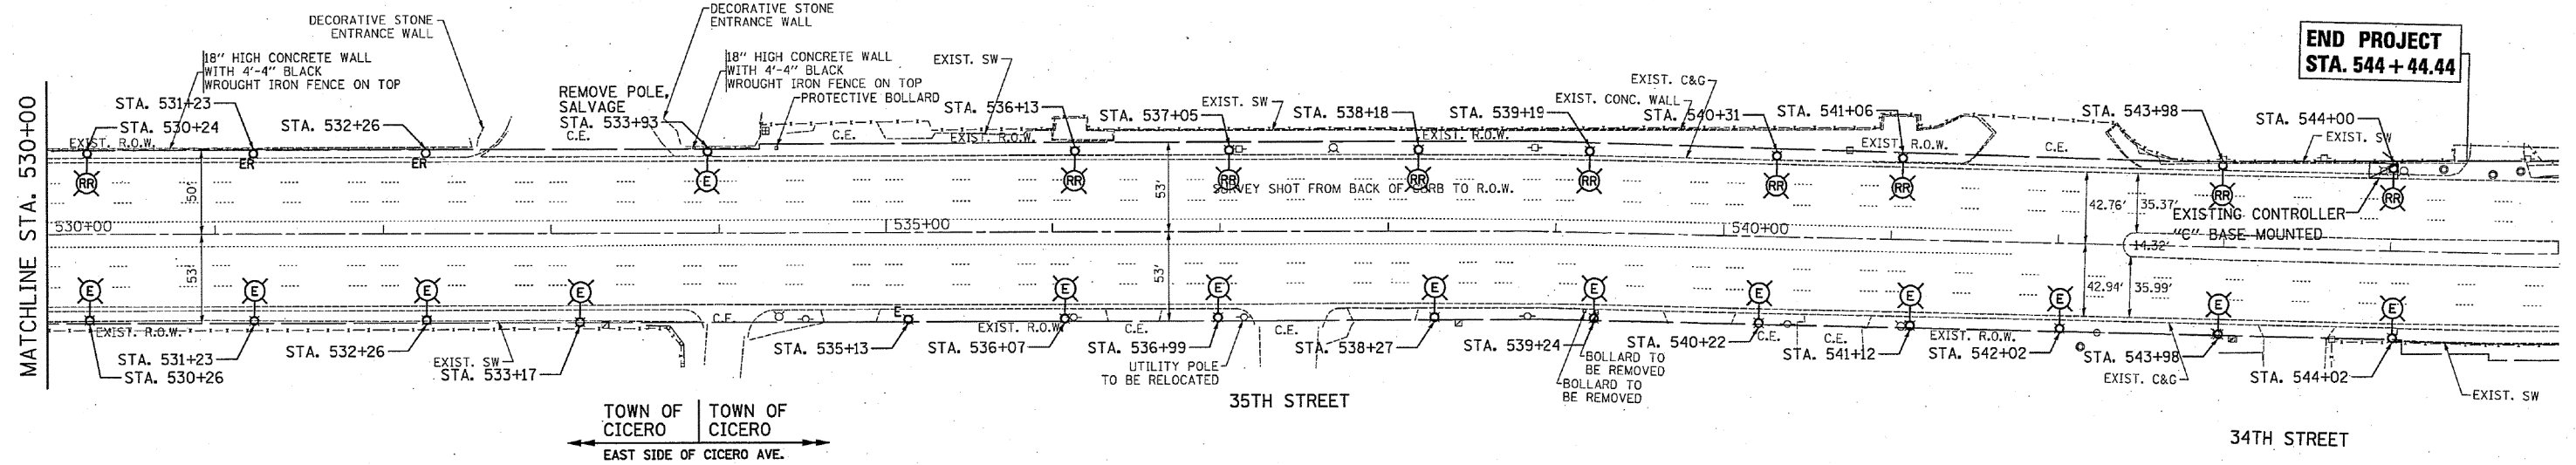

**END PROJECT
 STA. 544 + 44.44**

FILE NAME =	USER NAME = #USER#	DESIGNED - MK	REVISED -
#FILES#		DRAWN - YJ	REVISED -
	PLOT SCALE = #SCALE#	CHECKED - GR	REVISED -
	PLOT DATE = #DATE#	DATE - 10/14/11	REVISED -

**STATE OF ILLINOIS
 DEPARTMENT OF TRANSPORTATION**

**IL RTE. 50 (CICERO AVE.) - (34TH STREET TO PERSHING ROAD)
 EXISTING LIGHTING PLAN**

SCALE: 1" = 50' SHEET NO. OF SHEETS STA. 530+00.00 TO STA. 545+00.00

F.A.P. RTE.	SECTION	COUNTY	TOTAL SHEETS	SHEET NO.
350	2010-050-1	COOK	44	18
CONTRACT NO. 60L26				
ILLINOIS FED. AID PROJECT				