


EXISTING

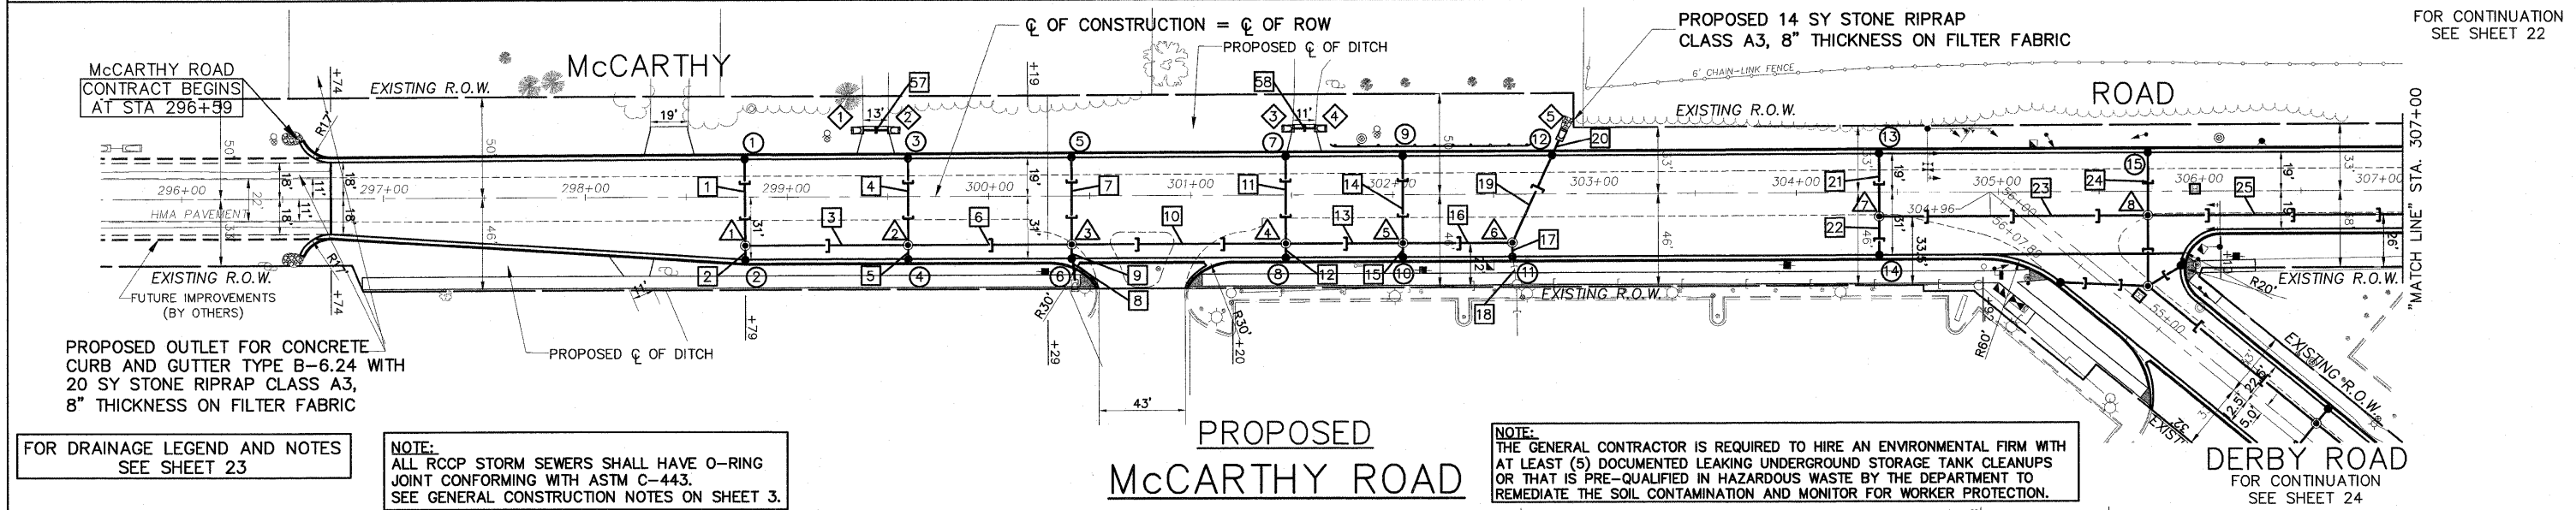


PROPOSED  
McCARTHY ROAD

FOR DRAINAGE LEGEND AND NOTES  
SEE SHEET 23

NOTE:  
ALL RCCP STORM SEWERS SHALL HAVE O-RING  
JOINT CONFORMING WITH ASTM C-443.  
SEE GENERAL CONSTRUCTION NOTES ON SHEET 3.

NOTE:  
THE GENERAL CONTRACTOR IS REQUIRED TO HIRE AN ENVIRONMENTAL FIRM WITH  
AT LEAST (5) DOCUMENTED LEAKING UNDERGROUND STORAGE TANK CLEANUPS  
OR THAT IS PRE-QUALIFIED IN HAZARDOUS WASTE BY THE DEPARTMENT TO  
REMEDiate THE SOIL CONTAMINATION AND MONITOR FOR WORKER PROTECTION.

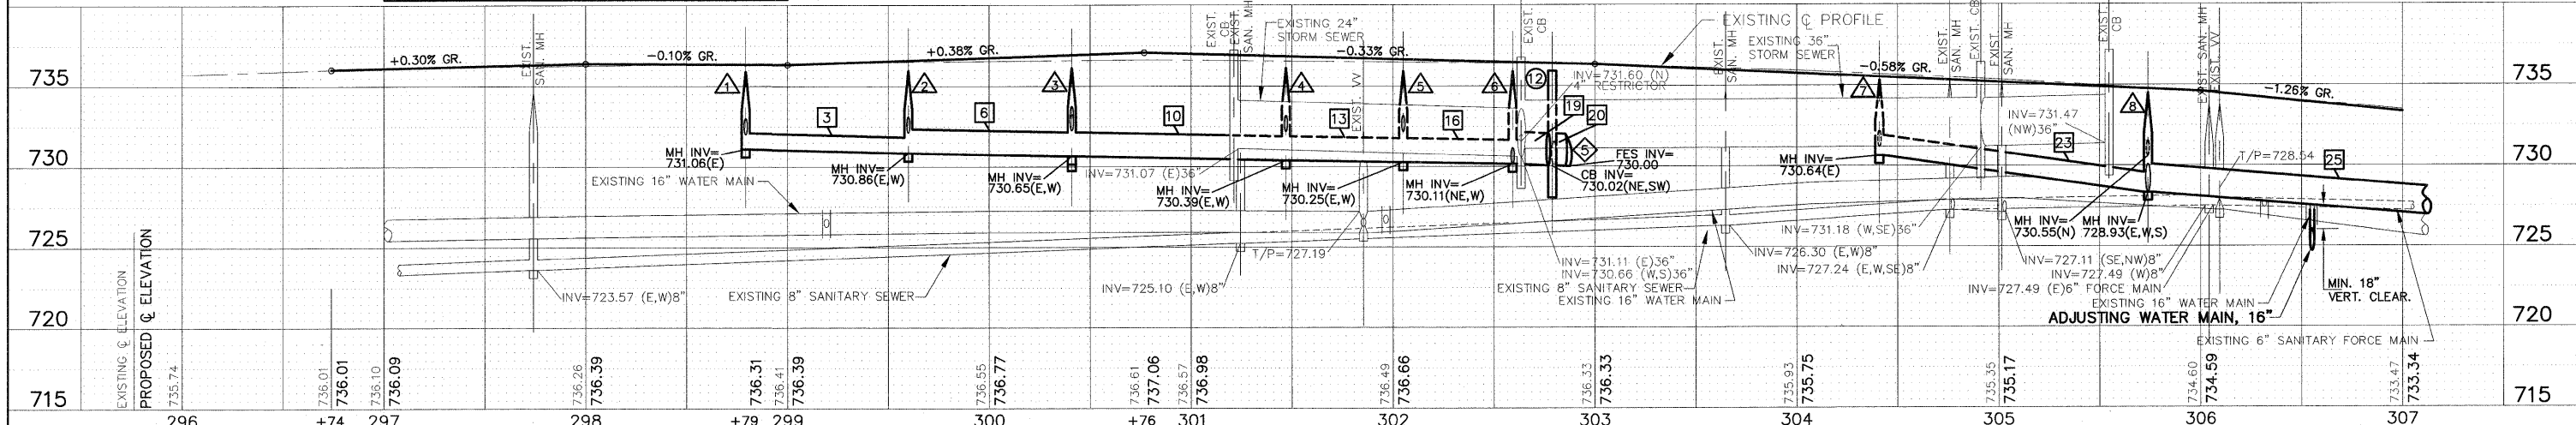

**IMPORTANT!**

FULL SIZE PLANS HAVE BEEN PREPARED USING STANDARD ENGINEERING SCALES.  
REDUCED SIZED PLANS WILL NOT CONFORM TO STANDARD SCALES INDICATED IN TITLE BLOCK.

FOR TYPICAL CROSS SECTION  
OF NEW PAVEMENT WORK  
SEE SHEET 9



**Frank Novotny & Associates, Inc.**  
825 Midway Drive • Willowbrook, IL • 60527 • Telephone: (630) 887-9640 • Fax: (630) 887-0139  
ILLINOIS PROFESSIONAL DESIGN FIRM NO. 184-00028

FILE NAME FAU 1587 (McCARTHY ROAD) FAP 577 (ARCHER AVENUE) FAU 1024 (DERBY ROAD) CHANNELIZATION AND TRAFFIC SIGNAL INSTALLATION	USER NAME =	DESIGNED - JLC	REVISED - THK 3-17-11
	PLOT SCALE =	DRAWN - JFP-JEP	REVISED - THK 9-21-11
	PLOT DATE =	CHECKED - THK	REVISED - THK 10-31-11
		DATE - 11/10	REVISED -

STATE OF ILLINOIS  
DEPARTMENT OF TRANSPORTATION

PLAN & PROFILE:  
McCARTHY ROAD- (EXISTING AND PROPOSED ROADWAY DRAINAGE PLAN)

SCALE: AS NOTED SHEET NO. OF SHEETS STA. 296+74 TO STA. 307+00

F.A. RTE. VAR	SECTION 02-00055-00-WR	COUNTY COOK	TOTAL SHEETS 84	SHEET NO. 21
CONTRACT NO. 63557			FED. ROAD DIST. NO. ILLINOIS FED. AID PROJECT HPP-M-8003(504)	