


ROUTE NO.	SIC	COUNTY	TOTAL SHEETS	SHEET NO.
EA. 14	12-2	JACKSON	204	83

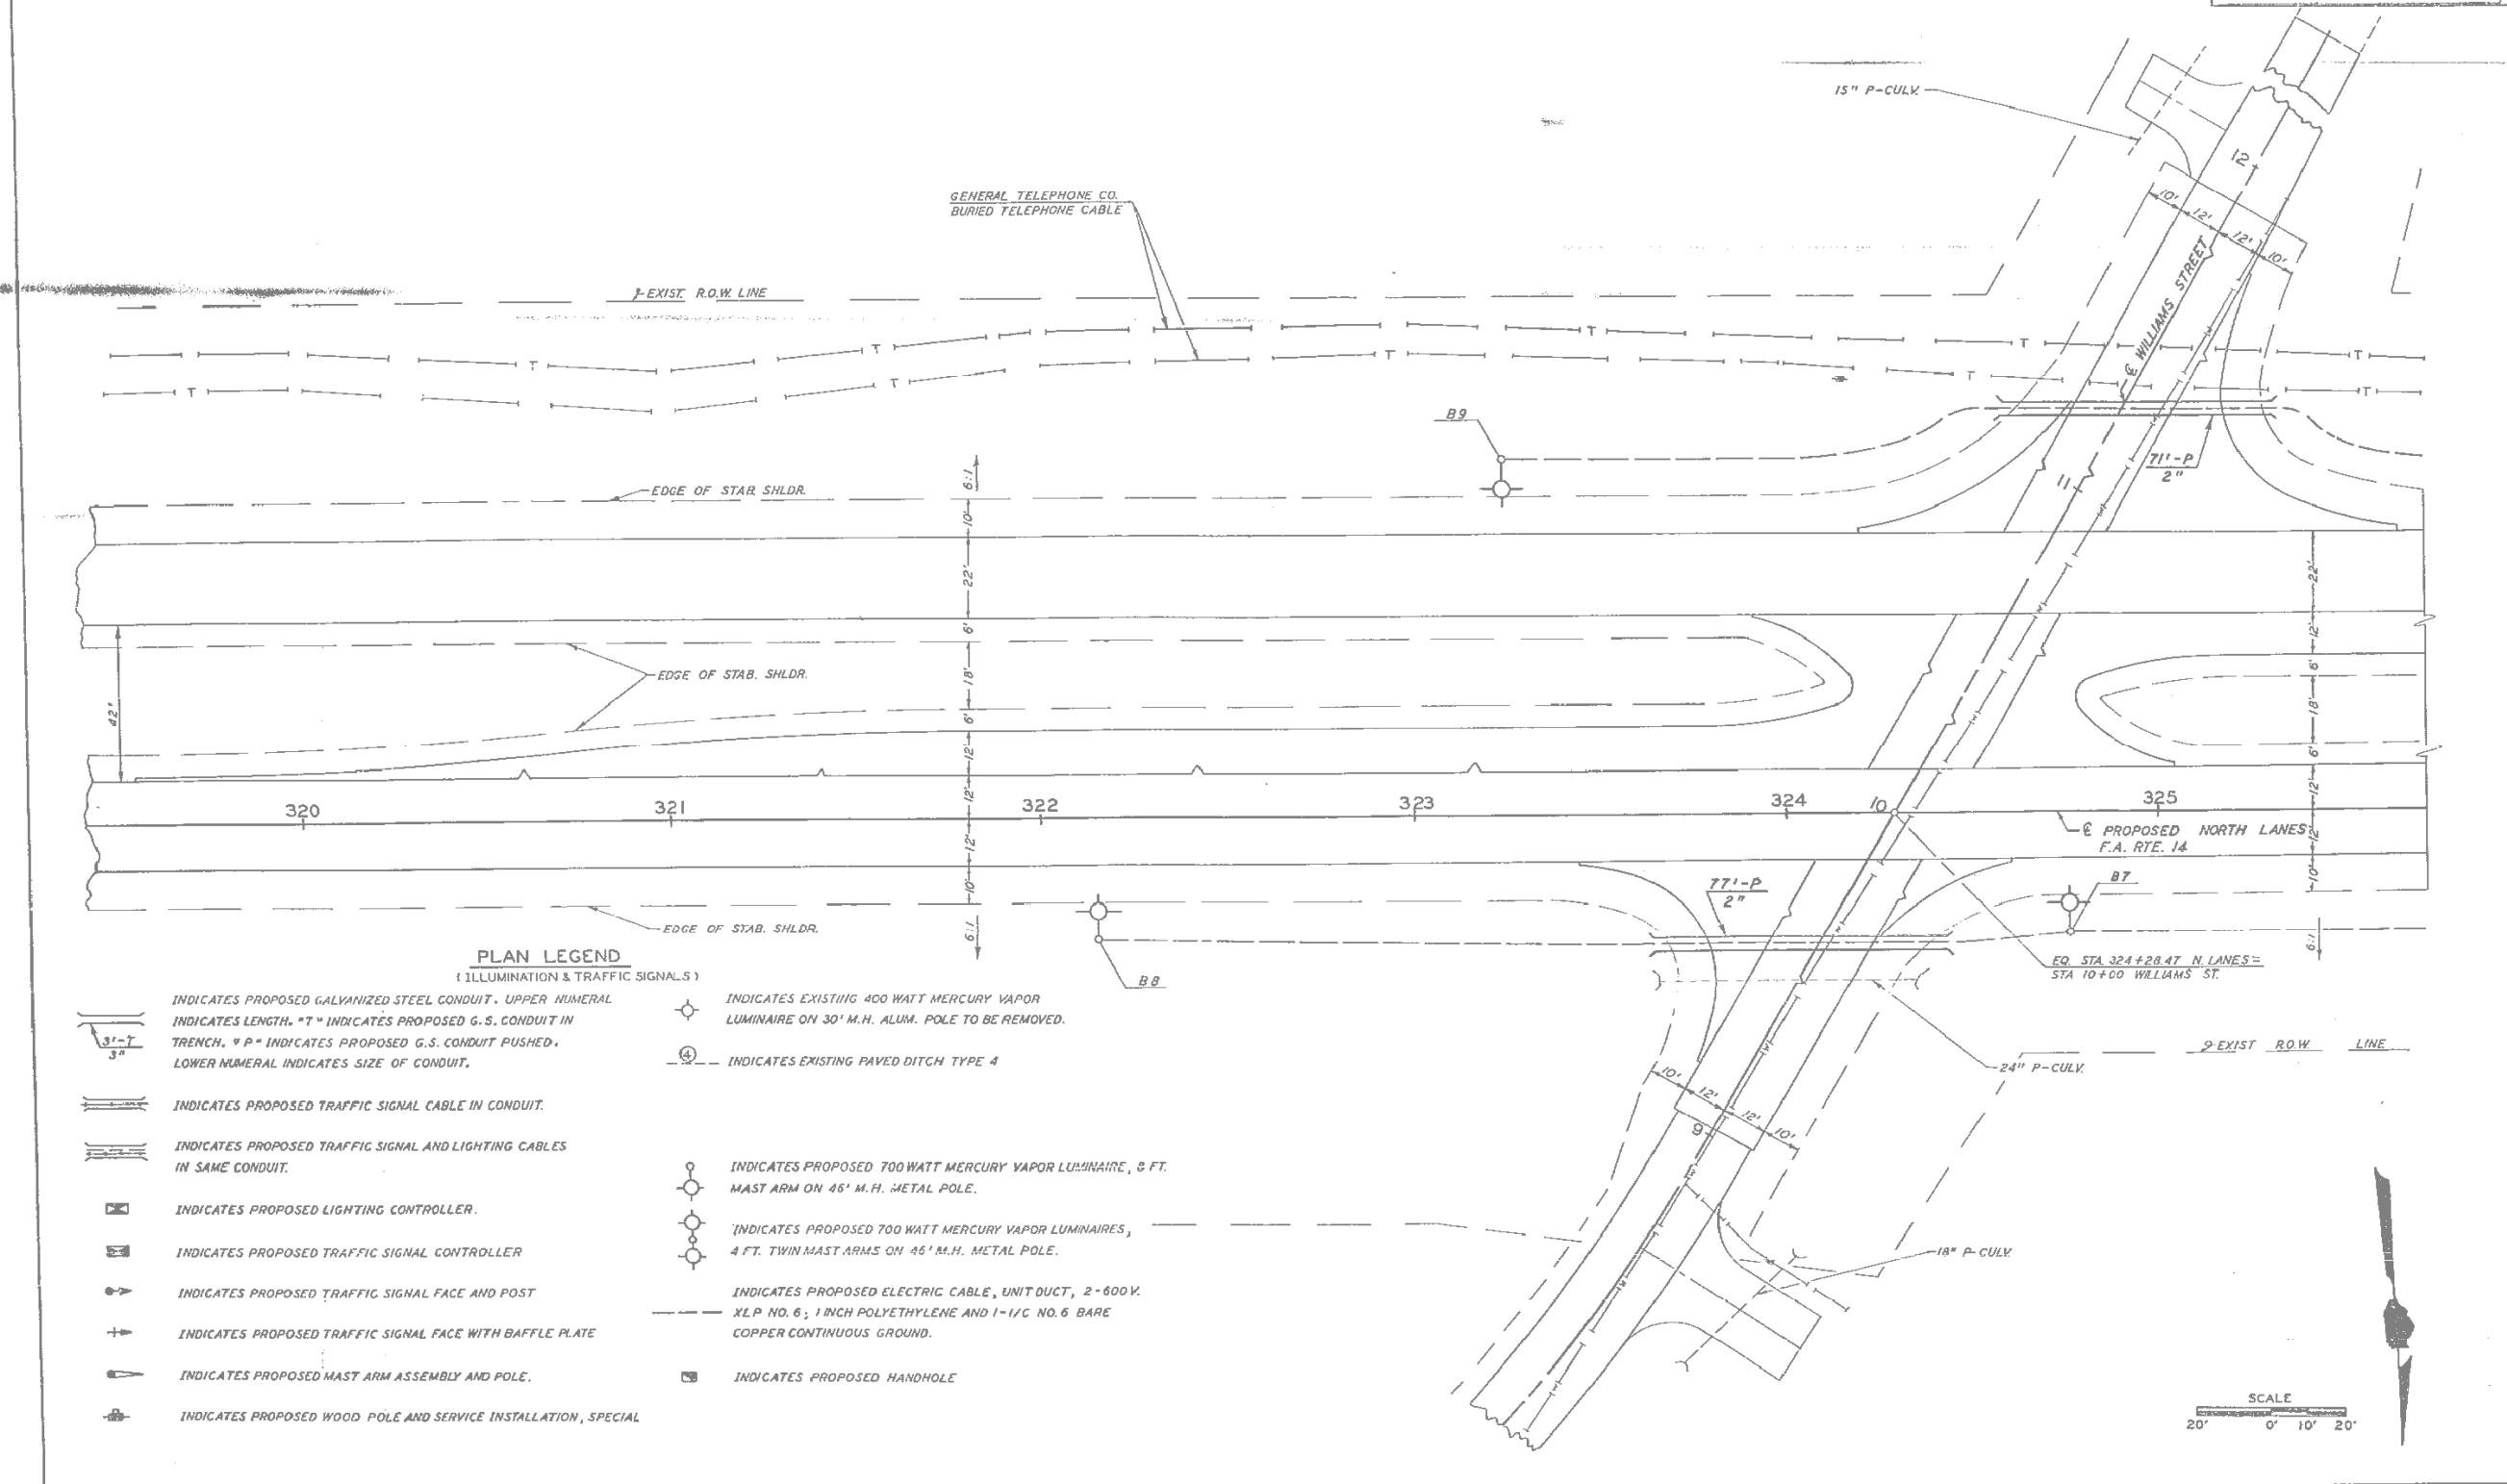

**PLAN LEGEND**  
(ILLUMINATION & TRAFFIC SIGNALS)

- INDICATES PROPOSED GALVANIZED STEEL CONDUIT. UPPER NUMERAL INDICATES LENGTH. \*T\* INDICATES PROPOSED G.S. CONDUIT IN TRENCH. \*P\* INDICATES PROPOSED G.S. CONDUIT PUSHED. LOWER NUMERAL INDICATES SIZE OF CONDUIT.
- INDICATES PROPOSED TRAFFIC SIGNAL CABLE IN CONDUIT.
- INDICATES PROPOSED TRAFFIC SIGNAL AND LIGHTING CABLES IN SAME CONDUIT.
- INDICATES PROPOSED LIGHTING CONTROLLER.
- INDICATES PROPOSED TRAFFIC SIGNAL CONTROLLER.
- INDICATES PROPOSED TRAFFIC SIGNAL FACE AND POST.
- INDICATES PROPOSED TRAFFIC SIGNAL FACE WITH BAFFLE PLATE.
- INDICATES PROPOSED MAST ARM ASSEMBLY AND POLE.
- INDICATES PROPOSED WOOD POLE AND SERVICE INSTALLATION, SPECIAL.
- INDICATES EXISTING 400 WATT MERCURY VAPOR LUMINAIRE ON 30' M.H. ALUM. POLE TO BE REMOVED.
- INDICATES EXISTING PAVED DITCH TYPE 4.
- INDICATES PROPOSED 700 WATT MERCURY VAPOR LUMINAIRE, 8 FT. MAST ARM ON 46' M.H. METAL POLE.
- INDICATES PROPOSED 700 WATT MERCURY VAPOR LUMINAIRES, 4 FT. TWIN MAST ARMS ON 46' M.H. METAL POLE.
- INDICATES PROPOSED ELECTRIC CABLE, UNIT DUCT, 2-600V. XLP NO. 6; 1 INCH POLYETHYLENE AND 1-1/2 NO. 6 BARE COPPER CONTINUOUS GROUND.
- INDICATES PROPOSED HANDHOLE.



F.A. RTE. 14 SECTION 12-2 JACKSON COUNTY (ILLUMINATION) STA. 320+00 TO 325+73

FILE NAME = D978056-shr-ex-light.dgn

USER NAME = default  
PLOT SCALE = 40.0000' / IN.  
PLOT DATE = 1/25/2012

DESIGNED -  
DRAWN -  
CHECKED -  
DATE -

REVISED -  
REVISED -  
REVISED -  
REVISED -

**STATE OF ILLINOIS  
DEPARTMENT OF TRANSPORTATION**

**EXISTING LIGHTING PLANS  
(FOR INFORMATION ONLY)**  
SCALE: SHEET NO. 2 OF 9 SHEETS STA. TO STA.

F.A.P. RTE.	SECTION	COUNTY	TOTAL SHEETS	SHEET NO.
331	(12-1) B-1	JACKSON	200	52
CONTRACT NO. 78056				
ILLINOIS FED. AID PROJECT				