
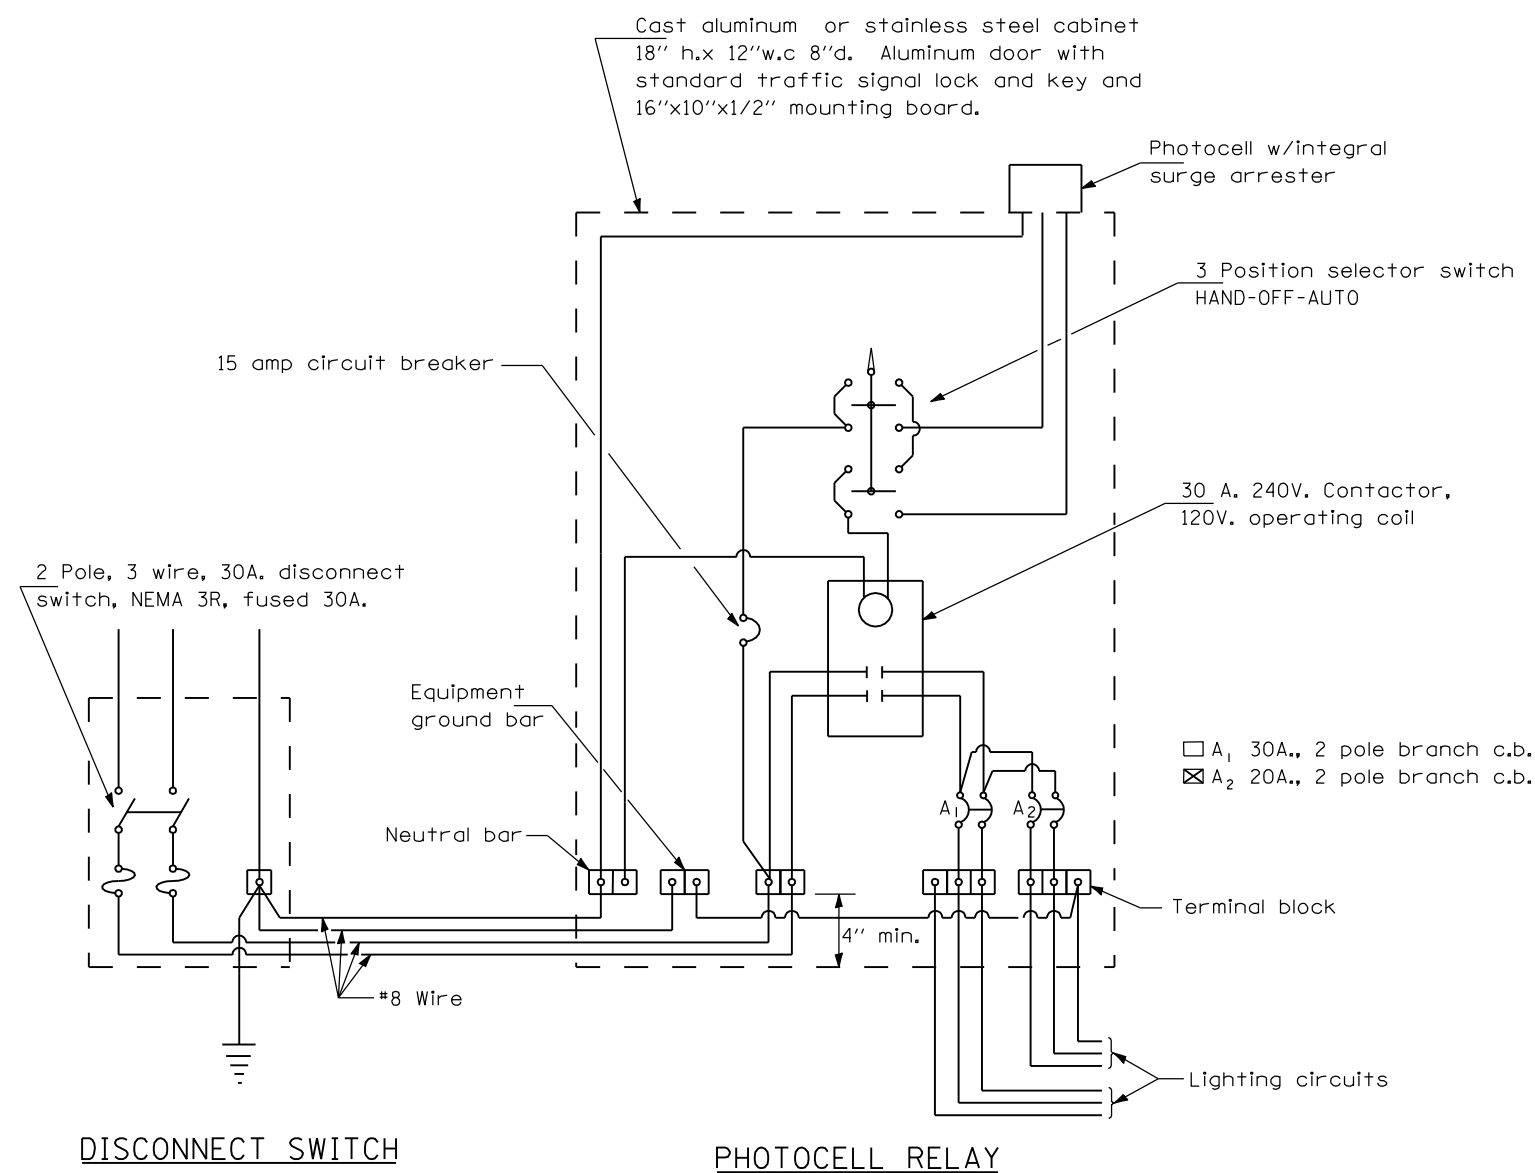


F.A.P. RTE.	SECTION	COUNTY	TOTAL SHEETS	SHEET NO.
315	34-4	HANCOCK	452	151
STA.		TO STA.		
FED. ROAD DIST. NO.		ILLINOIS FED. AID PROJECT		
D-98-551-02				

CONTRACT NO. 72680

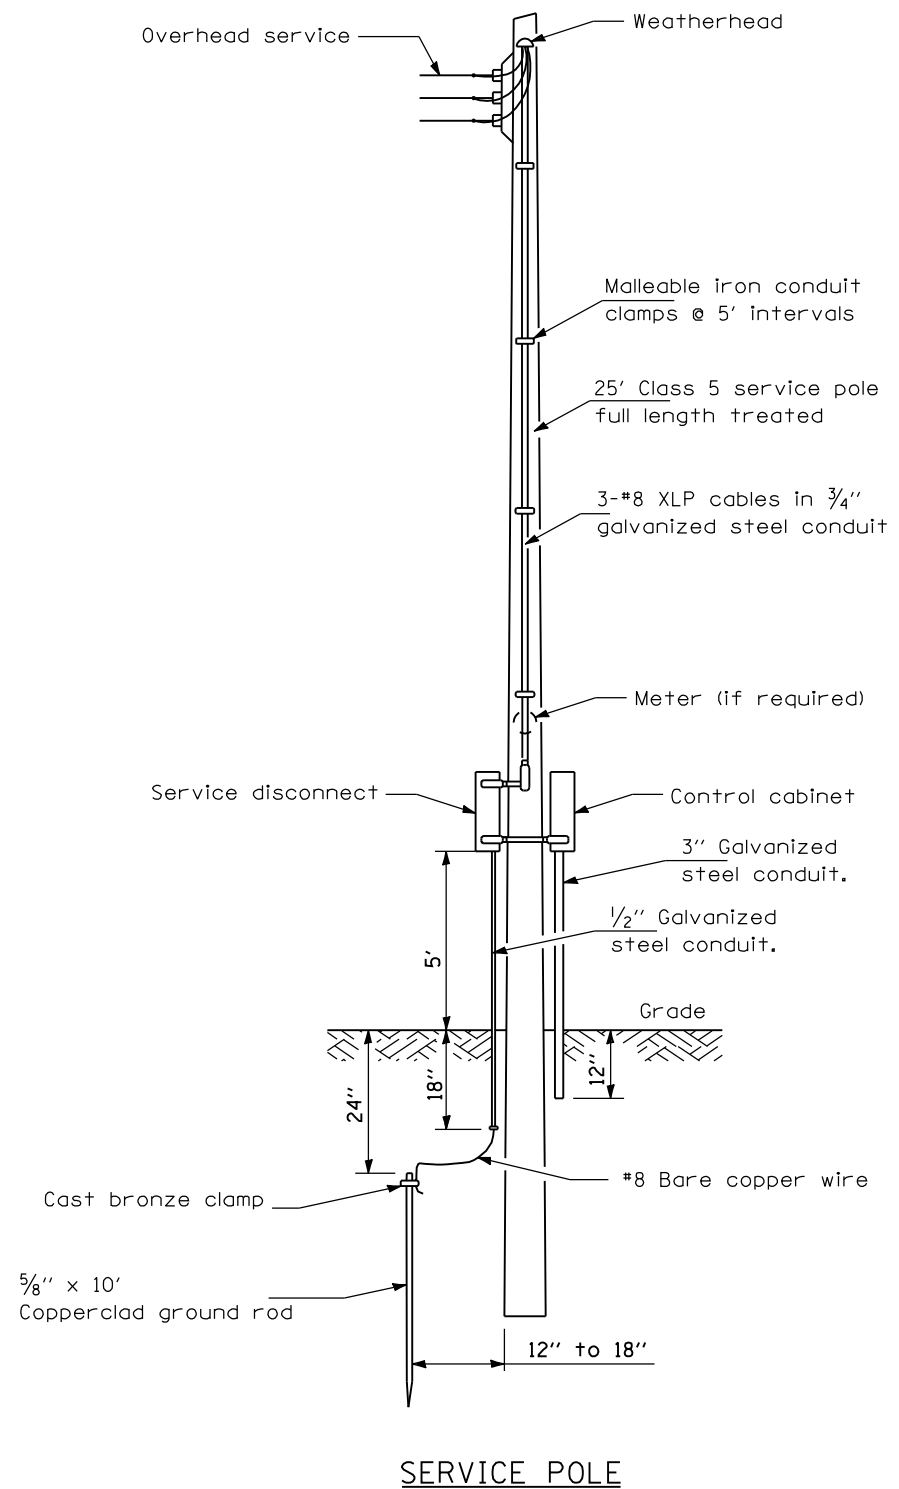

GENERAL NOTES

All equipment shall be U.L. Listed.
 All dimensions are in inches unless otherwise shown.

CONTROL INSTALLATION SERVICE POLE MOUNTED

120/240V., 1 PHASE, 3 WIRE SERVICE

REVISIONS		ILLINOIS DEPARTMENT OF TRANSPORTATION
NAME	DATE	
		FAP 315 (US 136) LIGHTING PLANS LIGHTING DETAILS
SCALE:	NONE	DRAWN BY: IDOT
DATE:		CHECKED BY:

3/18/2005

21734de104