


F.A.P. RTE.	SECTION	COUNTY	TOTAL SHEETS	SHEET NO.
315	34-4	HANCOCK	452	155

 
STA. TO STA.
 FED. ROAD DIST. NO. ILLINOIS FED. AID PROJECT
 D-98-551-02

CONTRACT NO. 72680

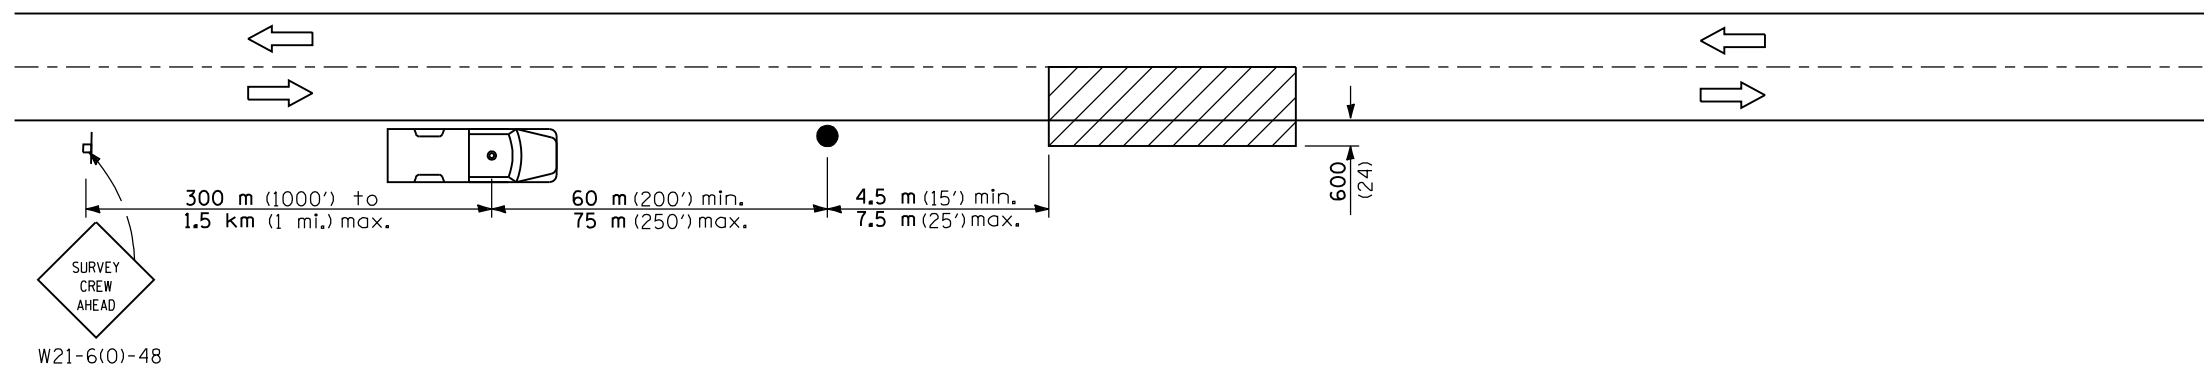

FLAGGER SHALL BE EQUIPPED WITH AND REQUIRED TO USE A HIGH INTENSITY, OR HIGH PERFORMANCE " **STOP - SLOW** " TRAFFIC CONTROL PADDLE. FLAGGER AND LIGHTING INSPECTOR SHALL BE REQUIRED TO WEAR A HIGH VISIBILITY, REFLECTIVE ORANGE VEST AND EITHER A HARD HAT OR AN ORANGE CAP.


SYMBOLS



Work area



 Sign on portable or permanent support



Truck with flashing amber light and dual emergency flashers



Flagger with traffic control sign

TYPICAL APPLICATIONS
 Utility operations

DETAIL FOR NIGHTTIME LIGHTING INSPECTION

REVISIONS	
NAME	DATE

ILLINOIS DEPARTMENT OF TRANSPORTATION

FAP 315 (US 136)
 LIGHTING PLANS
 LIGHTING DETAILS

SCALE: NONE DRAWN BY IDOT
 DATE CHECKED BY