


E.A.V. ROUTE	SECTION	COUNTY	TOTAL SHEETS	SHEET NO.
0306	*	WILL	118	48
FHWA REGION NO.		ILLINOIS	PROJECT M-8003(200)	
* 01-00029-00-FP		CONTRACT NO. 83825		

- A SANITARY MANHOLES TO BE ADJUSTED
- B VALVE VAULTS TO BE ADJUSTED
- C INLETS TO BE ADJUSTED
- D CATCH BASINS TO BE ADJUSTED
- E FIRE HYDRANTS TO BE RELOCATED
- F REMOVING CATCH BASINS
- G VALVE BOXES TO BE ADJUSTED
- H REMOVING MANHOLES

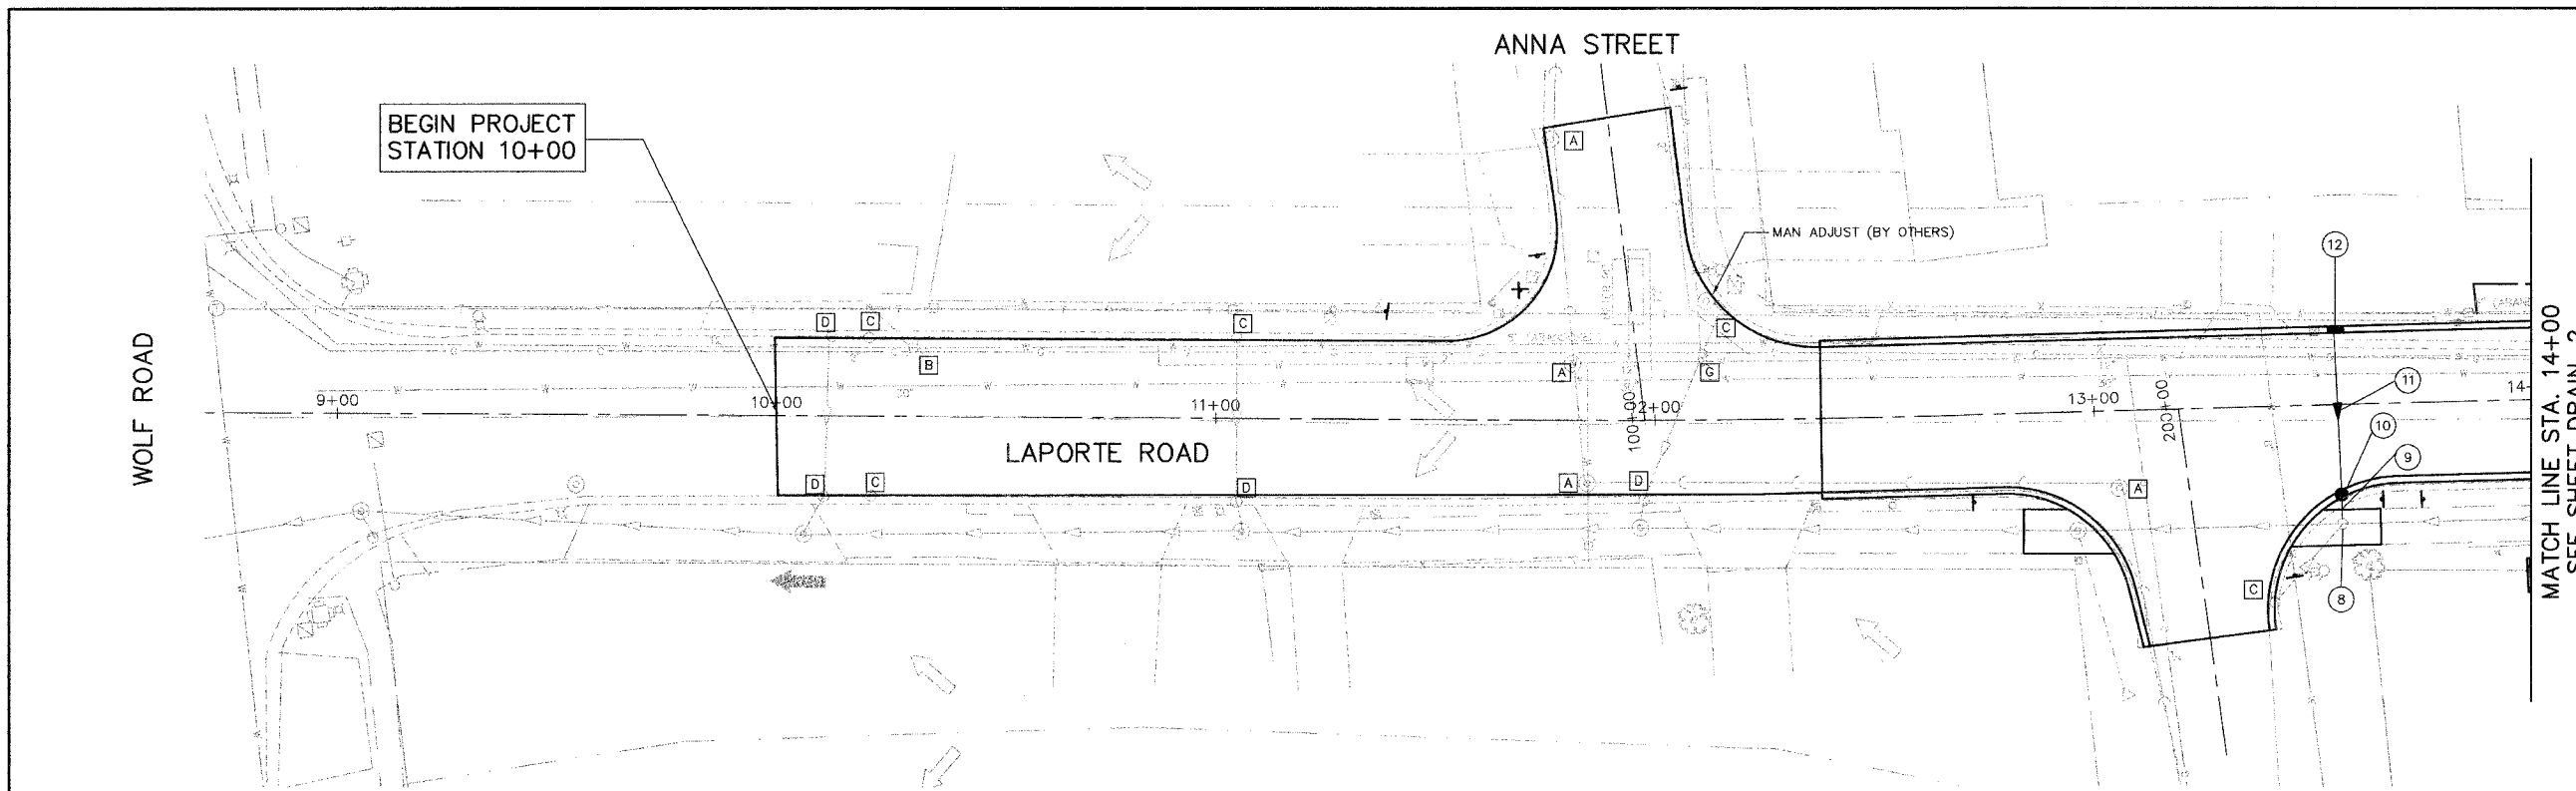


- 1 NOT USED
- 2 NOT USED
- 3 NOT USED
- 4 NOT USED
- 5 NOT USED
- 6 NOT USED
- 7 NOT USED
- 8 STA. 13+56, 27 FT RT. EXISTING MANHOLE  
T/F=711.83  
INV.=706.58 (S)(E)(W)  
INV.=709.00 (N)
- 9 STORM SEWER, RG. CLASS A, TYPE 1  
5' -12" @ 1.0%  
TBF=1.9 CY
- 10 STA. 13+55, 19.5 FT RT. CATCH BASIN T-A, 4' DIA., T-4 F&G  
T/F=712.79  
INV.=709.42 (N)  
INV.=709.05 (S)
- 11 STORM SEWER, RG. CLASS A, TYPE 1  
38' -12" @ 1.0%  
TBF=10.5 CY
- 12 STA. 13+55, 16.5 FT LT. INLET, T-A, T-4 F&G  
T/F=712.80  
INV.=709.80

SCOTT STREET

MATCH LINE STA. 14+00  
SEE SHEET DRAIN-2

DRAIN-1

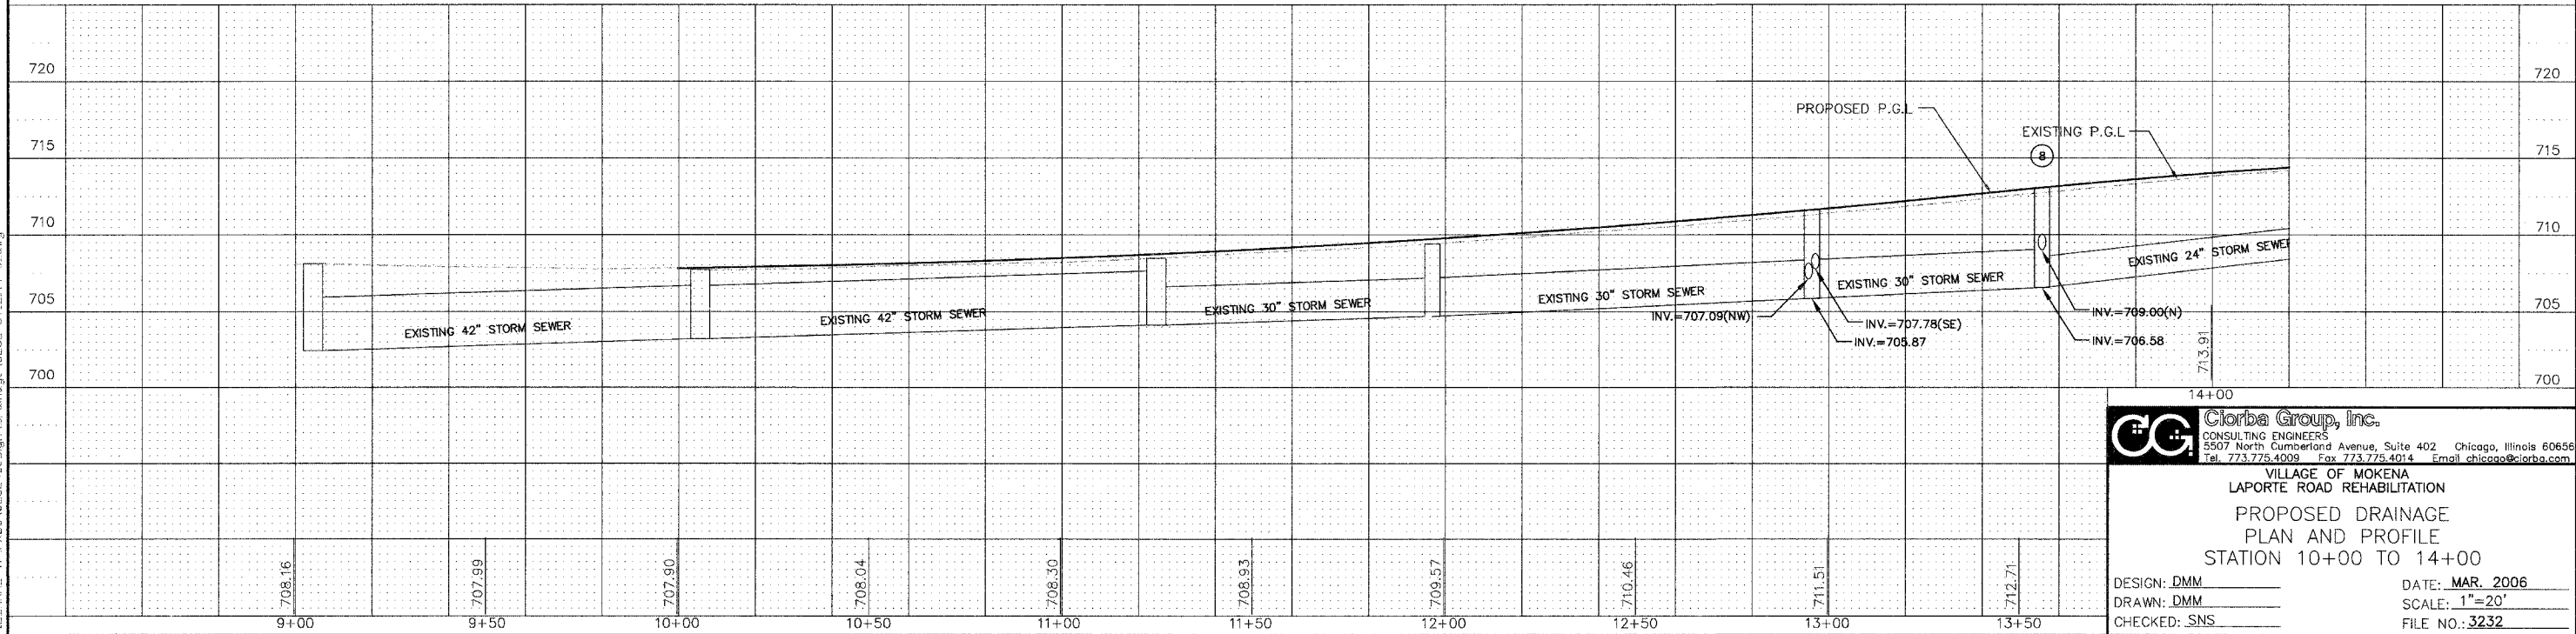

**Clorba Group, Inc.**  
CONSULTING ENGINEERS  
5507 North Cumberland Avenue, Suite 402 Chicago, Illinois 60656  
Tel. 773.775.4009 Fax 773.775.4014 Email chicago@clorba.com

VILLAGE OF MOKENA  
LAPORTE ROAD REHABILITATION  
PROPOSED DRAINAGE  
PLAN AND PROFILE  
STATION 10+00 TO 14+00

DESIGN: DMM  
DRAWN: DMM  
CHECKED: SNS

DATE: MAR. 2006  
SCALE: 1"=20'  
FILE NO.: 3232

PLOT DATE: Mar 15, 2006 - 2:16pm  
FILE NAME: I:\PROJECTS\22323\Design\Drainage\32323-UTILITY-01.dwg