 


**AU062**


PATH: K:\042850400\DRAW\SHEETS  
 FILE: pp-malsr-33.DWG  
 UPDATE BY: .  
 SURVEY BOOK #  
 XREF DWG:  
 XREF DWG:  
 DATE: .

REVISIONS		
NUMBER	BY	DATE



**AURORA MUNICIPAL AIRPORT  
 AURORA, ILLINOIS  
 CONSTRUCT RUNWAY 33 ILS,  
 RELOCATE RUNWAY 9 LOCALIZER**

**RUNWAY 33 MALSRR PLAN AND PROFILE  
 MALSRR STATIONS 0+05 - 11+00  
 ARR-D-MALSRR33-C01**

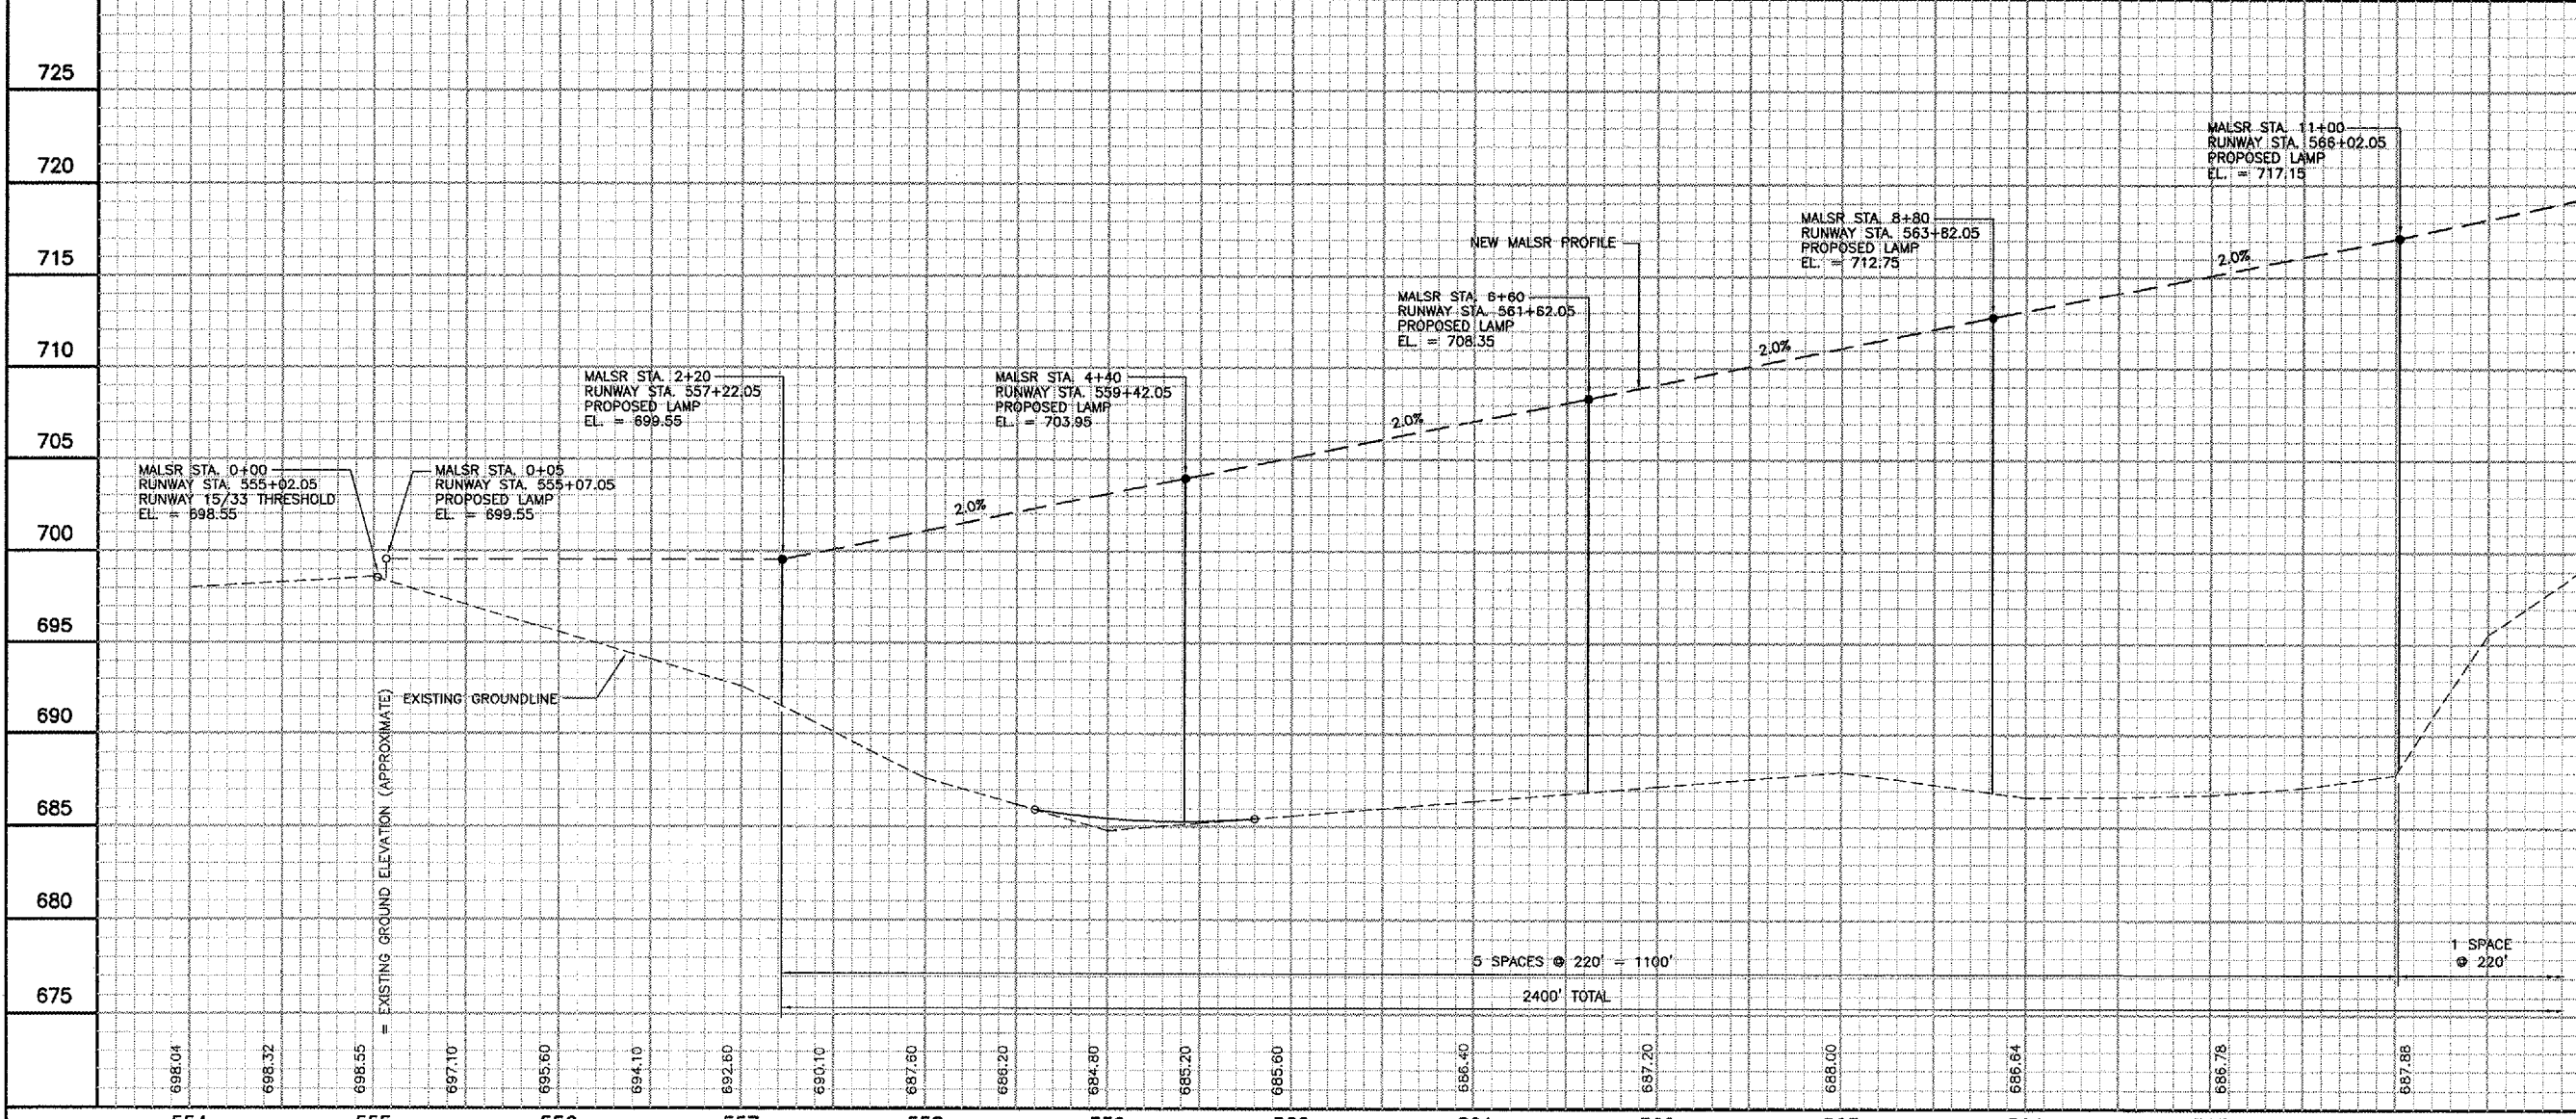

**CMT**  
 CRAWFORD, MURPHY & TILLY, INC.  
 CONSULTING ENGINEERS  
 License No. 184-000613

DESIGN BY:	CAL
DRAWN BY:	JRO
CHECKED BY:	CAL
APPROVED BY:	
DATE:	03/03/06
JOB No:	04285-04
ILLINOIS PROJECT:	ARR-3468
A.I.P. PROJECT:	3-17-0003-B31
<b>FINAL SUBMITTAL.</b>	