


F.A.I. RTE.	SECTION	COUNTY	TOTAL SHEETS	SHEET NO.
90/94	2003-0311	COOK	976	73
STA.	90+00	TO STA.	103+00	
FED. ROAD DIST. NO.	ILLINOIS	FED. AID PROJECT		

62583



**NOTES:**

1. SEE DRAWINGS ME-01 AND ME-02 FOR ELECTRICAL SYMBOLS AND ABBREVIATIONS.
2. UNLESS NOTED OTHERWISE, ALL ITEMS AND WORK SHOWN IN HEAVY LINE WEIGHT ON THIS DRAWING ARE PROPOSED NEW ITEMS OF WORK.
3. THE EXISTING ROADWAY LIGHTING SYSTEM SHALL REMAIN IN OPERATION UNTIL THE PROPOSED ROADWAY LIGHTING SYSTEM HAS BEEN INSTALLED, ENERGIZED, TESTED, AND ACCEPTED BY THE ENGINEER, UNLESS OTHERWISE DIRECTED BY THE ENGINEER.
4. REMOVAL OF LIGHT POLE AND LUMINAIRE ARE PART OF CONTRACT 62583. FOUNDATION REMOVAL SHALL BE PART OF CONTRACT 62694 AND 62695. COORDINATE REMOVAL SCHEDULE WITH CIVIL CONTRACTS 62694 AND 62695 OR AS OTHERWISE DIRECTED BY THE ENGINEER.
5. TEMPORARY RAMP LIGHTING NOT REQUIRED DUE TO RAMP CLOSING.
6. REFER SHEET ME-16 FOR TEMPORARY AERIAL CABLE CONNECTION.
7. PROVIDE TEMPORARY LIGHTING UNIT INCLUDING 60 FOOT WOOD POLE, 8' MAST ARM, 400 WATT HPS LUMINAIRE. PAY ITEM FOR WOOD POLE, MAST ARM, AND LUMINAIRE SHALL BE "WOOD LIGHTING POLE, 60 FOOT, CLASS 4".
8. REMOVAL INDICATED ON THIS SHEET, SHALL BE FOR RAMP AND SIGNS. MAINLINE REMOVALS SHALL BE NOTED ON PROPOSED IMPROVEMENT PLANS.

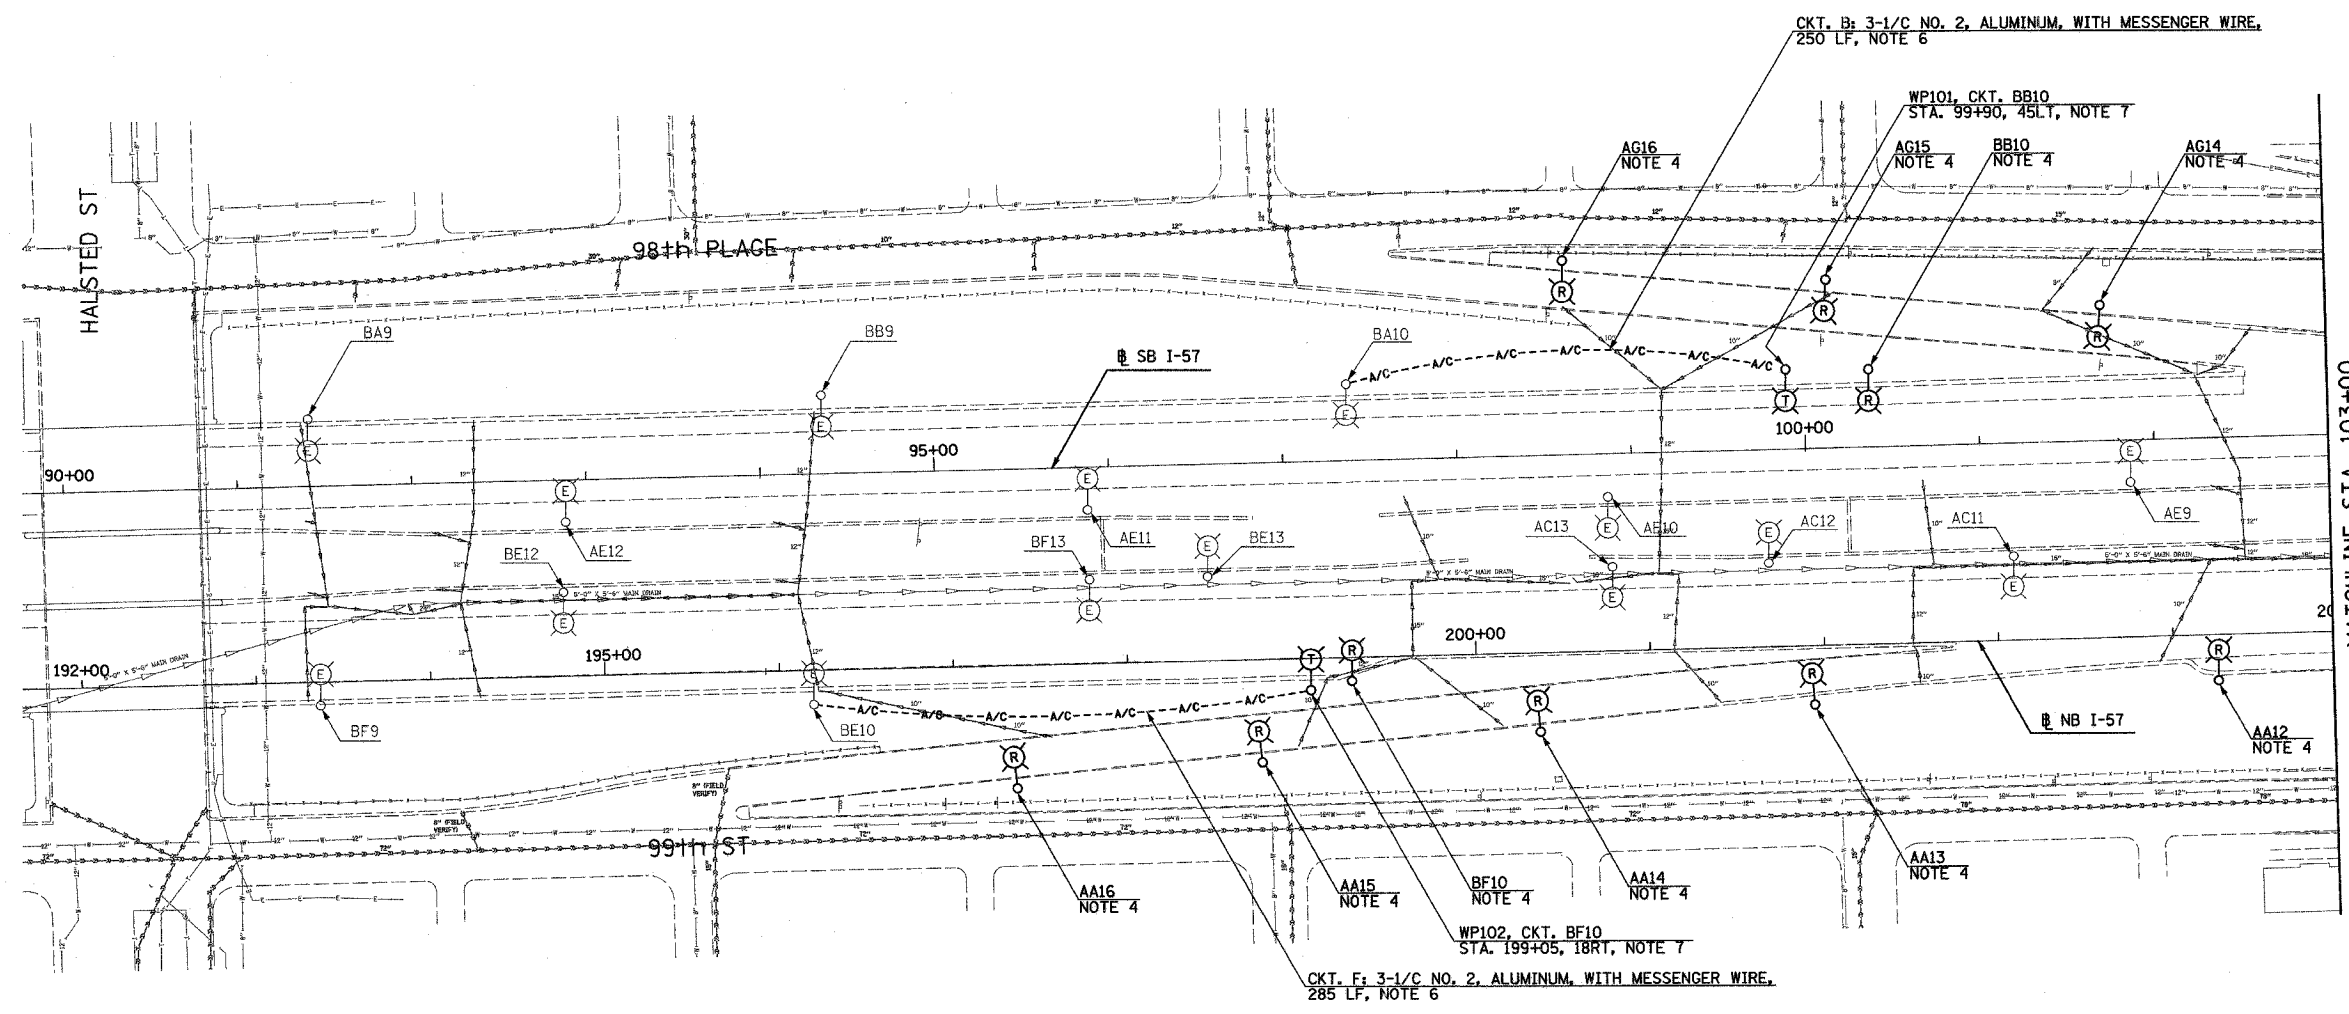

EL-01

REVISIONS		ILLINOIS DEPARTMENT OF TRANSPORTATION F.A.I. 90/94 (DAN RYAN EXPRESSWAY) 31st STREET TO I-57  ROADWAY LIGHTING PLANS EXISTING CONDITIONS, TEMPORARY AND REMOVAL
NAME	DATE	

SCALE: 1"=50'      DRAWN BY: SP  
DATE: OCTOBER 29, 2004      CHECKED BY: TM

**SINGH** 300 W. ADAMS ST.  
CHICAGO, IL 60608  
SINGH & ASSOCIATES, INC. TEL: (312) 629-0240  
CONSULTING ENGINEERS FAX: (312) 629-8449

0/20/2004 5:13:35 PM