


F.A.I. SECTION	COUNTY	TOTAL SHEETS	SHEET NO.
90/94 2003-0311	COOK	976	75
STA. 116+00 TO STA. 129+00			
FED. ROAD DIST. NO.	ILLINOIS FED. AID PROJECT	62583	

- NOTES:
- SEE DRAWINGS ME-01 AND ME-02 FOR ELECTRICAL SYMBOLS AND ABBREVIATIONS.
 - UNLESS NOTED OTHERWISE, ALL ITEMS AND WORK SHOWN IN HEAVY LINE WEIGHT ON THIS DRAWING ARE PROPOSED NEW ITEMS OF WORK.
 - THE EXISTING ROADWAY LIGHTING SYSTEM SHALL REMAIN IN OPERATION UNTIL THE PROPOSED ROADWAY LIGHTING SYSTEM HAS BEEN INSTALLED, ENERGIZED, TESTED, AND ACCEPTED BY THE ENGINEER, UNLESS OTHERWISE DIRECTED BY THE ENGINEER.
 - PROVIDE AERIAL CABLE BETWEEN EXISTING LIGHT POLES TO PERMIT REMOVAL OF SIGN UNDER SEPARATE CONTRACT. REFER TO SHEET ME-16.
 - SIGN SHALL BE DISCONNECTED BACK TO NEXT SPLICE. SIGN STRUCTURE AND LUMINAIRES SHALL BE REMOVED UNDER SEPARATE CONTRACT. COORDINATE WITH CONTRACTS 62694 AND 62695. NOTE: PROPOSED SIGN A3 SHALL BE INSTALLED AND OPERATIONAL BEFORE EXISTING SIGN A4 IS DISCONNECTED.

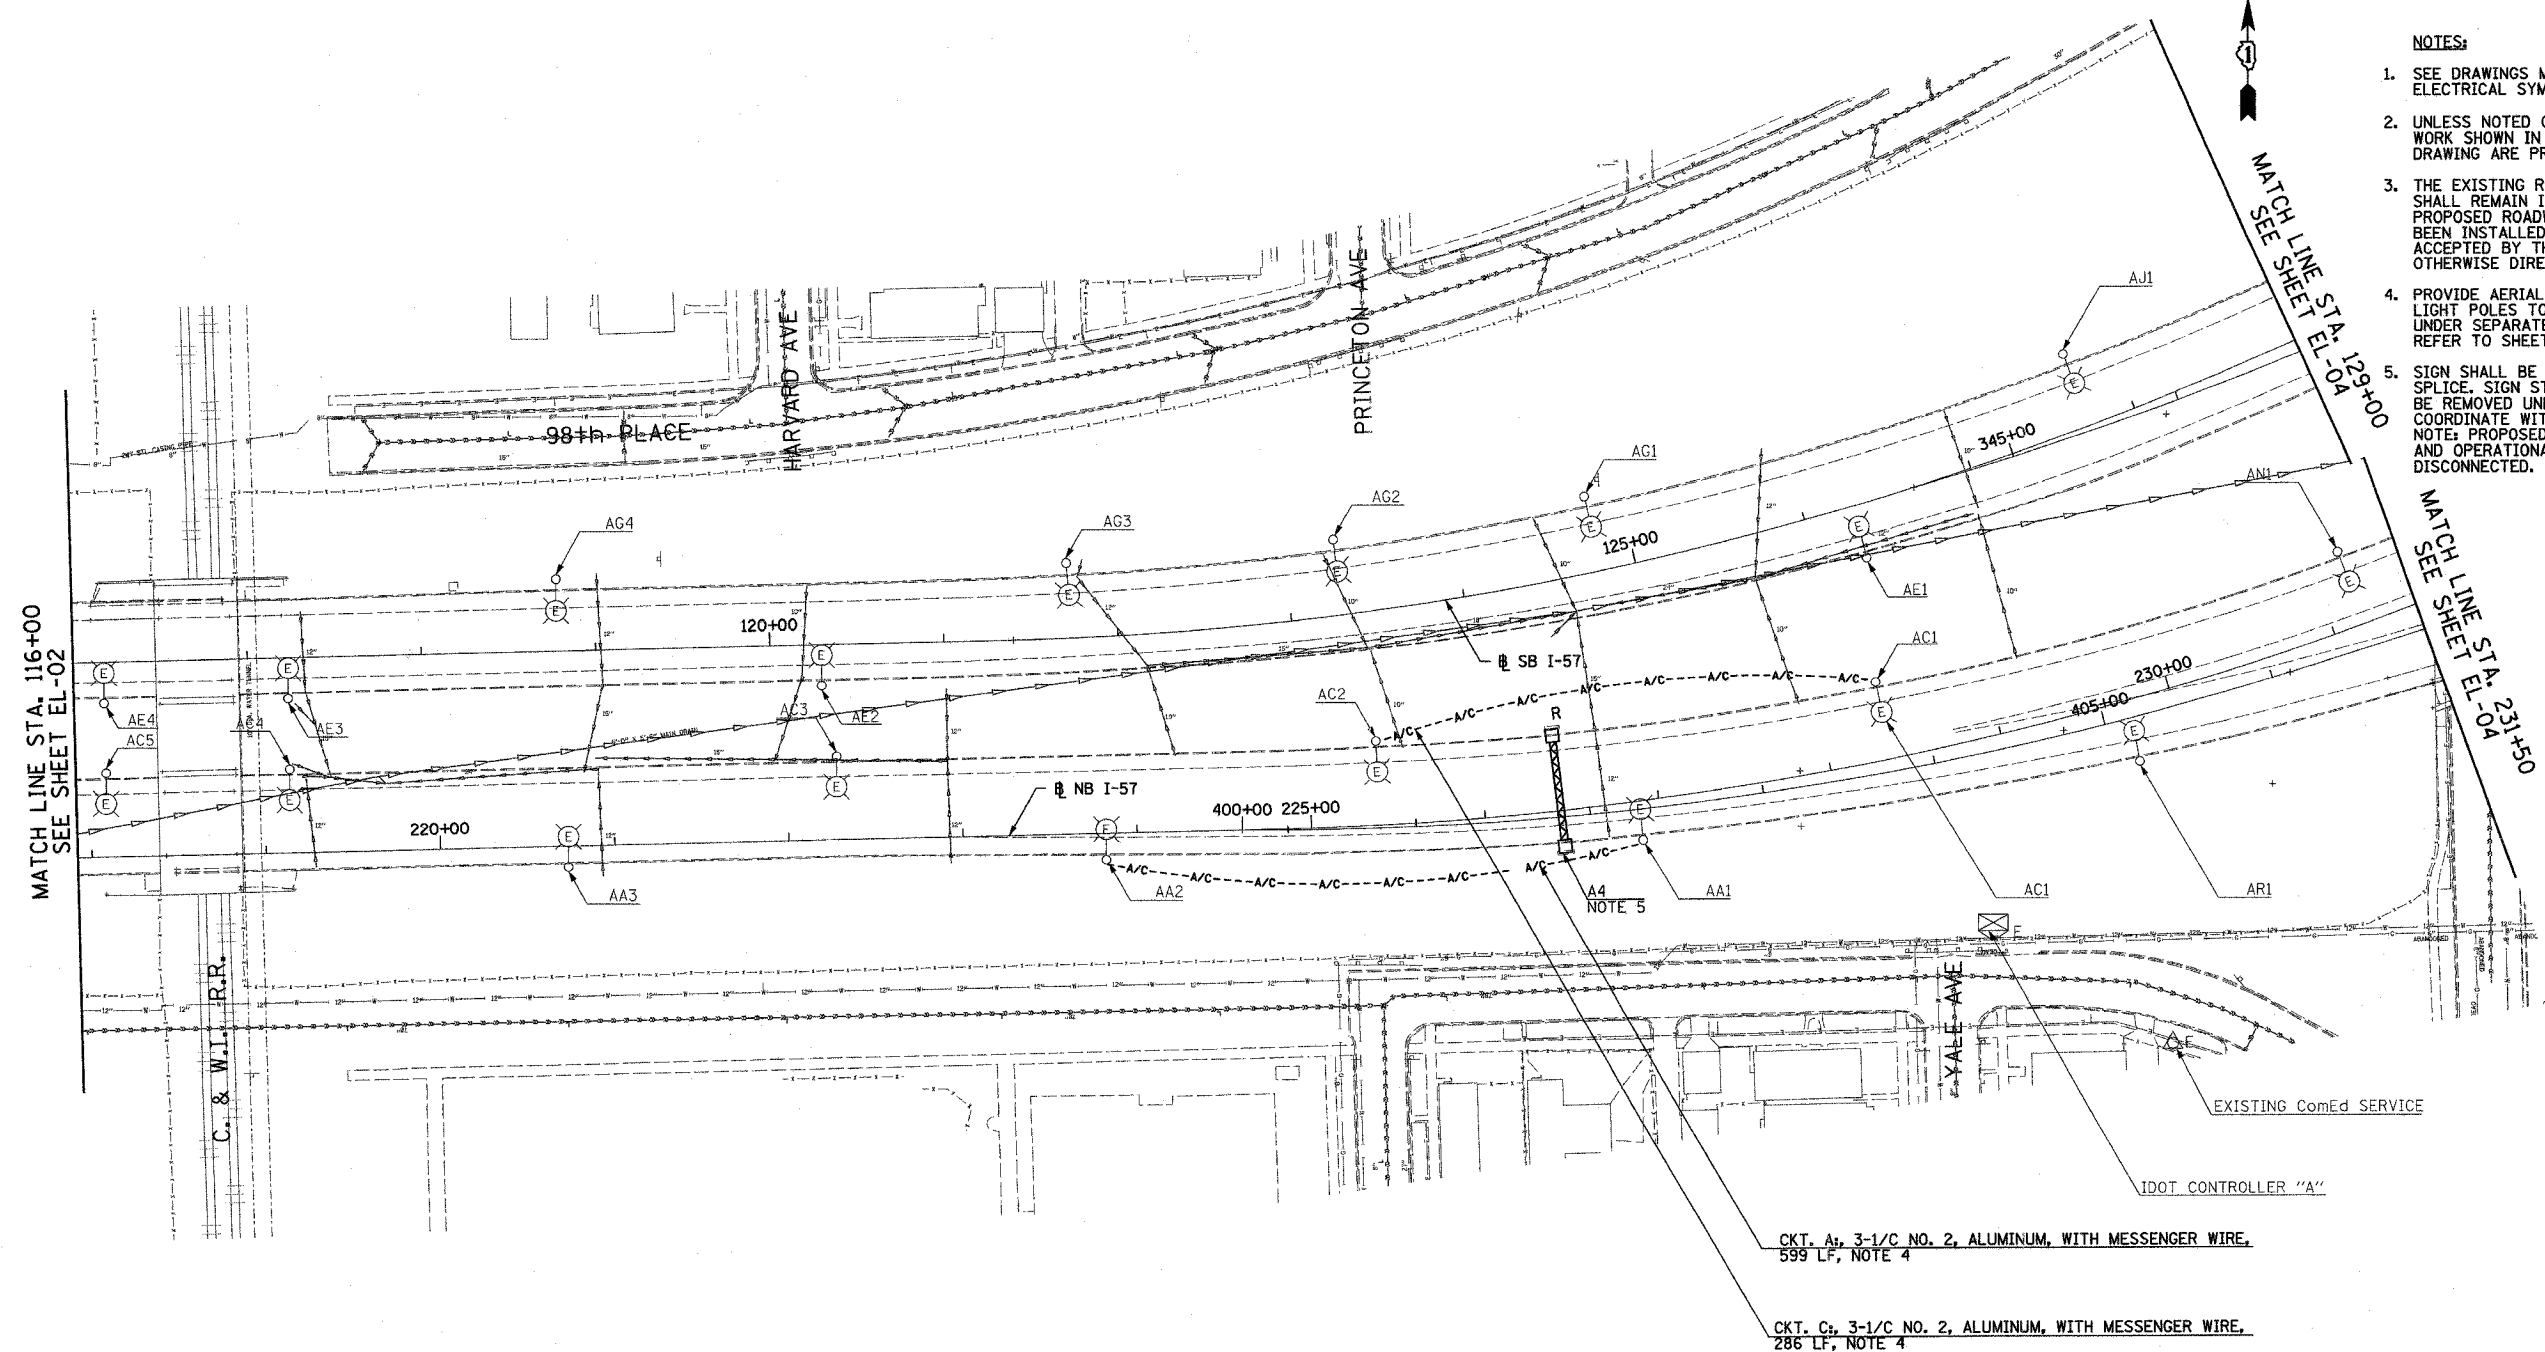

 
MATCH LINE STA. 116+00
SEE SHEET EL-02

MATCH LINE STA. 129+00
SEE SHEET EL-04

MATCH LINE STA. 130+150
SEE SHEET EL-04

CKT. A: 3-1/C NO. 2, ALUMINUM, WITH MESSENGER WIRE,
599 LF, NOTE 4

CKT. C: 3-1/C NO. 2, ALUMINUM, WITH MESSENGER WIRE,
286 LF, NOTE 4



EL-03

REVISIONS	
NAME	DATE

ILLINOIS DEPARTMENT OF TRANSPORTATION
F.A.I. 90/94 (DAN RYAN EXPRESSWAY)
31st STREET TO I-57

ROADWAY LIGHTING PLANS EXISTING
CONDITIONS, TEMPORARY AND REMOVAL

SCALE: 1"=50' DRAWN BY: SP
DATE: OCTOBER 29, 2004 CHECKED BY: TM

SINGH
SINGH & ASSOCIATES, INC.
CONSULTING ENGINEERS

300 W. ADAMS ST.
CHICAGO, IL 60608
TEL: (312) 629-0240
FAX: (312) 629-8449

10/20/2004 5:15:59 PM