


F.A.I. RTE.	SECTION	COUNTY	TOTAL SHEETS	SHEET NO.
90/94	2003-0311	COOK	976	103
STA. 1446+50.00		TO STA. 1458+50.00		
FED. ROAD DIST. NO. 1		ILLINOIS FED. AID PROJECT		


62583

**NOTES:**

 - SEE DRAWINGS ME-01 AND ME-02 FOR ELECTRICAL SYMBOLS AND ABBREVIATIONS.
- COORDINATE ALL WORK WITH IDOT CONTRACT NO. 62693.
- UNLESS NOTED OTHERWISE, ALL ITEMS AND WORK SHOWN IN HEAVY LINE WEIGHT ON THIS DRAWING ARE PROPOSED ITEMS AND WORK.
- EXISTING TEMPORARY AERIAL CABLES TO BE REMOVED WILL BE INCLUDED FOR PAYMENT WITH THE "WOODEN POLE REMOVAL" PAY ITEM.
- THE EXISTING ROADWAY LIGHTING MOUNTED ON THE MEDIAN BARRIER WALL NORTH OF 63rd ST TO 59th ST MUST REMAIN IN OPERATION UNTIL THE PROPOSED ROADWAY LIGHTING SYSTEM HAS BEEN INSTALLED, ENERGIZED, TESTED, AND ACCEPTED BY THE ENGINEER, UNLESS OTHERWISE DIRECTED.
- AFTER THE PERMANENT FEED TO EXISTING IDOT CONTROLLER "T" HAS BEEN INSTALLED, TESTED, AND ACCEPTED, THE CONTRACTOR WILL REMOVE THE TEMPORARY FEED TO IDOT CONTROLLER "T".

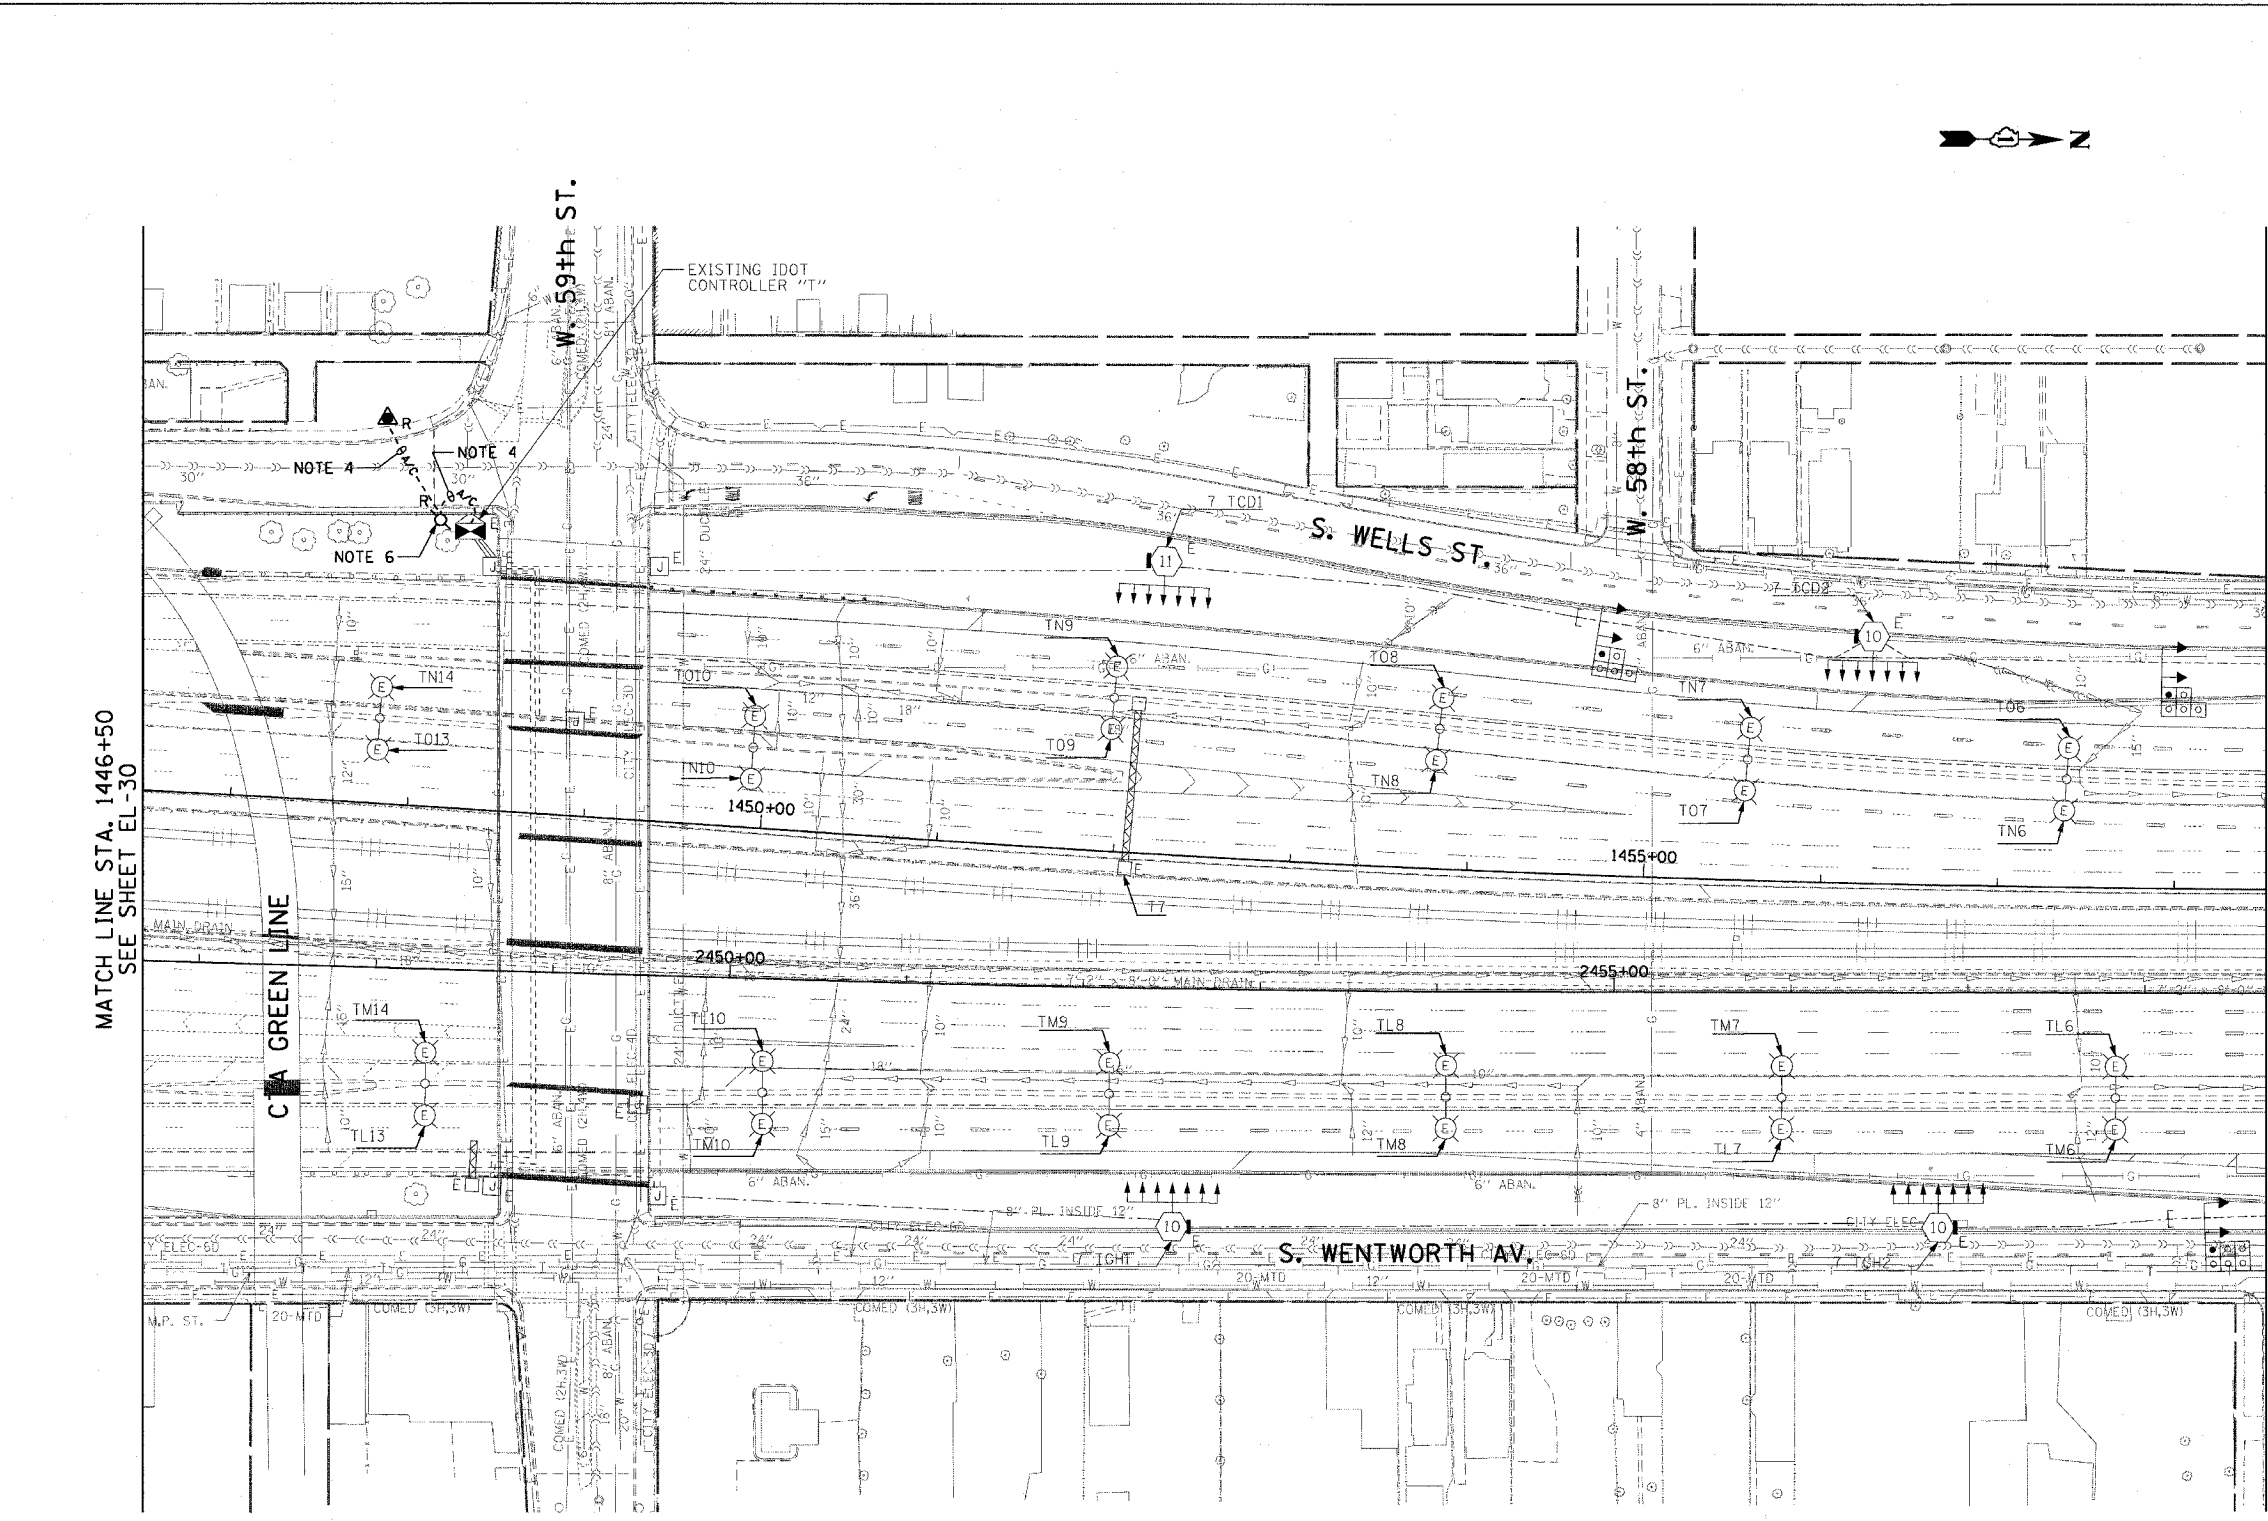

HIGH MAST LIGHT TOWERS, CONTROLLERS, AND WIRING NORTH OF 59th STREET ARE INSTALLED IN IDOT CONTRACT NO. 62733.



EL-31

REVISIONS		
NO.	NAME	DATE
1	REVISED	1/21/05

ILLINOIS DEPARTMENT OF TRANSPORTATION  
 F.A.I. 90/94 (DAN RYAN EXPRESSWAY)  
 31st STREET TO I-57

**ROADWAY LIGHTING PLANS  
 EXISTING CONDITIONS AND DEMOLITION**

SCALE: 1"=50'      DRAWN BY: CJM  
 DATE: October 29, 2004      CHECKED BY: WDS

**CTE ENGINEERS**  
 CONSOER TOWNSEND ENVIRONMENTAL ENGINEERS, INC.  
 303 EAST WACKER DRIVE, SUITE 600  
 CHICAGO ILLINOIS 60601-5222, PHONE: (312) 938-0300

m:\p\0469\0469.dwg:cnr:23\gth contract 2\exist\mgel020310a.dwg 1/24/2005 11:59:40 AM