


F.A.I. RTE.	SECTION	COUNTY	TOTAL SHEETS	SHEET NO.
94/90	2003-0311	COOK	976	116
STA. 1596+00		TO STA. 1608+00		
FED. ROAD DIST. NO.	ILLINOIS FED. AID PROJECT			

62583

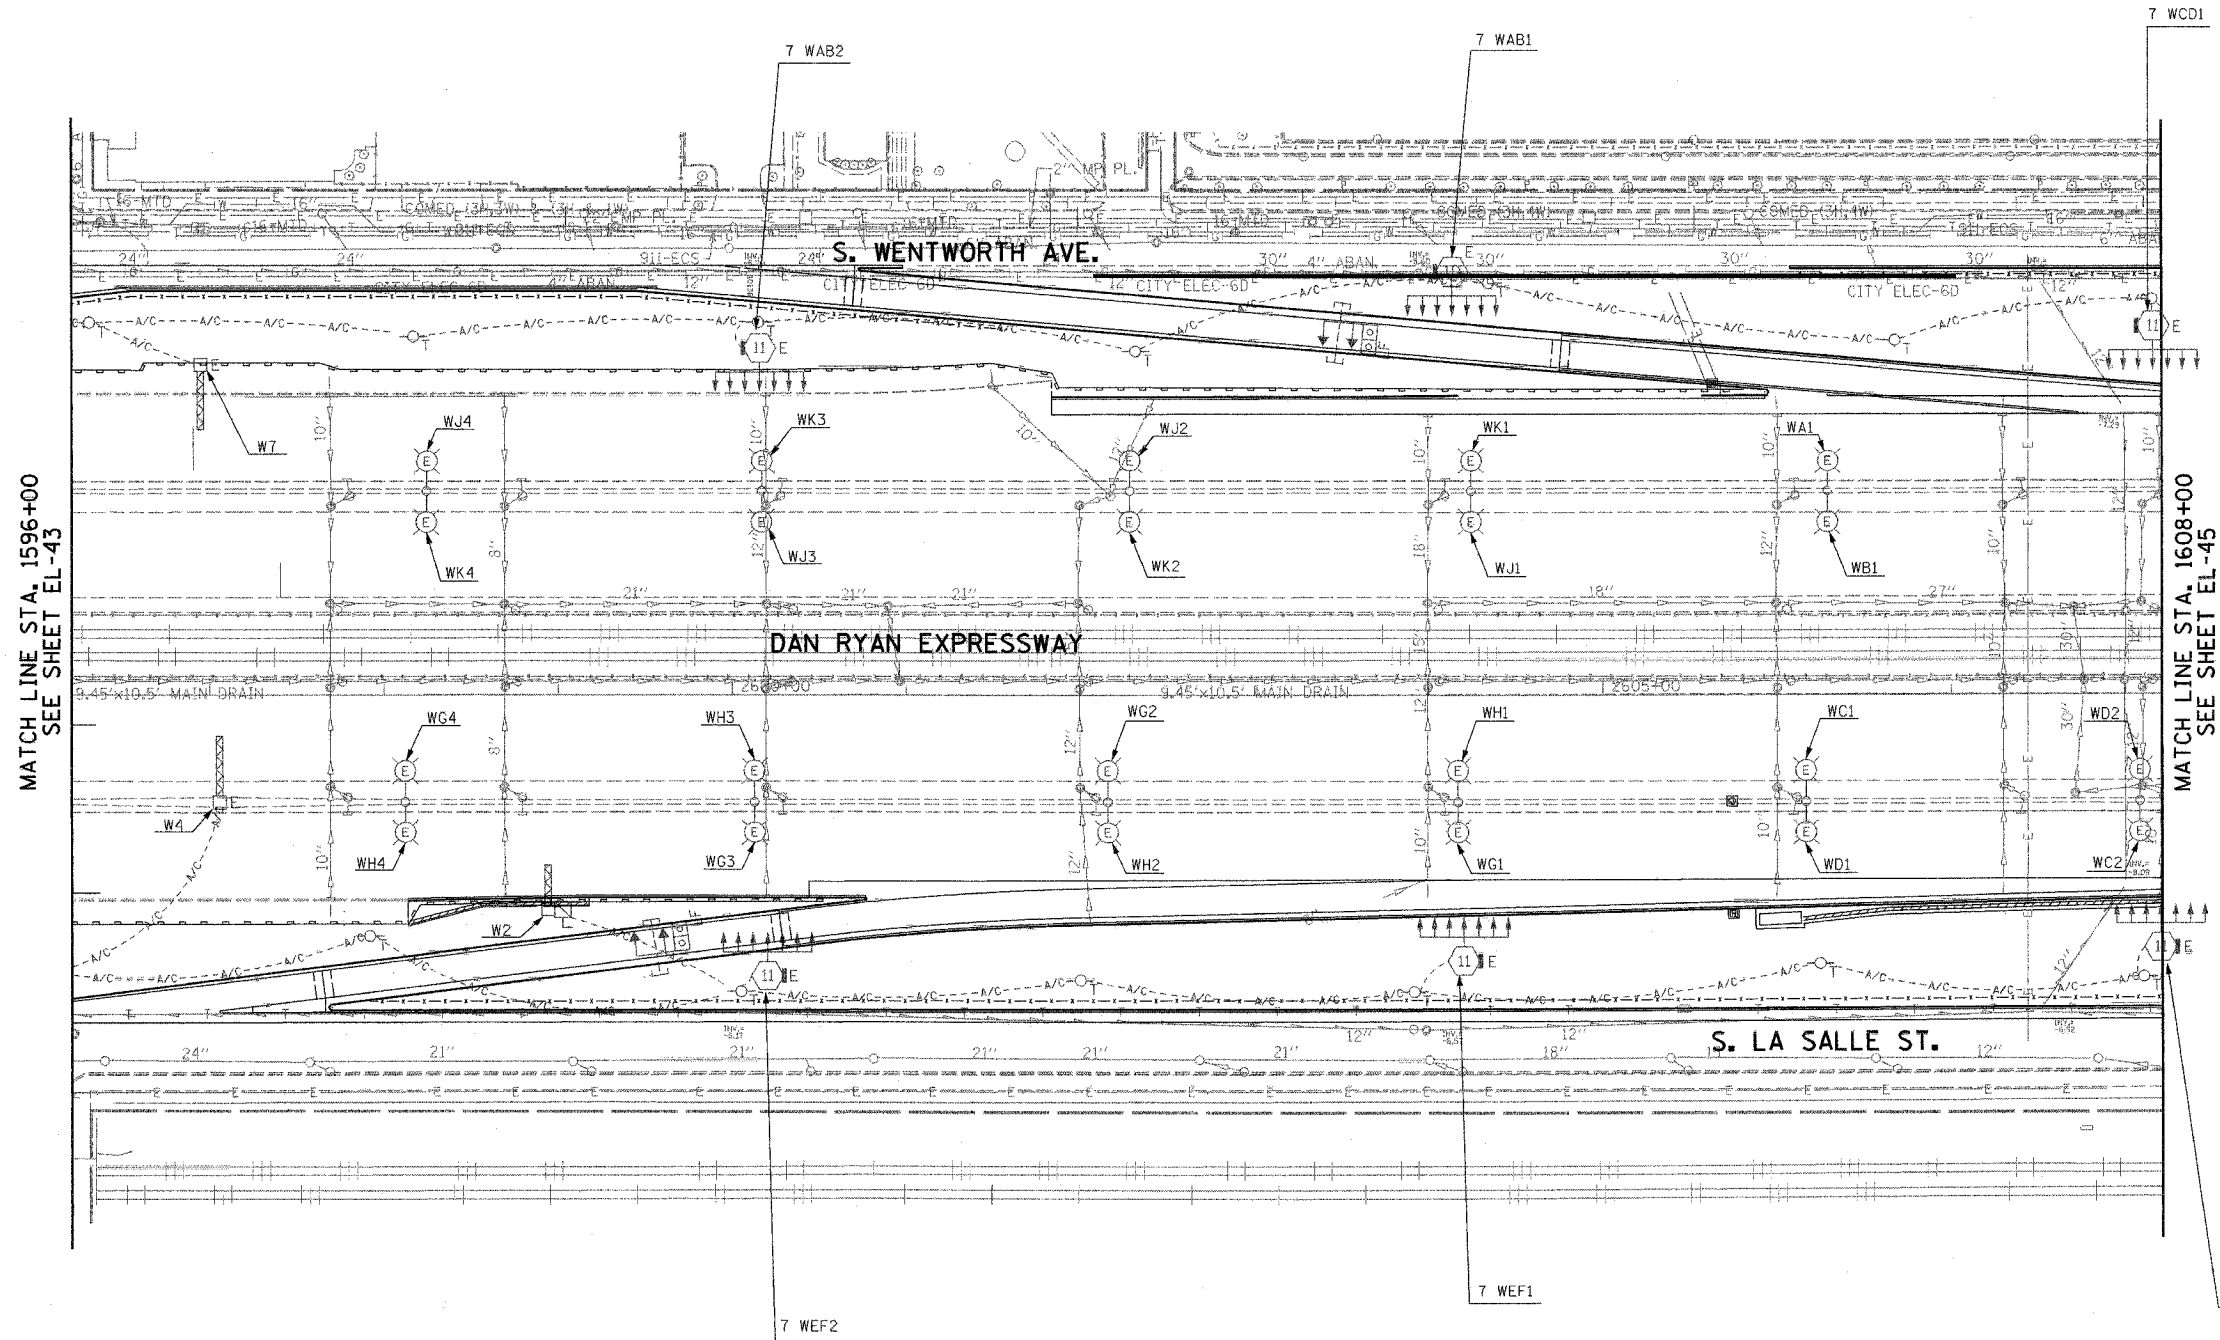

 
MATCH LINE STA. 1596+00
SEE SHEET EL-43

MATCH LINE STA. 1608+00
SEE SHEET EL-45

NOTES:
1. SEE DRAWINGS ME-01 AND ME-02 FOR ELECTRICAL SYMBOLS, AND ABBREVIATIONS.

EL-44

K&J KAM ENGINEERING, INC.
CONSULTING ENGINEERS
707A Davis Road, Suite 205
Elgin, Illinois 60123-1369



REVISIONS	
NAME	DATE

ILLINOIS DEPARTMENT OF TRANSPORTATION
F.A.I. 94/90 (DAN RYAN EXPRESSWAY)
31st STREET TO I-57

**ROADWAY LIGHTING PLANS
EXISTING CONDITIONS AND DEMOLITION**

SCALE: 1"=50'
DATE: OCTOBER 29, 2004

DRAWN BY: BL
CHECKED BY: SM

09/22/2004 10/15/2004