


F.A.I. RTE.	SECTION	COUNTY	TOTAL SHEETS	SHEET NO.
94/90	2003-0311	COOK	976	151
STA. 1529+50		TO STA. 1536+00		
FED. ROAD DIST. NO.		ILLINOIS FED. AID PROJECT		
62583				

- NOTES:**
- SEE DRAWINGS ME-01 AND ME-02 FOR ELECTRICAL SYMBOLS AND ABBREVIATIONS.
 - UNLESS NOTED OTHERWISE, ALL ITEMS AND WORK SHOWN IN HEAVY LINE WEIGHT ON THIS DRAWING ARE PROPOSED NEW ITEMS AND WORK.
 - AERIAL CABLE AND TEMPORARY WOOD POLES SHALL BE INSTALLED TO PROVIDE TEMPORARY CONNECTIONS FOR THE PROPOSED HIGH MAST TOWERS.
 - EXISTING LIGHTING SHALL REMAIN OPERATIONAL UNTIL THE PROPOSED HIGH MAST TOWERS OR TEMPORARY LIGHTING ARE INSTALLED AND OPERATIONAL.
 - TEMPORARY LIGHTING TO BE INSTALLED AS SHOWN, BUT NOT OPERATIONAL.

CKT. C&D: 3*2 WITH MESSENGER TO CONTROLLER "U"

CKT. G&H: 3*2 WITH MESSENGER TO CONTROLLER "U"

CKT. G&H: 3*2 WITH MESSENGER

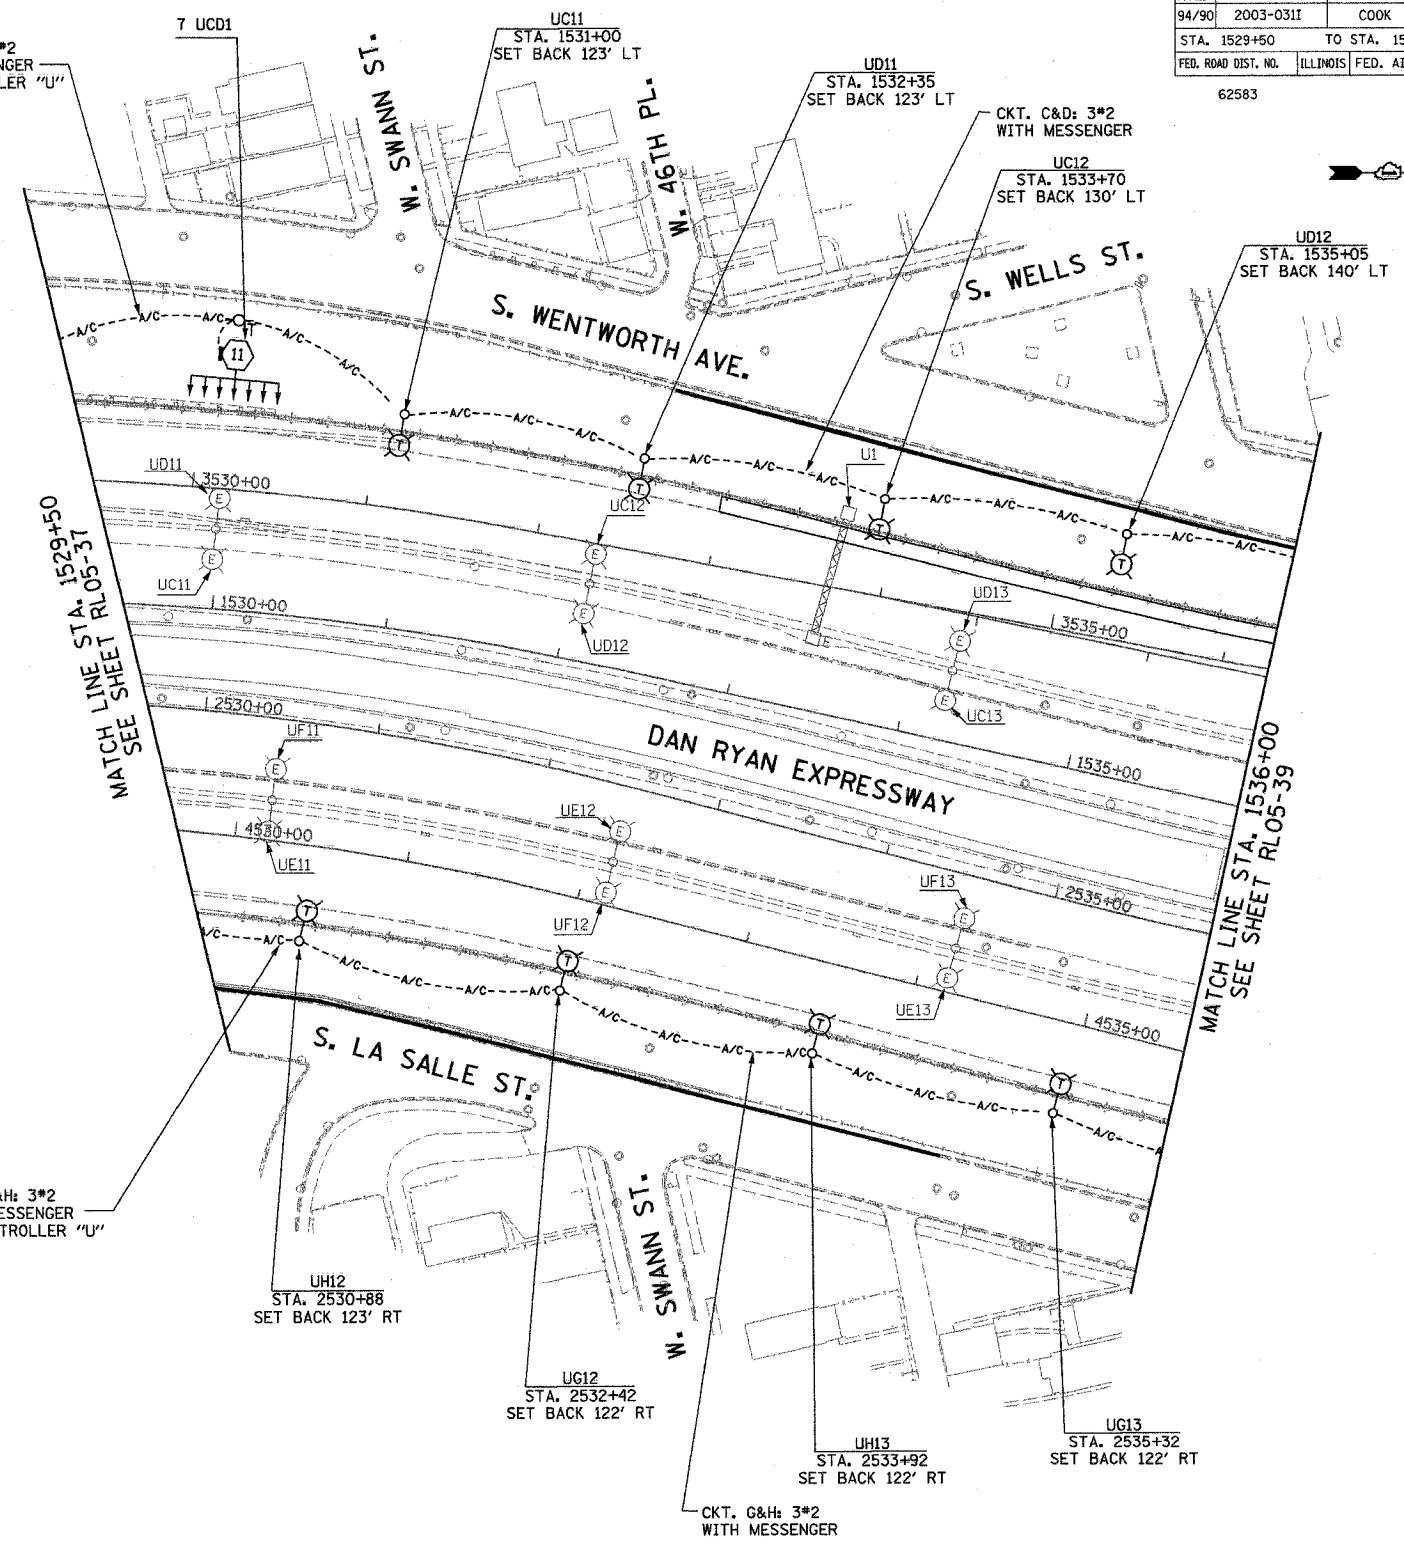


MATCH LINE STA. 1529+50
SEE SHEET RL05-37

MATCH LINE STA. 1536+00
SEE SHEET RL05-39

RL05-38

 K&E KAM ENGINEERING, INC.
CONSULTING ENGINEERS
707A Davis Road, Suite 205
Eglin, Illinois 60123-1369



REVISIONS	
NAME	DATE

ILLINOIS DEPARTMENT OF TRANSPORTATION
F.A.I. 94/90 (DAN RYAN EXPRESSWAY)
31st STREET TO I-57

**ROADWAY LIGHTING PLANS
PROPOSED IMPROVEMENTS 2005**

SCALE: 1"=50' DRAWN BY: BL
DATE: OCTOBER 29, 2004 CHECKED BY: SM

G:\proj\94\90\31st St\Lighting\RL05-38A.DWG 10/15/2004 09:55:59 AM