


F.A.I. RTE.	SECTION	COUNTY	TOTAL SHEETS	SHEET NO.
90/94	2003-0311	COOK	976	176
STA. 1269+00		TO STA. 1282+00		
FED. ROAD DIST. NO.	ILLINOIS	FED. AID PROJECT	62583	

 
NOTES:

- SEE DRAWINGS ME-01 AND ME-02 FOR ELECTRICAL SYMBOLS AND ABBREVIATIONS.
- UNLESS NOTED OTHERWISE, ALL ITEMS AND WORK SHOWN IN HEAVY LINE WEIGHT ON THIS DRAWING ARE PROPOSED NEW ITEMS OF WORK.
- SEE SHEET ES-01 AND ES-02 FOR HIGH MAST LIGHT TOWER SCHEDULE.
- THE EXISTING ROADWAY LIGHTING SYSTEM SHALL REMAIN IN OPERATION UNTIL THE PROPOSED ROADWAY LIGHTING SYSTEM HAS BEEN INSTALLED, ENERGIZED, TESTED, AND ACCEPTED BY THE ENGINEER, UNLESS OTHERWISE DIRECTED BY THE ENGINEER.
- PROVIDE AERIAL CABLE BETWEEN EXISTING LIGHT POLES TO PERMIT INSTALLATION OF SIGN STRUCTURE UNDER SEPARATE CONTRACT. REFER TO SHEET ME-16
- SIGN LUMINAIRES, DISCONNECT SWITCH AND WIRING SHALL BE PROVIDED UNDER THIS CONTRACT. SIGN STRUCTURE SHALL BE INSTALLED UNDER SEPARATE CONTRACT. NOTE: EXISTING SIGN P4 SHALL NOT BE DISCONNECTED UNTIL PROPOSED SIGN P2 IS INSTALLED AND OPERATIONAL.
- UNIT DUCT SHALL BE PULLED THROUGH EXISTING UNDERGROUND DUCTBANKS PROVIDED UNDER SEPARATE CONTRACT. UNIT DUCT SHALL BE INSTALLED BETWEEN HIGH MAST LIGHT TOWERS IN CONTINUOUS LENGTHS WITHOUT SPLICES.
- INSTALL LIGHT TOWER ONLY. FOUNDATION SHALL BE PROVIDED UNDER SEPARATE CONTRACT. COORDINATE WITH CIVIL CONTRACTS AND AS DIRECTED BY THE ENGINEER.

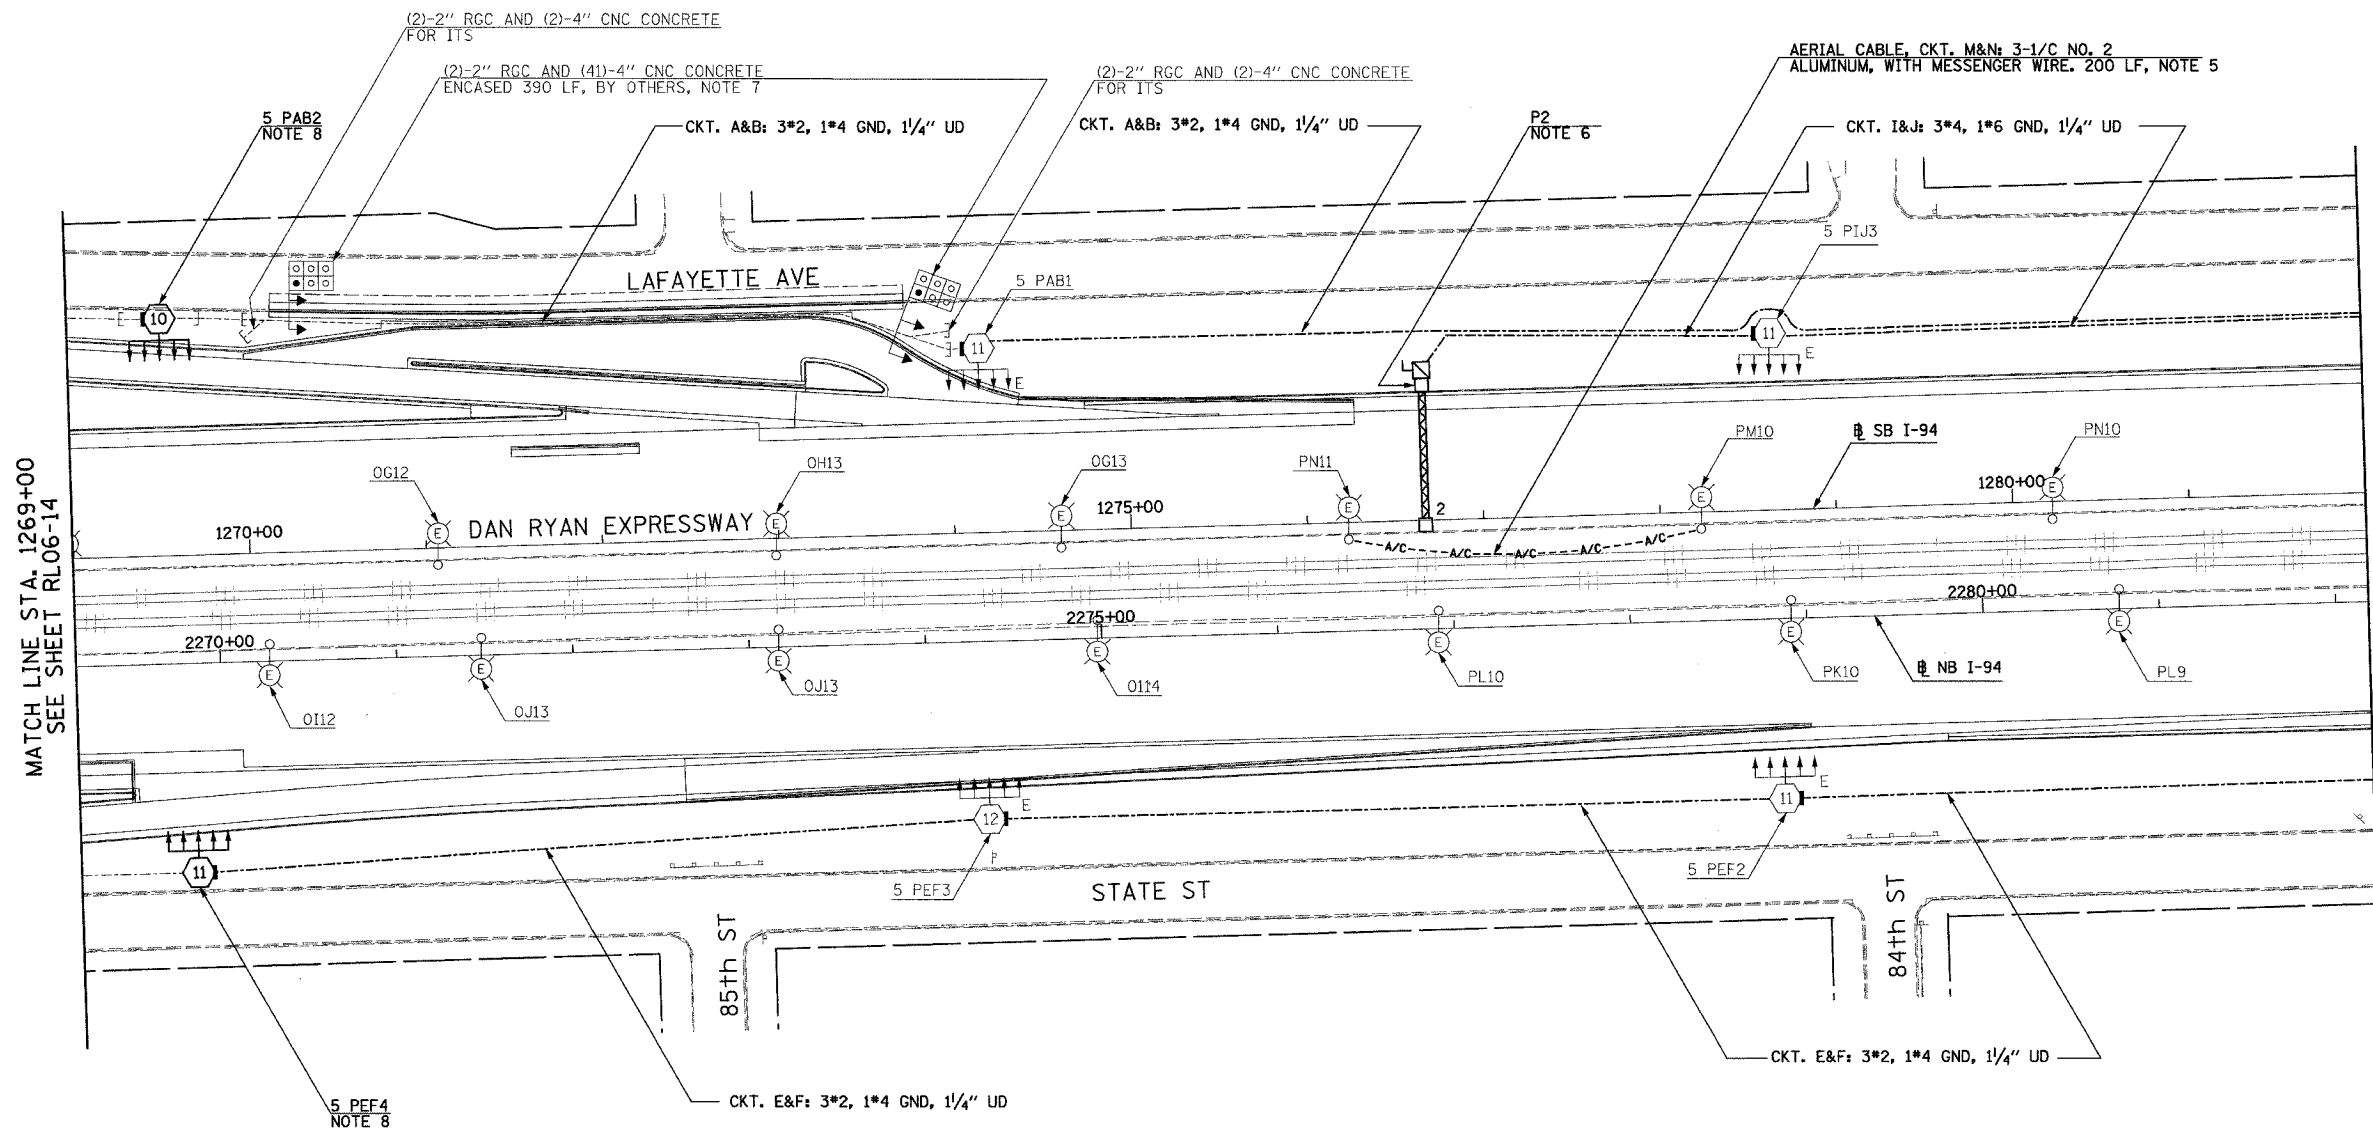

MATCH LINE STA. 1269+00  
SEE SHEET RL06-14

MATCH LINE STA. 1282+00  
SEE SHEET RL06-16



RL06-15

REVISIONS	
NAME	DATE

ILLINOIS DEPARTMENT OF TRANSPORTATION  
F.A.I. 90/94 (DAN RYAN EXPRESSWAY)  
31st STREET TO I-57  
ROADWAY LIGHTING PLANS  
PROPOSED IMPROVEMENTS 2006

SCALE: 1"=50'  
DATE: OCTOBER 29, 2004  
DRAWN BY: VG  
CHECKED BY: TM

**SINGH**  
SINGH & ASSOCIATES, INC.  
CONSULTING ENGINEERS

300 W. ADAMS ST.  
CHICAGO, IL 60606  
TEL: (312) 629-0240  
FAX: (312) 629-8449

11/22/2004 3:29:44 PM