


F.A.I. RTE.	SECTION	COUNTY	TOTAL SHEETS	SHEET NO.
90/94	2003-0311	COOK	976	280
STA. 1376+00.00 TO STA. 1388+00.00		ILLINOIS FED. AID PROJECT		

62583


**NOTES:**

 1. SEE DRAWINGS ME-01 AND ME-02 FOR ELECTRICAL SYMBOLS AND ABBREVIATIONS.
2. SEE DRAWING ES-04 FOR HIGH MAST LIGHT TOWER SCHEDULE.
3. SEE DRAWING UL-20 FOR 69th STREET UNDERPASS LIGHTING PLANS.

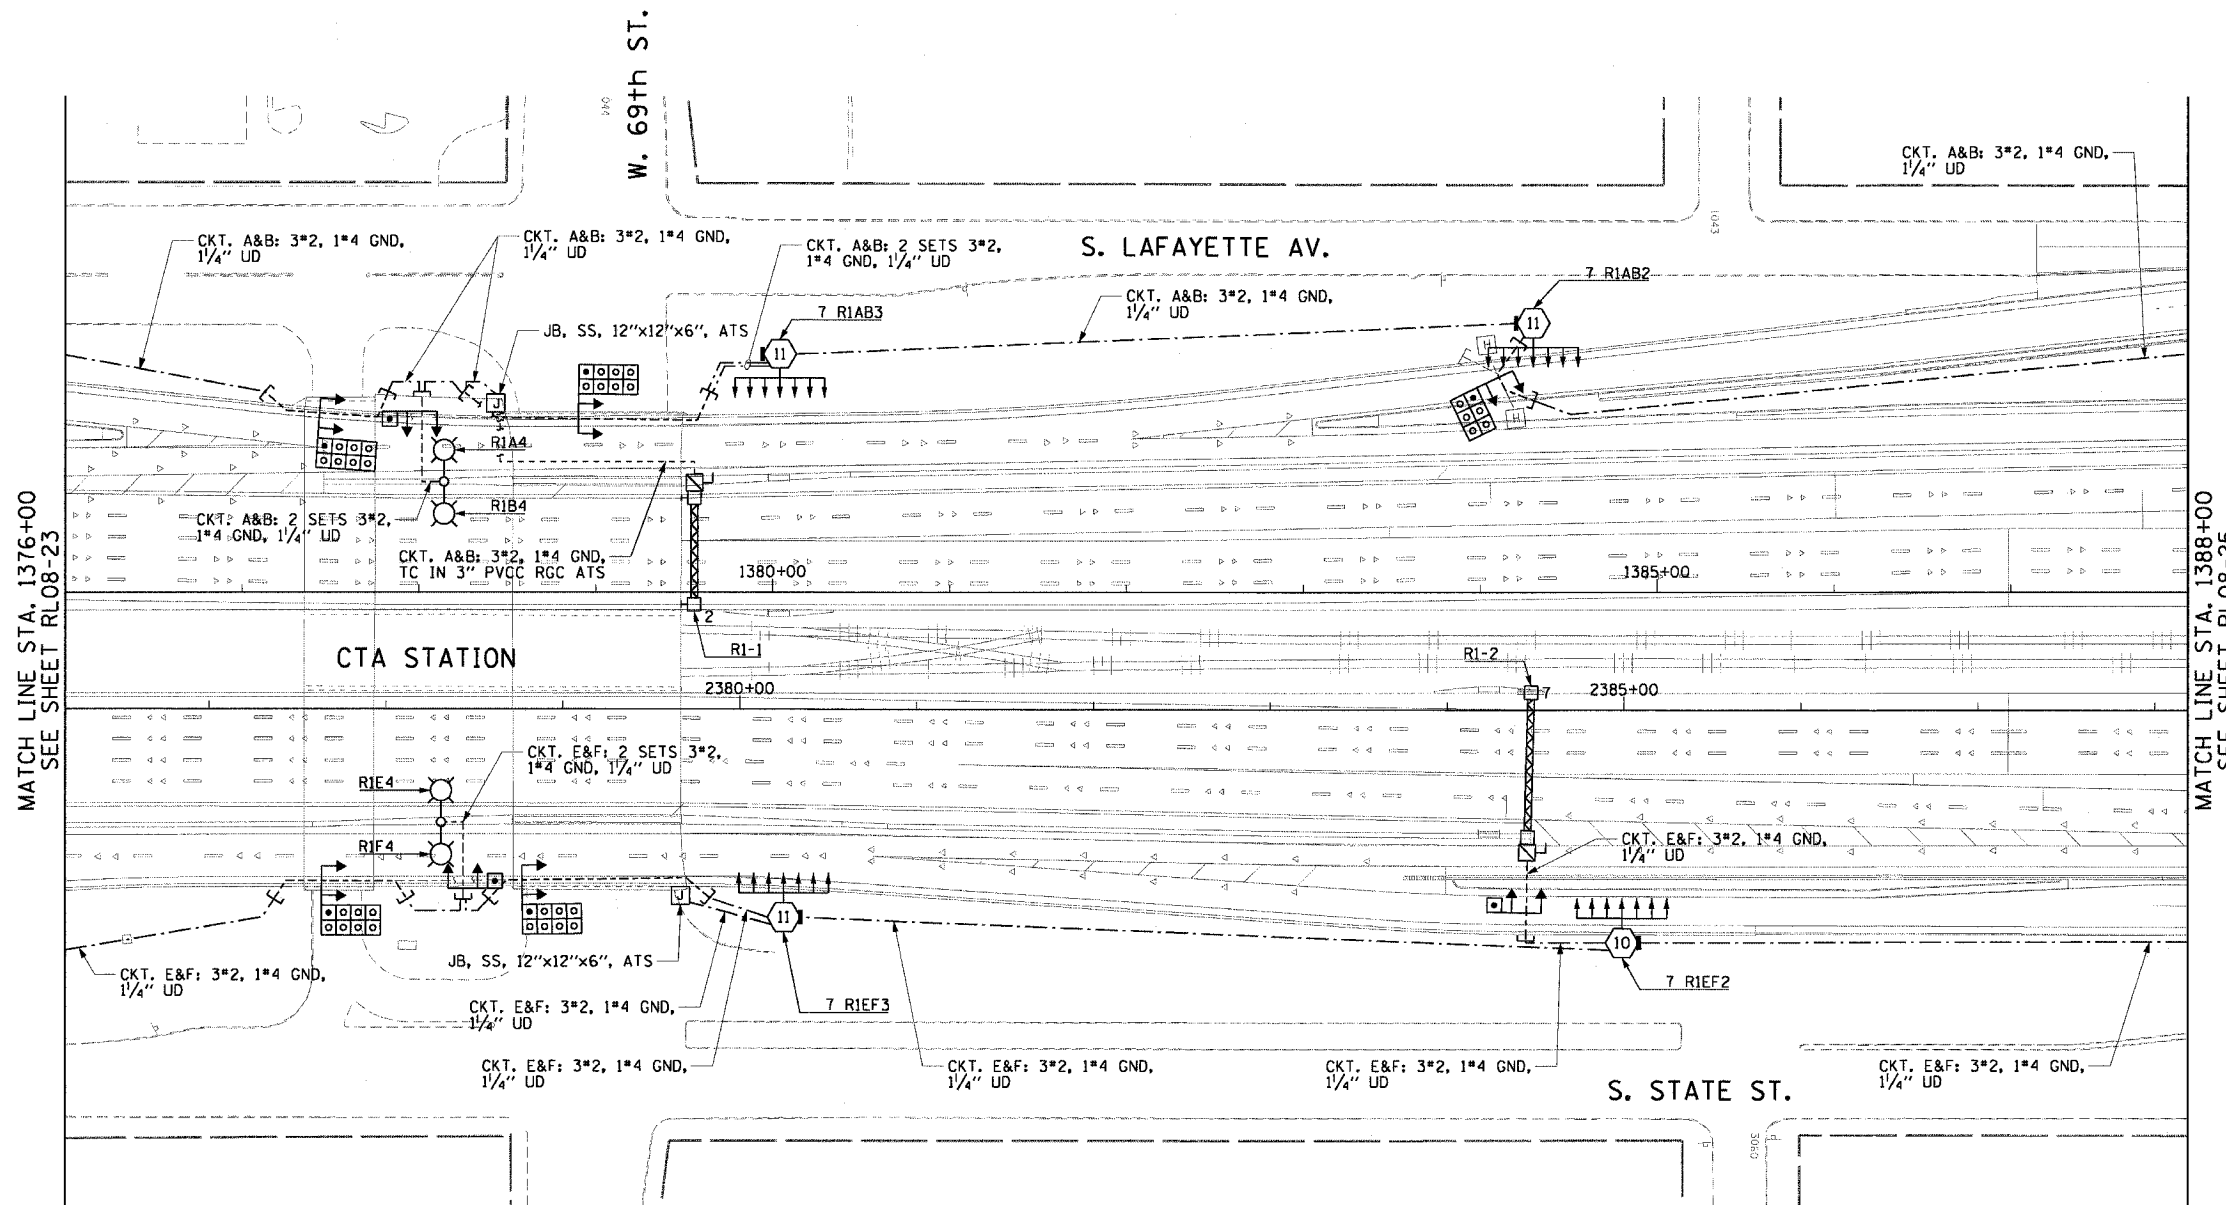

MATCH LINE STA. 1376+00  
SEE SHEET RL08-23

MATCH LINE STA. 1388+00  
SEE SHEET RL08-25



RL08-24

REVISIONS	
NAME	DATE

ILLINOIS DEPARTMENT OF TRANSPORTATION  
F.A.I. 90/94 (DAN RYAN EXPRESSWAY)  
31st STREET TO I-57

**ROADWAY LIGHTING PLANS  
FINAL CONDITIONS**

SCALE: 1"=50'      DRAWN BY: CJM  
DATE: October 29, 2004      CHECKED BY: WDS

**CTE ENGINEERS**  
CONSOER TOWNSEND ENVIRONMENTAL ENGINEERS, INC.  
303 EAST WACKER DRIVE, SUITE 600  
CHICAGO ILLINOIS 60601-5202, PHONE: (312) 938-0300

m:\p\40465\elec\94\cmt\25\rl08-24.ctb 2/2008 11:02:42 AM