


F.A.I. RTE.	SECTION	COUNTY	TOTAL SHEETS	SHEET NO.
94/90	2003-0311	COOK	976	92-1
STA.		TO STA.		
FED. ROAD DIST. NO.	ILLINOIS FED. AID PROJECT			

62583

LEGEND:

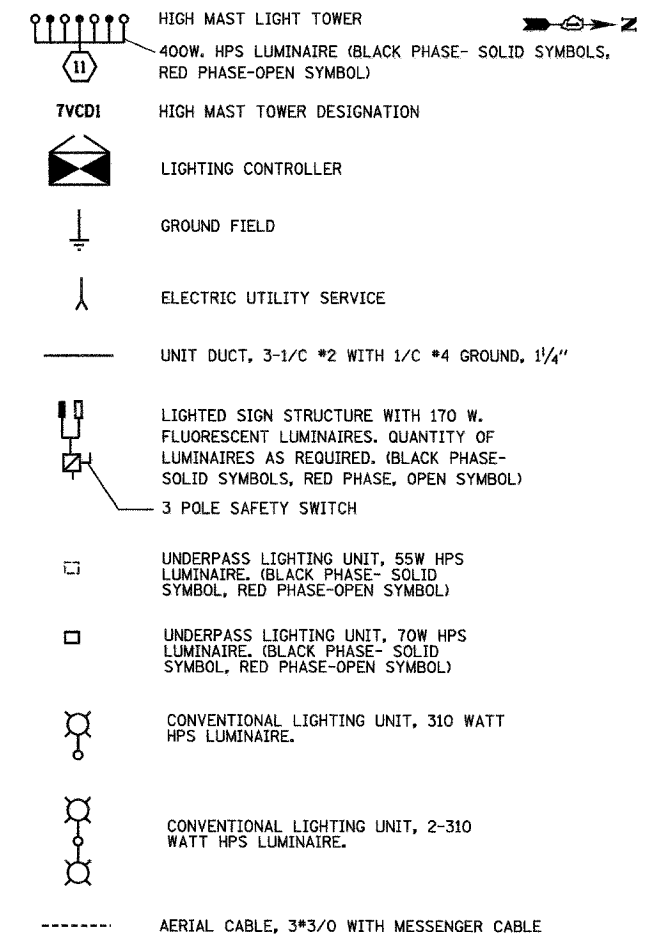

CIRCUIT	RED PHASE		BLACK PHASE		
	AMPS	WATTS	AMPS	WATTS	
A	17.90	3590	B	17.10	3420
C	18.80	3890	D	18.80	3890
E	29.30	5830	F	27.30	5430
G	12.90	2680	H	12.90	2680
I	16.60	3440	J	16.60	3440
K	3.15	495	L	3.15	495
M	12.45	2535	N	12.45	2535
O	14.05	2875	P	14.15	2905
TOTAL	125.15A	25,335	TOTAL	122.45A	24,795


SL06-13

REVISIONS	NAME	DATE

ILLINOIS DEPARTMENT OF TRANSPORTATION
F.A.I. 94/90 (DAN RYAN EXPRESSWAY)
31st STREET TO I-57

SINGLE LINE DIAGRAM
LIGHTING CONTROLLER "X"
PROPOSED IMPROVEMENTS 2006

SCALE: NONE
DATE: OCTOBER 29, 2004
DRAWN BY: BL
CHECKED BY: SM

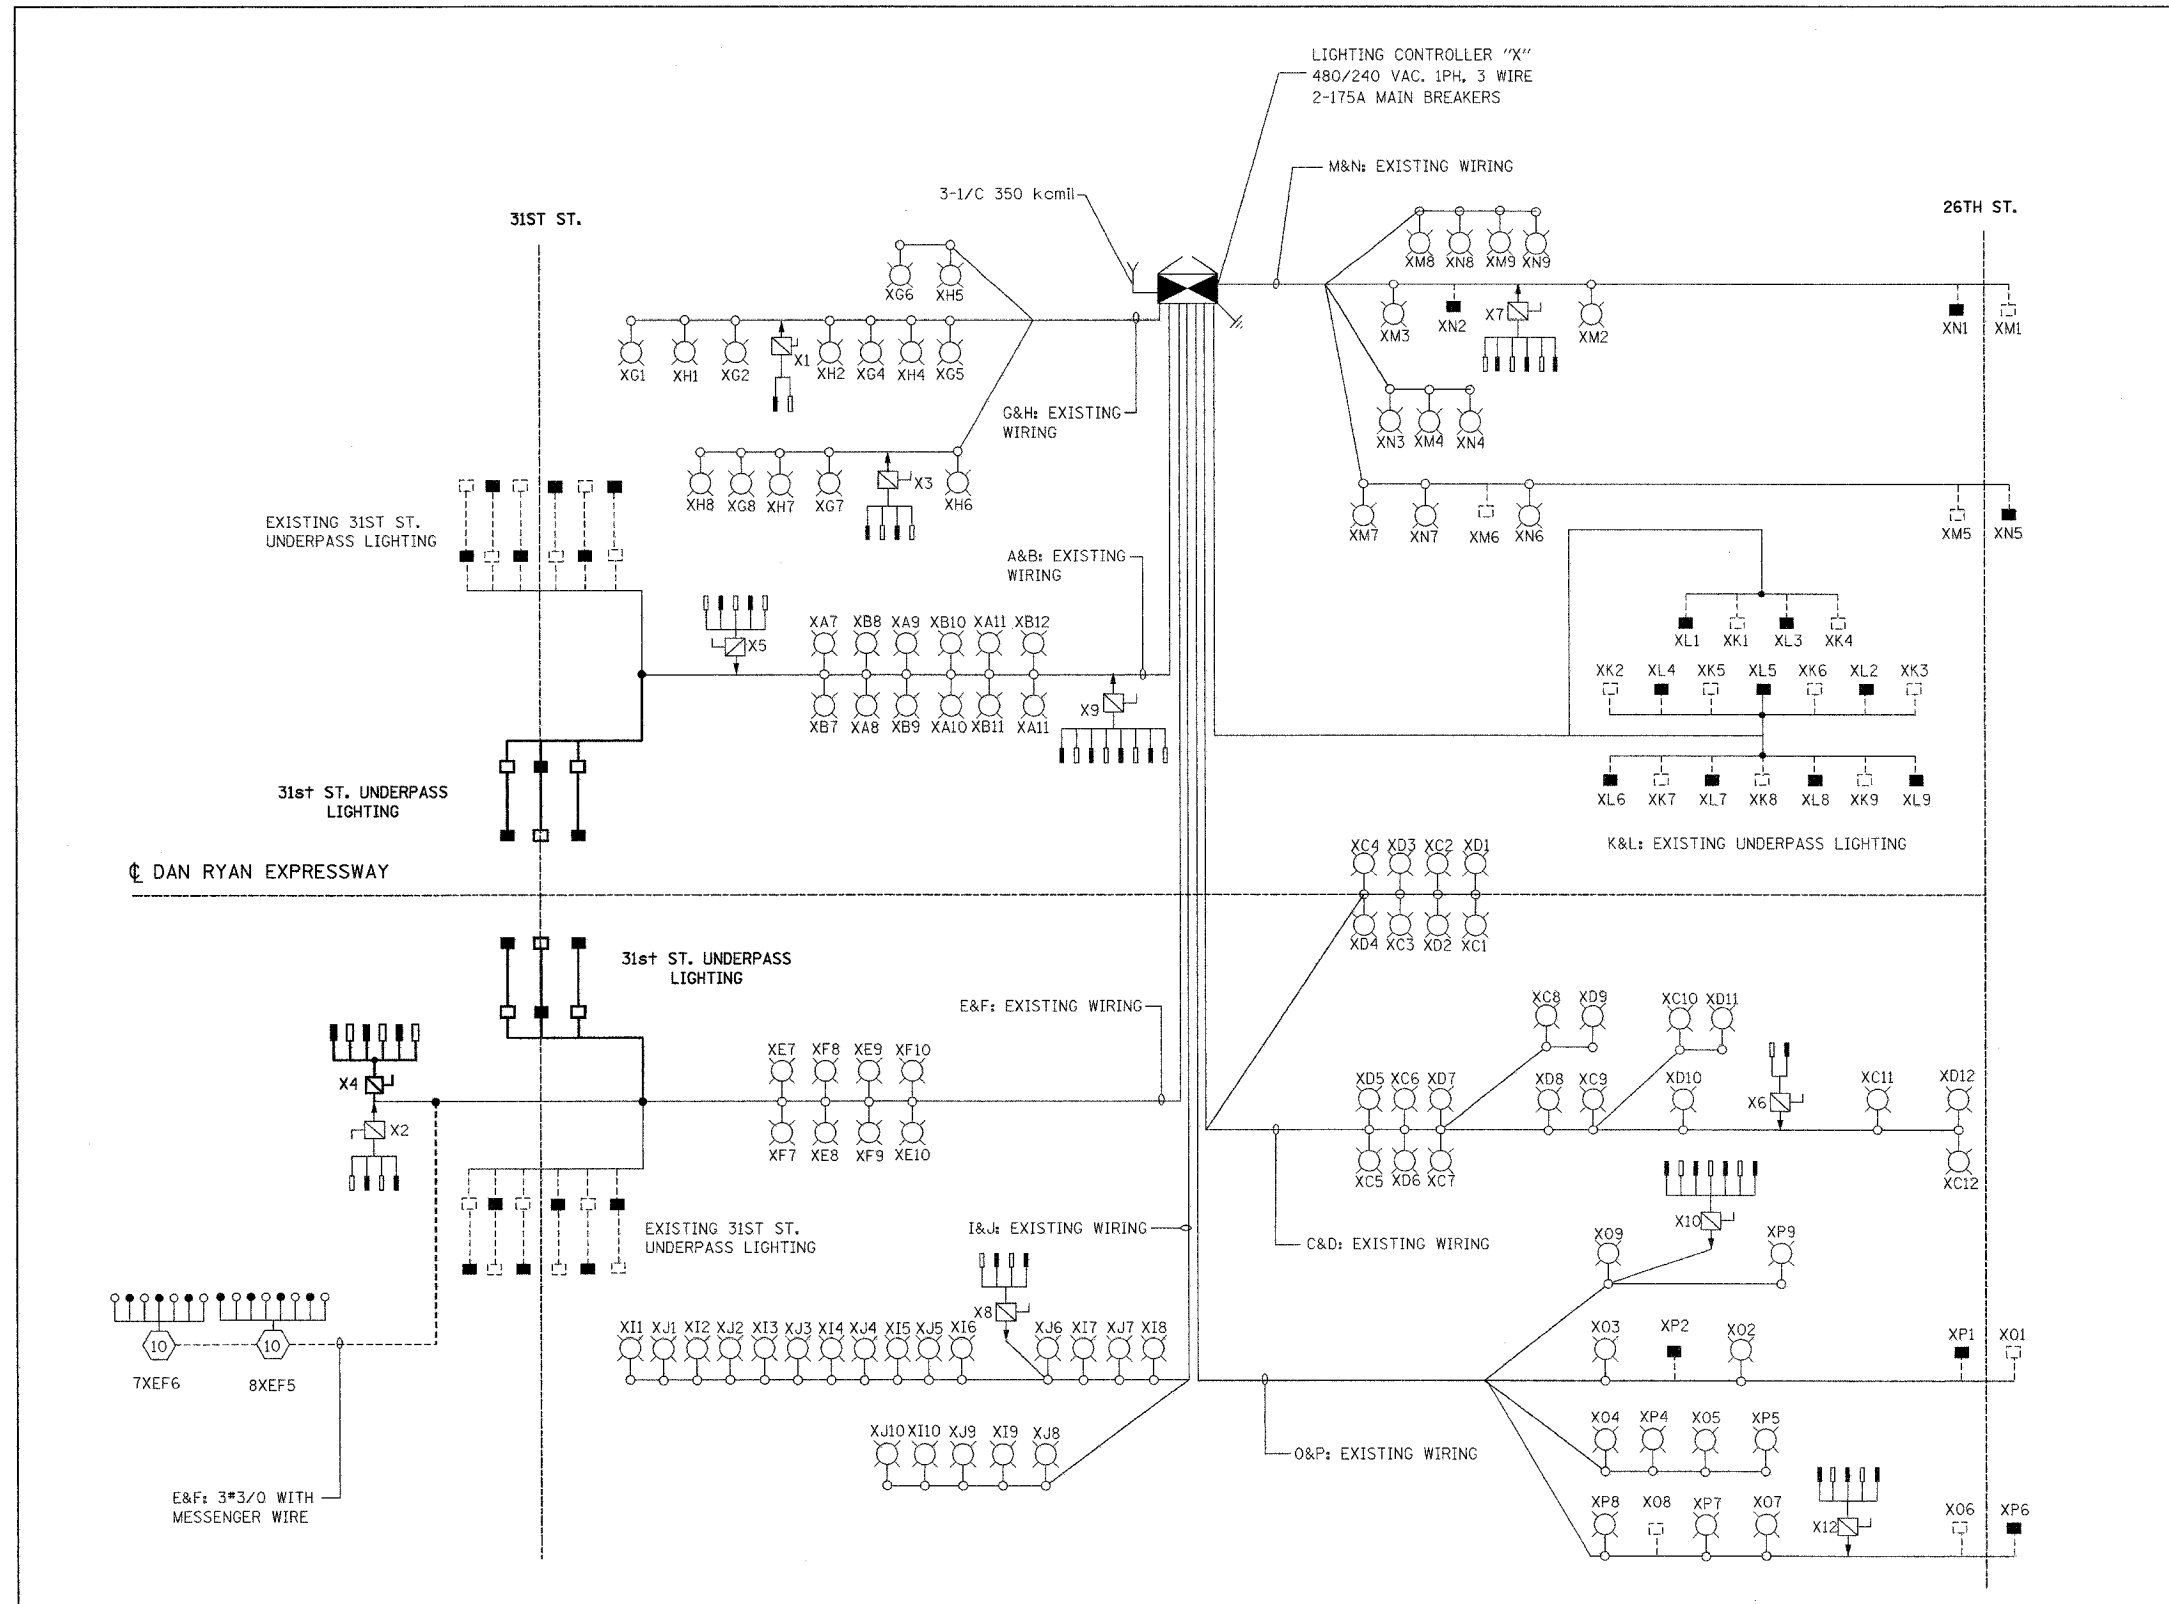

KAM ENGINEERING, INC.
CONSULTING ENGINEERS
707A Davis Road, Suite 205
Elgin, Illinois 60123-1369

10/16/2004 12:07:53 PM G:\projects\08 31st St\Lighting\SL06-13.dwg