

F.A.I. RTE.	SECTION	COUNTY	TOTAL SHEETS	SHEET NO.
90/94	2003-0311	COOK	976	335
STA.	TO STA.			
FED. ROAD DIST. NO. 1	ILLINOIS FED. AID PROJECT			

62583

**LEGEND**

- HIGH MAST LIGHT TOWER
- 400 WATT HPS LUMINAIRE (BLACK PHASE-SOLID SYMBOL, RED PHASE-OPEN SYMBOL)
- HIGH MAST TOWER DESIGNATION
- LIGHTED SIGN STRUCTURE WITH 170 WATT FLUORESCENT LUMINAIRE, QUANTITY OF LUMINAIRE AS REQUIRED. (BLACK PHASE-SOLID SYMBOL, RED PHASE-OPEN SYMBOL)
- 3 POLE SAFETY SWITCH
- UNDERPASS LIGHTING UNIT, 70 WATT HPS LUMINAIRE. (BLACK PHASE-SOLID SYMBOL, RED PHASE-OPEN SYMBOL)
- LIGHTING CONTROLLER
- GROUND FIELD
- ELECTRIC UTILITY SERVICE
- LUMINAIRE DESIGNATION
- CONVENTIONAL LIGHTING UNIT, 2-310 WATT HPS LUMINAIRE. (BLACK PHASE-SOLID SYMBOL, RED PHASE-OPEN SYMBOL)
- CLOSED CIRCUIT TELEVISION CAMERA

CIRCUIT	RED PHASE		CIRCUIT	BLACK PHASE	
	AMPS	WATTS		AMPS	WATTS
A	31.4	7,536	B	31.0	7,440
C	24.0	5,760	D	25.1	6,024
E	33.9	8,136	F	32.7	7,848
G	32.5	7,800	H	32.0	7,680
I	-	-	J	-	-
K	-	-	L	-	-
M	-	-	N	-	-
O	-	-	P	-	-
TOTAL	121.8	29,232	TOTAL	120.8	28,992

REVISIONS	
NAME	DATE


ILLINOIS DEPARTMENT OF TRANSPORTATION  
F.A.I. 90/94 (DAN RYAN EXPRESSWAY)  
31st STREET TO I-57

**SINGLE LINE DIAGRAM  
LIGHTING CONTROLLER "R1"  
PROPOSED IMPROVEMENTS 2007**

SCALE: NOT TO SCALE      DRAWN BY: CJM  
DATE: October 29, 2004      CHECKED BY: WDS

**NOTES:**  
1. UNLESS NOTED OTHERWISE, ALL ITEMS AND WORK SHOWN IN HEAVY LINE WEIGHT ON THIS DRAWING ARE PROPOSED ITEMS AND WORK.

**SINGLE LINE DIAGRAM  
LIGHTING CONTROLLER "R1"  
NOT TO SCALE**

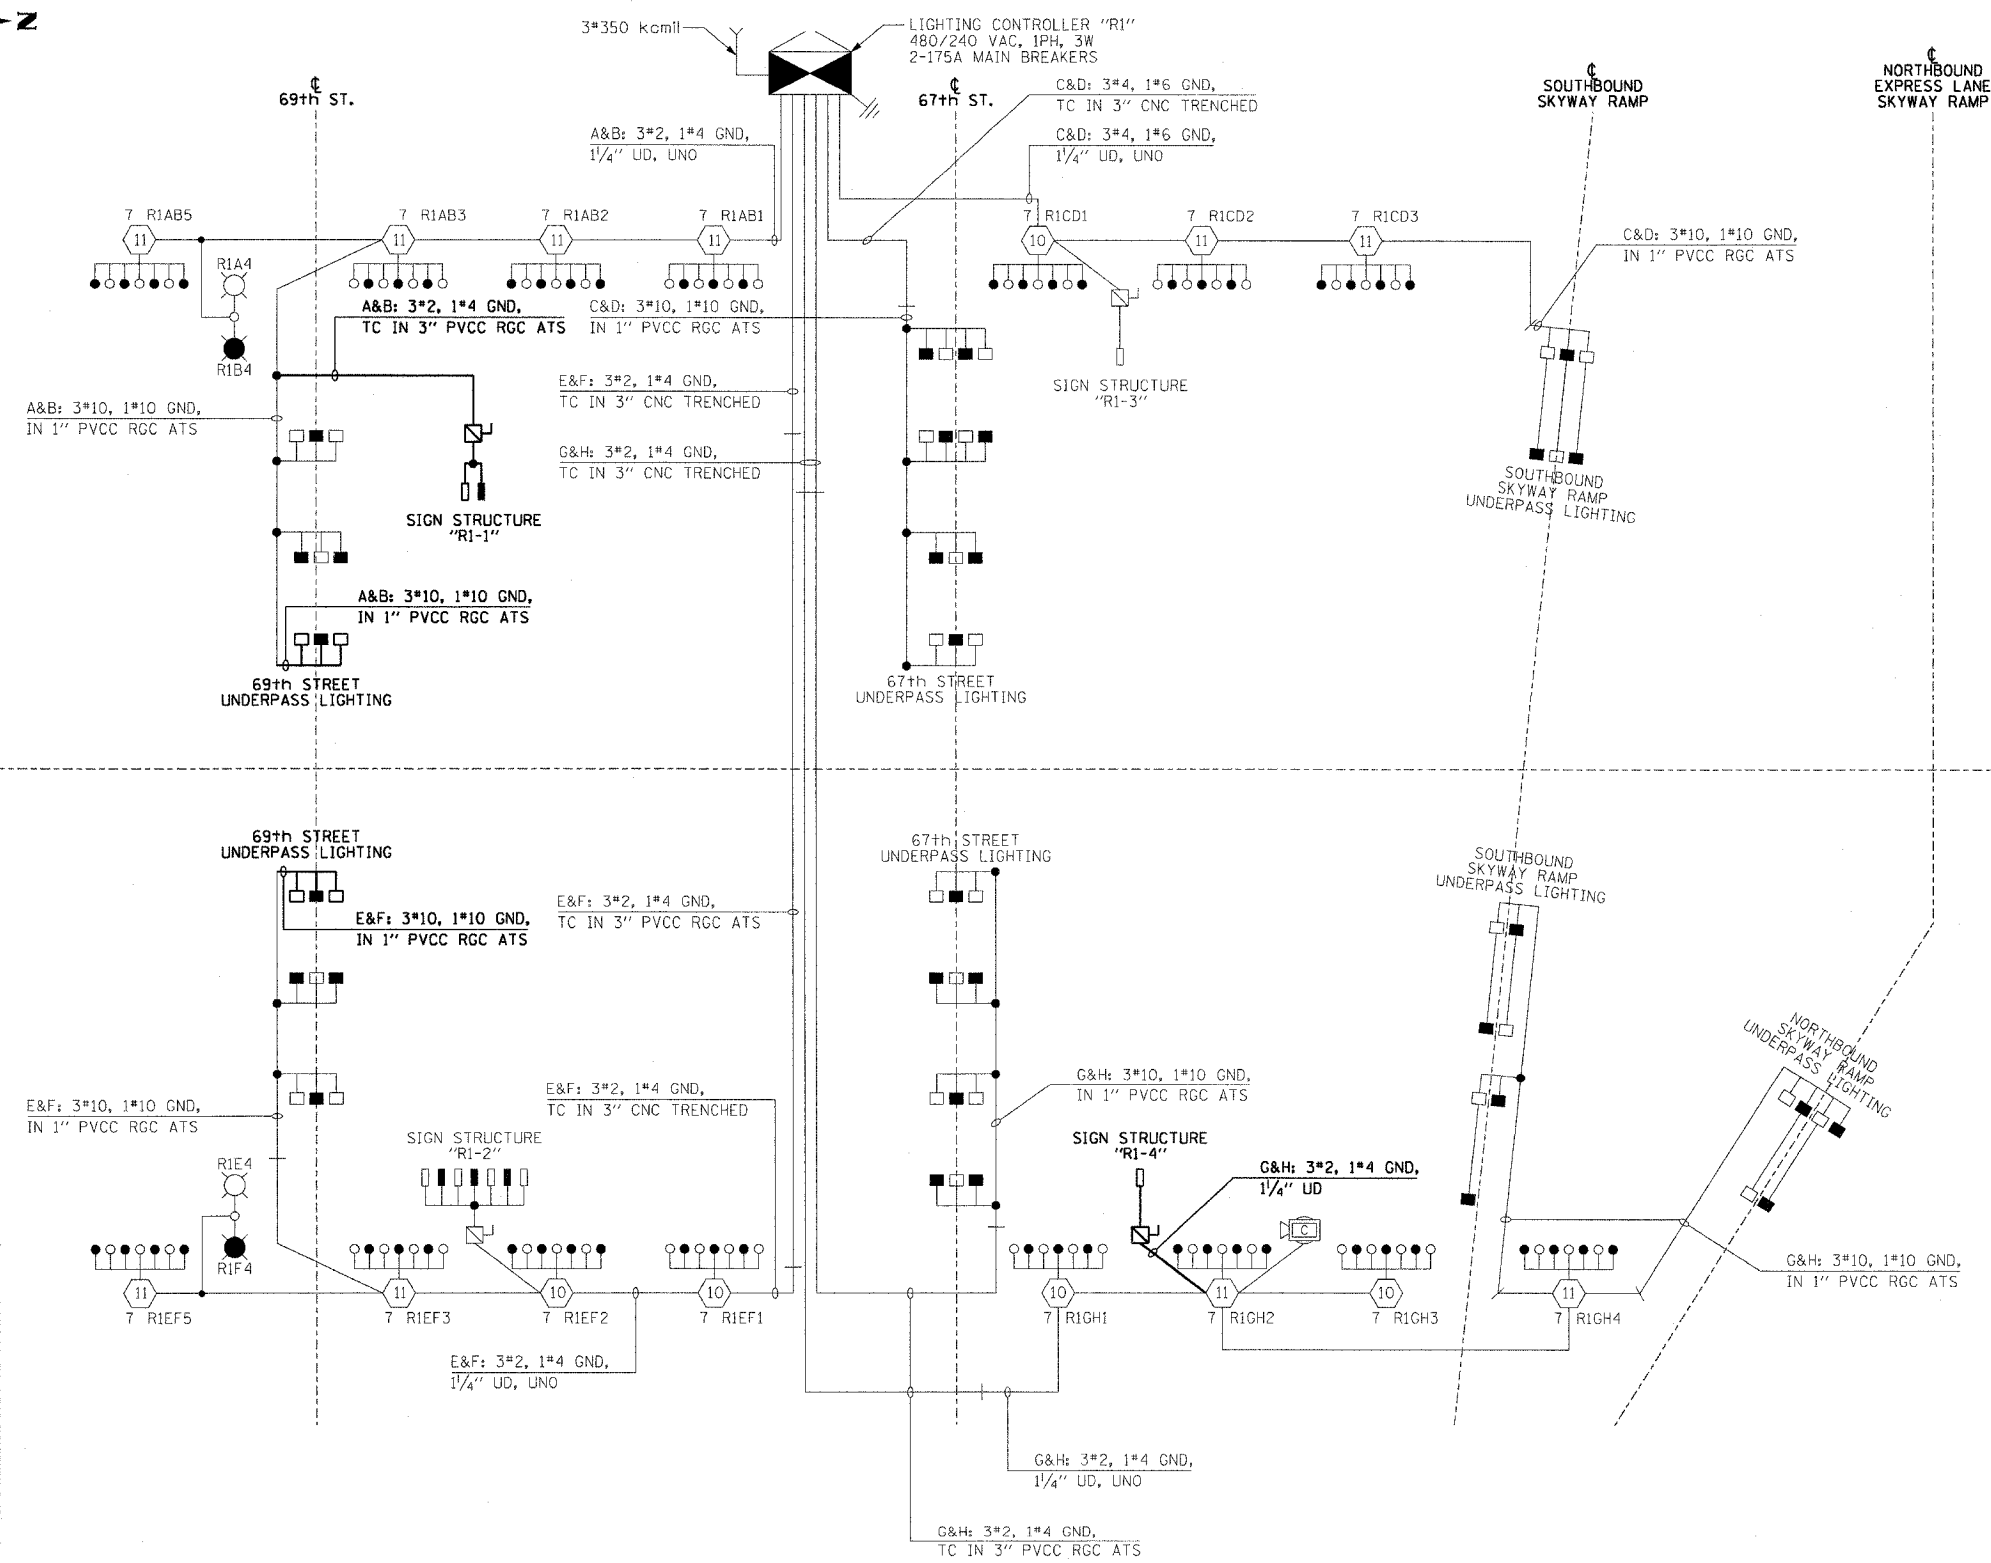

m:\p\40468\elect\16-entr\2b\slr\contract\2\2007\slr\20062a\_01.sfr 10/15/2004 07:28:28 PM