


SECTION	COUNTY	TOTAL SHEETS	SHEET NO.
2003-0311	COOK	976	681
STA. 1230+00 TO STA. 1243+00			
FED. ROAD DIST. NO.	ILLINOIS	FED. AID PROJECT	
62583			

P:\030009\0311\15\road\cctv\020928.dwg

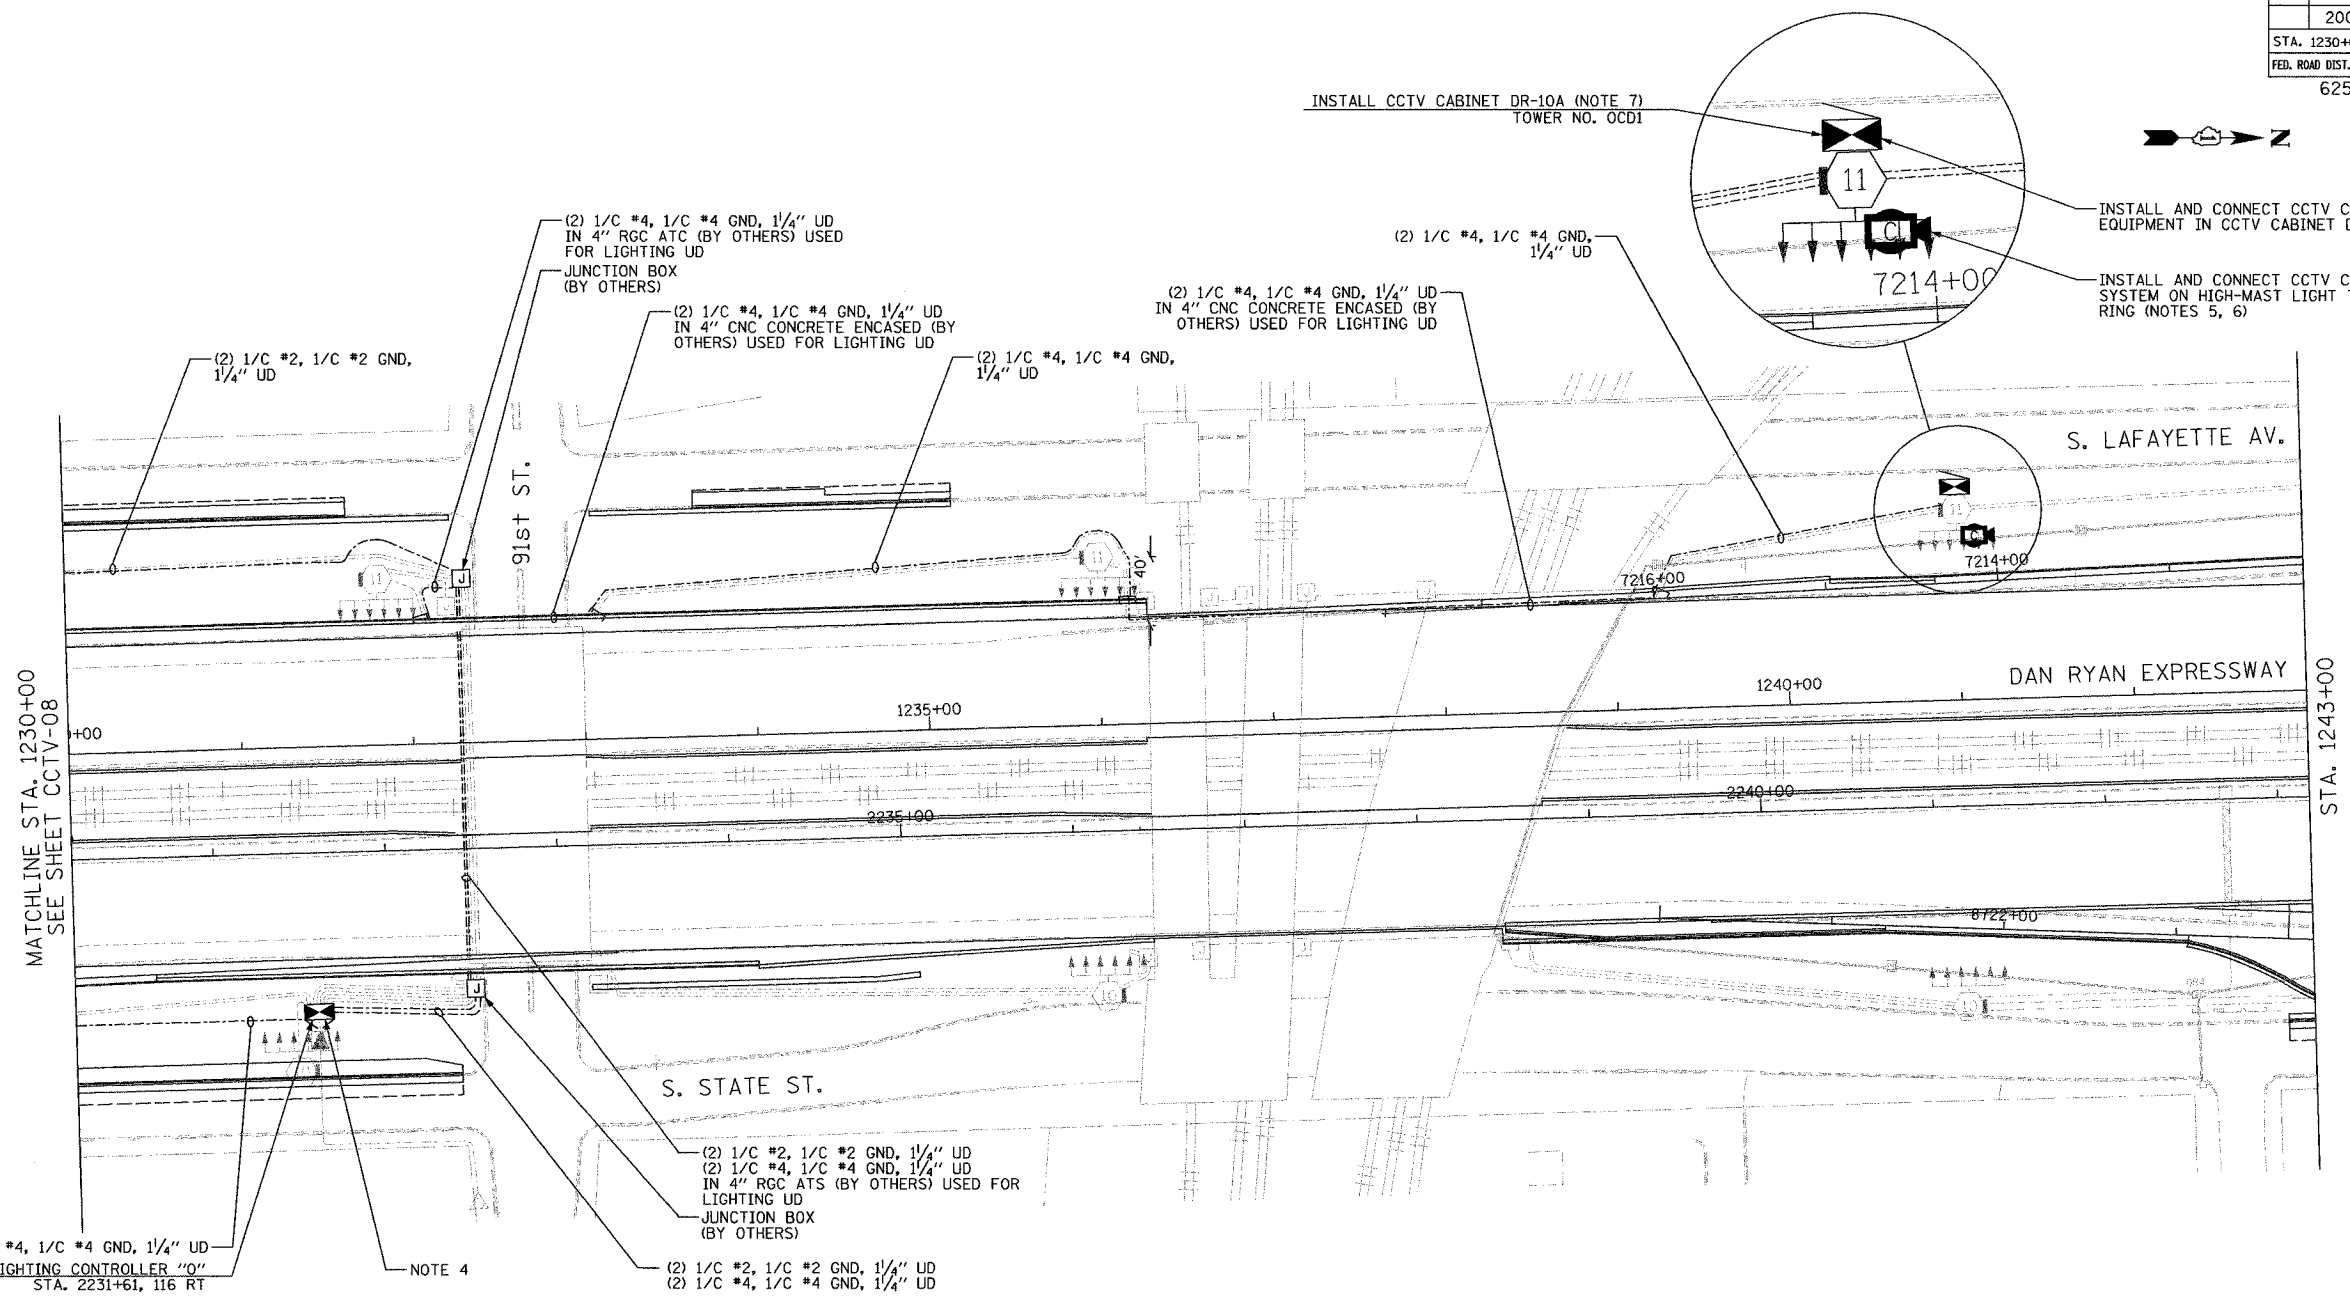


(2) 1/C #4, 1/C #4 GND, 1/4" UD
PROPOSED IDOT LIGHTING CONTROLLER "O"
STA. 2231+61, 116 RT

NOTE 4

(2) 1/C #2, 1/C #2 GND, 1/4" UD
(2) 1/C #4, 1/C #4 GND, 1/4" UD
IN 4" RGC ATC (BY OTHERS) USED FOR LIGHTING UD
JUNCTION BOX (BY OTHERS)
(2) 1/C #2, 1/C #2 GND, 1/4" UD
(2) 1/C #4, 1/C #4 GND, 1/4" UD

NOTES:

 - SEE DRAWINGS ME-01 AND ME-02 FOR ELECTRICAL SYMBOLS AND ABBREVIATIONS.
- UNLESS OTHERWISE STATED, ALL NOTED CABLE AND CONDUIT TO BE FURNISHED AND INSTALLED UNDER THIS CONTRACT.
- THIS SHEET ONLY DEPICTS INSTALLATION OF CLOSED CIRCUIT TELEVISION ELEMENTS. SEE LIGHTING PLANS FOR LIGHTING ELEMENT INSTALLATION.
- CONTRACTOR SHALL CONNECT CAMERA POWER FEED TO THE AUXILIARY BREAKER IN THE LIGHTING CONTROLLER CABINET AS SHOWN ON DRAWING ME-19.
- SUPPORT ARM OF THE CCTV DOME CAMERA SHALL BE INSTALLED ON THE EXPRESSWAY SIDE OF THE HIGH-MAST LIGHT TOWER RING AS SHOWN ON DETAIL DRAWING DT-17. THE ARM SHALL BE PERPENDICULAR TO BOTH THE HIGH-MAST LIGHTING RING AND THE CENTERLINE OF THE EXPRESSWAY OR AS DIRECTED BY THE ENGINEER.
- SEE DRAWING COMM-12 FOR CCTV COMMUNICATIONS SYSTEM CONDUIT AND CABLE LAYOUT.
- SEE DRAWING DT-17 FOR CCTV CABINET MOUNTING DETAILS ON A HIGH-MAST LIGHT TOWER.



CCTV-09

Edwards AND Kelcey
ONE NORTH FRANKLIN
CHICAGO, IL 60606
PHONE: (312) 251-3000
FAX: (312) 251-3015
WEB: WWW.EKCORP.COM

REVISIONS	
NAME	DATE

ILLINOIS DEPARTMENT OF TRANSPORTATION
F.A.I. 94/90 (DAN RYAN EXPRESSWAY)
31st STREET to I-57
CLOSED CIRCUIT TELEVISION
SITE LAYOUT
CAMERA DR-10A, DR-11 (SHEET 4 OF 4)
CAMERA DR-10C (SHEET 3 OF 3)
CAMERA DR-10B (SHEET 2 OF 2)
SCALE: 1"=50'
DATE: October 29, 2004
DRAWN BY: DHI
CHECKED BY: MJL

11/19/2004 04:40:44 PM