 

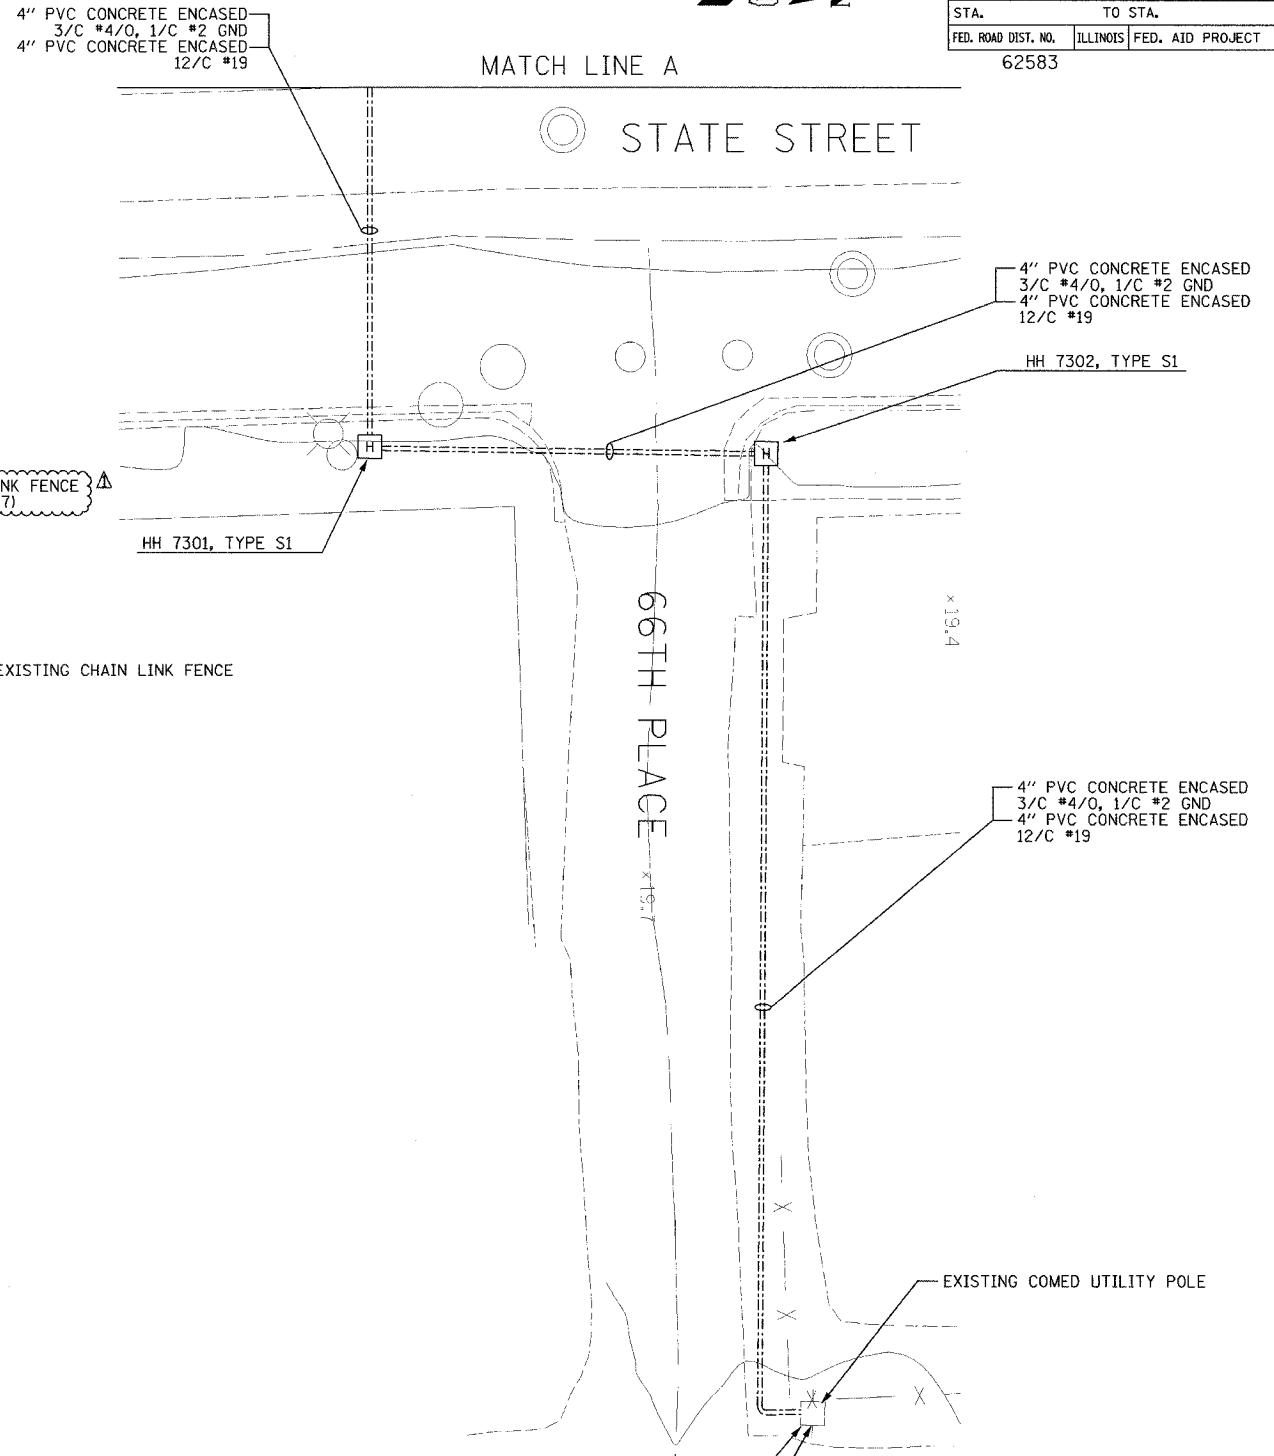


SECTION	COUNTY	TOTAL SHEETS	SHEET NO.
2003-03II	COOK	976	841
STA.	TO STA.		
FED. ROAD DIST. NO.	ILLINOIS	FED. AID PROJECT	
62583			

 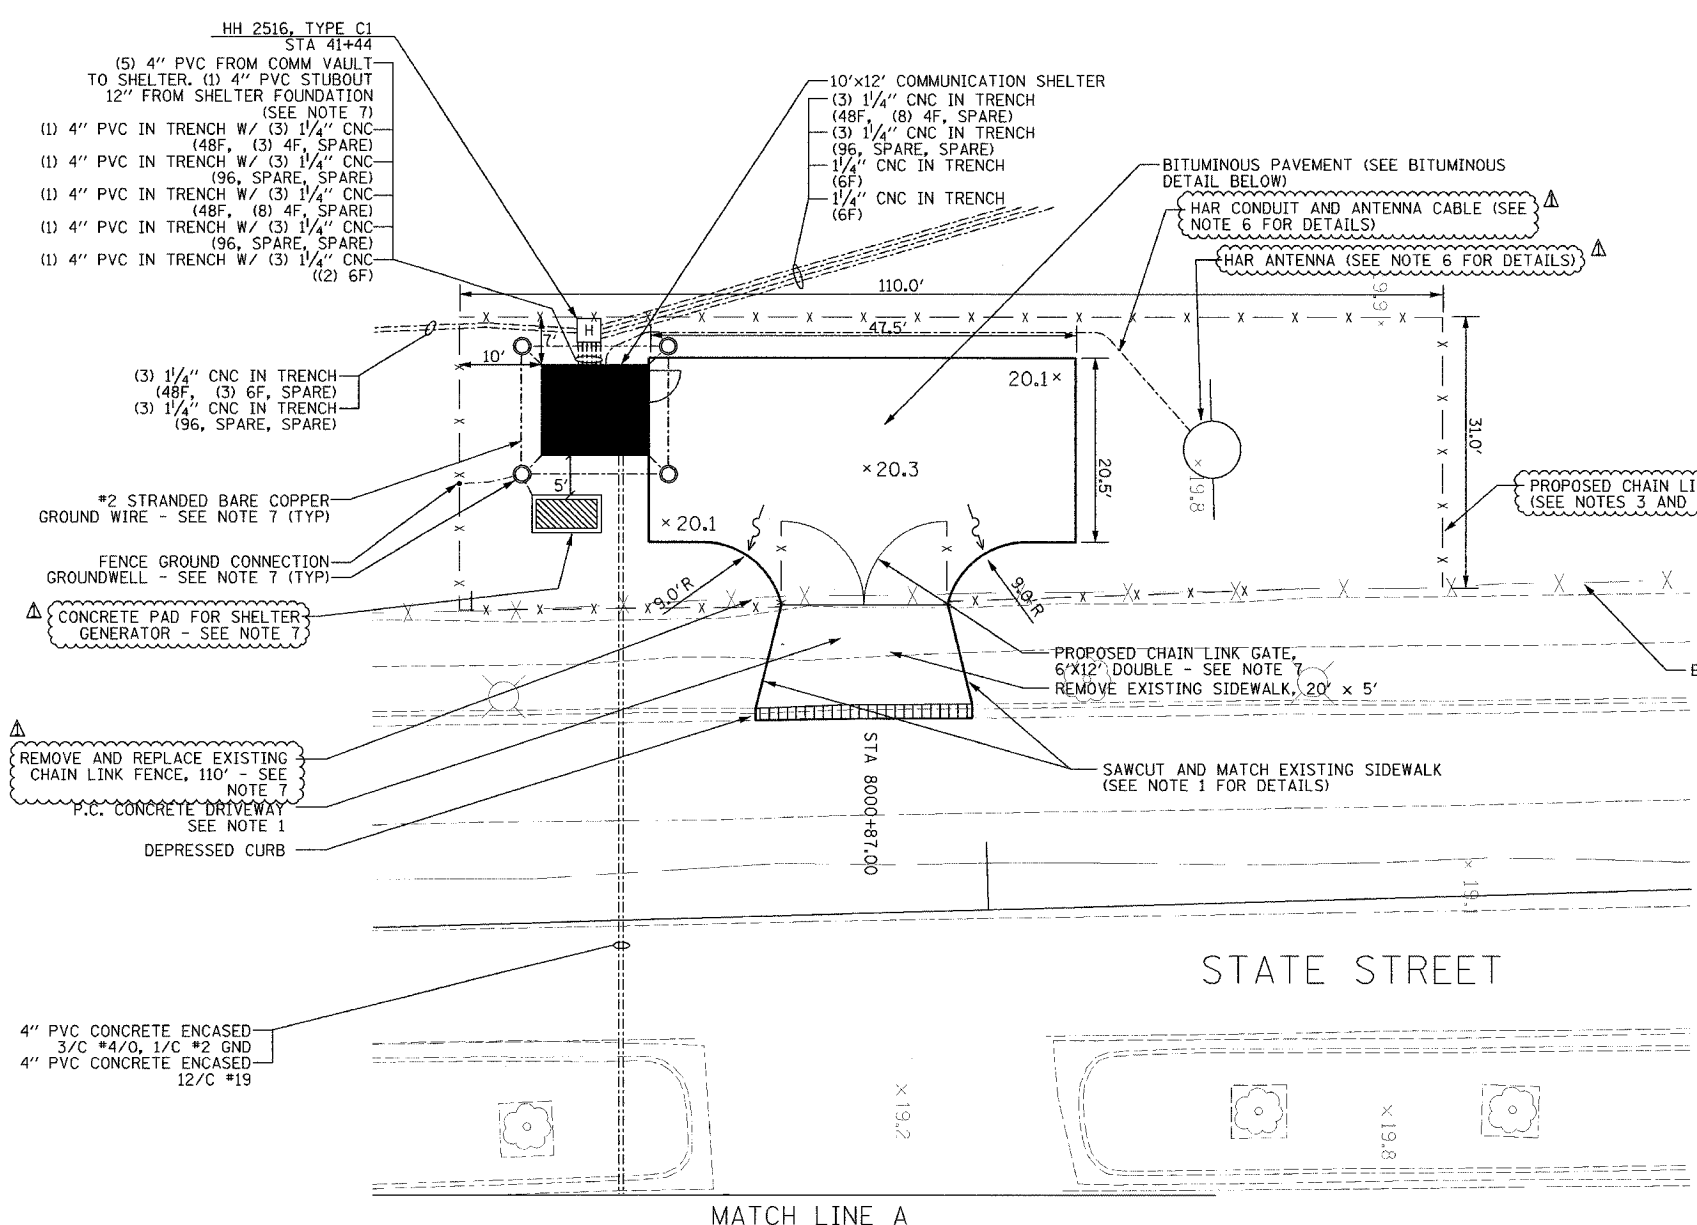


**LEGEND**

×	20.50	EXISTING GRADES
×	20.50	PROPOSED GRADES

- NOTES:**
- FOR P.C. CONCRETE DRIVEWAY, REFER TO CDOT DETAIL SHEET BD17.
  - CENTERLINE OF PROPOSED DRIVEWAY TO ALIGN WITH CENTER LINE OF 66TH PLACE.
  - FOR COMMUNICATIONS SHELTER DETAILS, REFER TO SHEETS COMM-91 THRU COMM-94.
  - CONTRACTOR IS RESPONSIBLE FOR IDENTIFYING AND RELOCATING ALL EXISTING UNDERGROUND UTILITIES AS NECESSARY TO CONSTRUCT COMMUNICATIONS SHELTER.
  - FOR ELECTRIC SERVICE INSTALLATION DETAILS, SEE ESD-01.
  - FOR HIGHWAY ADVISOR RADIO TRANSMITTER PLANS, SEE SHEETS HAR-01 THRU HAR-03.
  - DESIGNATED WORK/MATERIALS TO BE PAID FOR AS PART OF SHELTER.
  - PAVEMENT AND SIDEWALK REPLACEMENT SHALL BE CONSIDERED INCLUDED IN THE COST OF THE CONCRETE ENCASED CONDUIT INSTALLATION.
  - ALL WORK ASSOCIATED WITH THE INSTALLATION OF THE SHELTER UTILITY SERVICE FEED MUST BE COORDINATED WITH AND APPROVED BY COMED.
  - ALL MATERIALS AND LABOR FOR THE INSTALLATION OF THE CONCRETE ENCASED DUCTBANK FOR UTILITY SERVICE FEED MUST MEET ALL COMED REQUIREMENTS AND STANDARDS.

ELECTRIC UTILITY SERVICE CONNECTION  
 ELECTRIC SERVICE INSTALLATION, 200A, 120/240V  
 (SEE SHEET COMM-77 & ESD-01 FOR DETAILS)  
 UNDERGROUND TELEPHONE SERVICE INSTALLATION



REVISIONS	
NAME	DATE
REVISION 1	12/17/04
REVISION	2/11/05

ILLINOIS DEPARTMENT OF TRANSPORTATION  
 F.A.I. 94/90 (DAN RYAN EXPRESSWAY)  
 31st STREET to I-57

**EAST SHELTER (R03)  
 SITE PLAN**

SCALE: 1"=10'  
 DATE: October 29, 2004  
 DRAWN BY: DHI  
 CHECKED BY: MJL

**Edwards  
 AND Kelcey**  
 ONE NORTH FRANKLIN  
 CHICAGO, IL 60606  
 PHONE: (312) 251-3000  
 FAX: (312) 251-3015  
 WEB: WWW.EKCORP.COM

P:\0300\0305\17\SCADD\PP020222.SHT 02/09/2005 03:42:10 PM