


F.A.I. RTE. 94/90	SECTION 2003-0311	COUNTY COOK	TOTAL SHEETS 976	SHEET NO. 852
STA. 62583	TO STA.			
ILLINOIS FED. AID PROJECT				

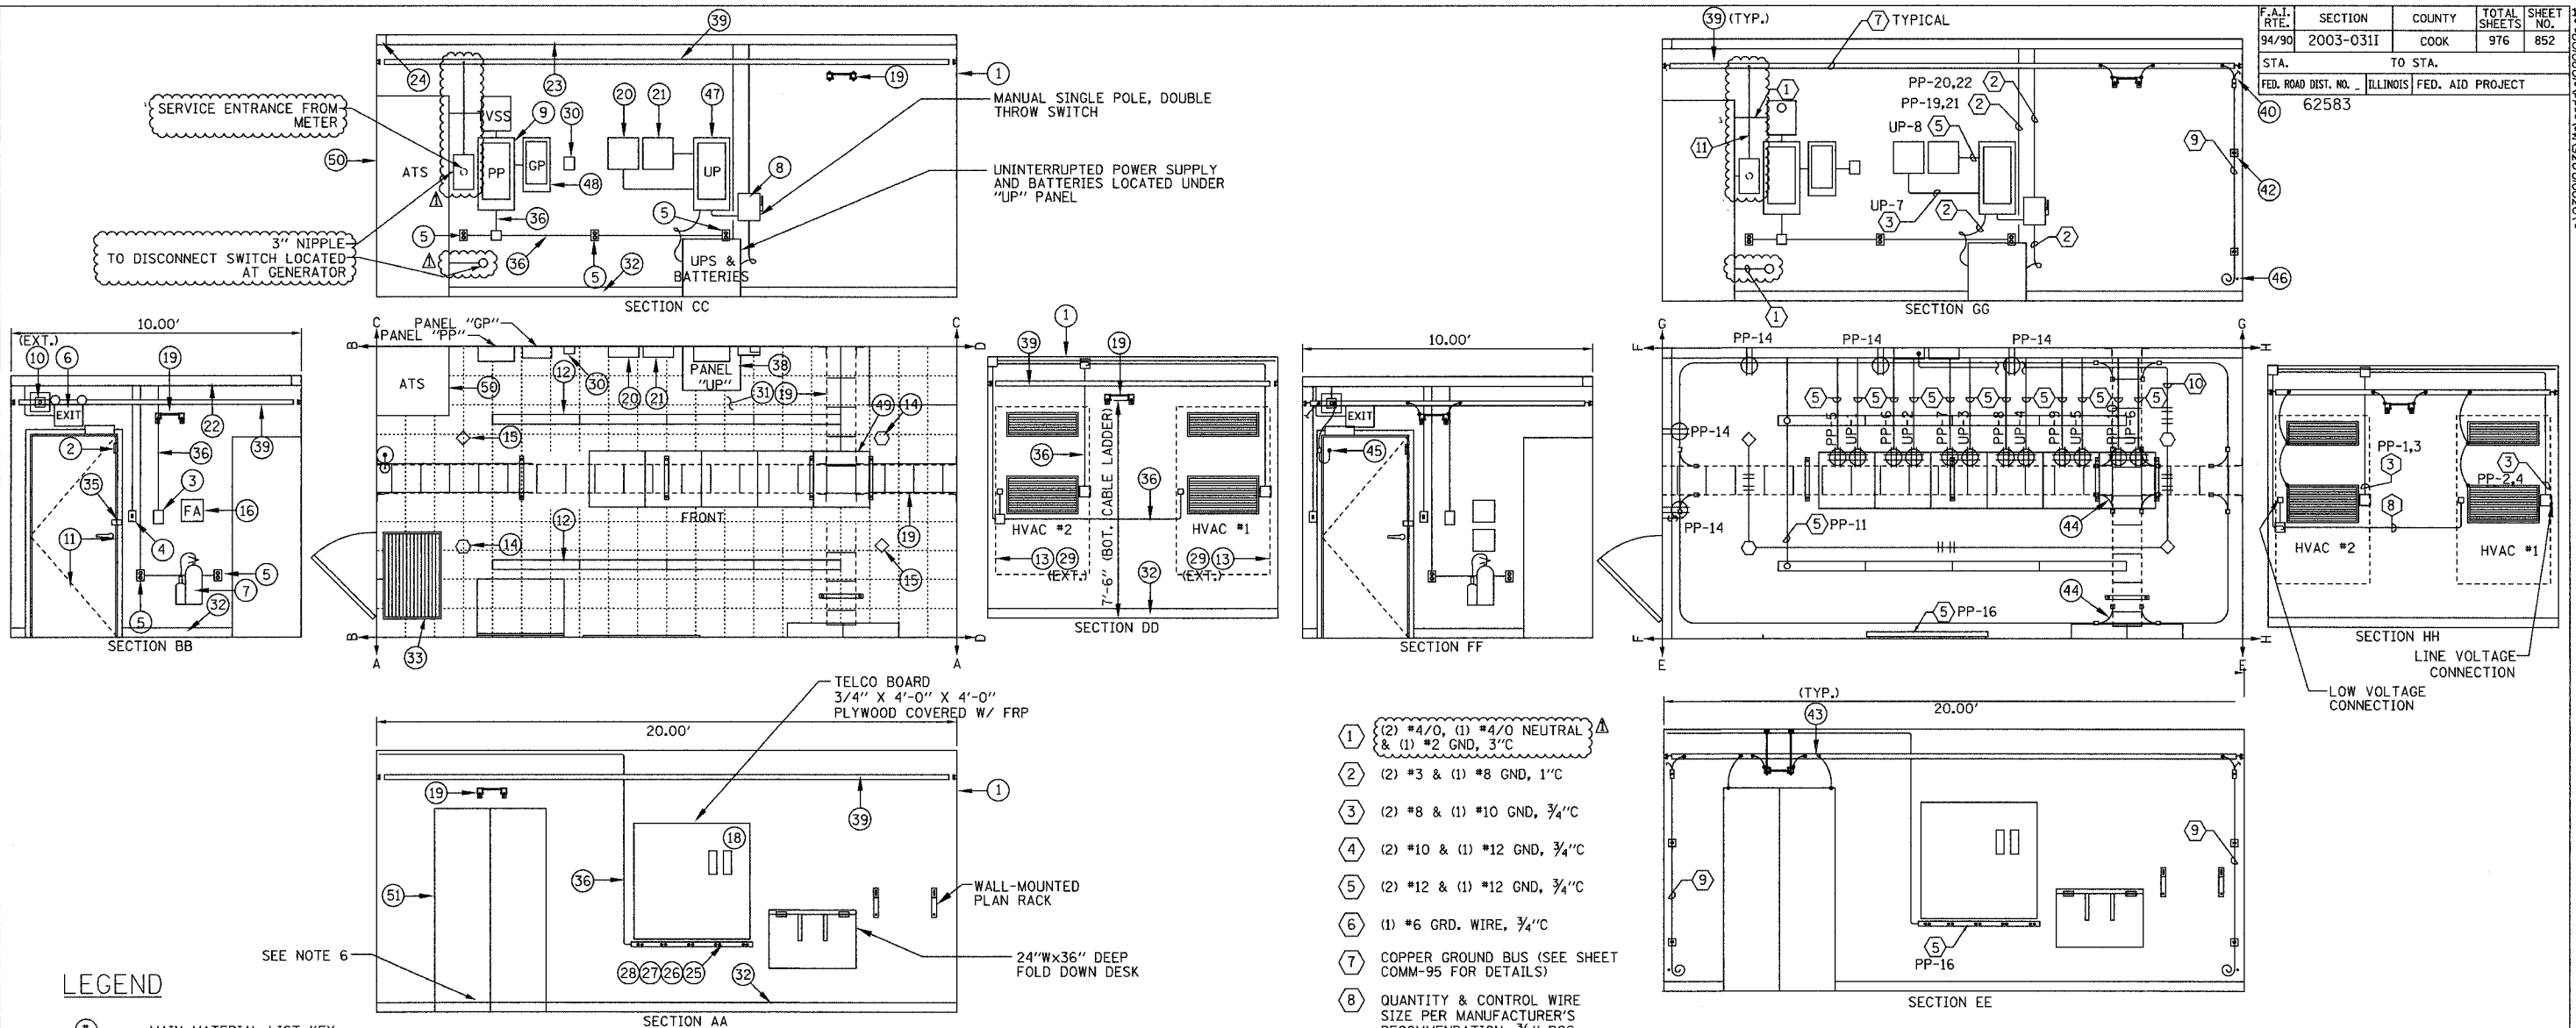

- ① (2) #4/0, (1) #4/0 NEUTRAL & (1) #2 GND, 3\"/>
- ② (2) #3 & (1) #8 GND, 1\"/>
- ③ (2) #8 & (1) #10 GND, 3/4\"/>
- ④ (2) #10 & (1) #12 GND, 3/4\"/>
- ⑤ (2) #12 & (1) #12 GND, 3/4\"/>
- ⑥ (1) #6 GRD. WIRE, 3/4\"/>
- ⑦ COPPER GROUND BUS (SEE SHEET COMM-95 FOR DETAILS)
- ⑧ QUANTITY & CONTROL WIRE SIZE PER MANUFACTURER'S RECOMMENDATION, 3/4\"/>
- ⑨ (1) #8 BARE COPPER GROUND
- ⑩ (2) #22 AWG TWISTED PAIR, 3/4\"/>
- ⑪ (1) #2 GROUND, 1\"/>

- NOTES:**
- CONDUIT AND WIRING IS SHOWN DIAGRAMATIC. ACTUAL LOCATION OF EQUIPMENT AND HARDWARE SHALL BE SHOWN IN SHOP DRAWINGS AND SHALL BE APPROVED BY THE ENGINEER.
 - CONTRACTOR SHALL MAINTAIN MINIMUM 36\"/>
 - ALL CABLE TRAY AND EQUIPMENT SHALL HAVE GROUND WIRE INSTALLED SIZED AS PER ELECTRICAL CODE REQUIREMENTS.
 - SEE SHEETS COMM-121 THRU COMM-126 FOR FIBER OPTIC CABLE PATCHING AND TERMINATION DETAILS.
 - ROUTE ALARM CABLE FROM ALARM OUTPUT DEVICES TO ALARM INPUT PANEL VIA CABLE TRAY. SEE SHEET COMM-88 FOR NUMBER AND TYPE OF ALARM INPUTS.
 - COORDINATE CONDUIT ENTRANCE LOCATIONS AS DETAILED PER SHELTER SITE PLAN COMM-85.
 - SEE COMMUNICATION DRAWINGS SHEET COMM-90 FOR EQUIPMENT RACK LAYOUT.

LEGEND

- ⊙ MAIN MATERIAL LIST KEY
- ⊕ ELECETRICAL NOTES KEY
- ◇ PHOTOELECTRIC DETECTOR
- IONIZATION DETECTOR
- ⊞ JUNCTION BOX
- ⊥ LIGHT SWITCH
- ⊕ QUAD RECEPTACLE
- ⊕ DUPLEX RECEPTACLE
- FLUORESCENT LIGHT FIXTURE
- CABLE TRAY
- COMMUNICATION EQUIPMENT RACK

ITEM	DESCRIPTION
1	PREFABRICATED 10' W x 12' L x 9' H (INTERIOR DIMENSION) CONCRETE EQUIPMENT SHELTER
2	DOOR INTRUSION SENSOR
3	DUAL HVAC UNIT CONTROLLER
4	SINGLE POLE LIGHT SWITCH
5	DUPLEX RECEPTACLE
6	COMBINED EMERGENCY LIGHT W/ BATTERY BACKUP
7	10 LB. CARBON DIOXIDE FIRE EXTINGUISHER, WALL MOUNTED
8	TWO POLE, DOUBLE THROW DISCONNECT SWITCH, 240 VAC, NEMA 1 ENCLOSURE
9	NORMAL POWER PANEL "PP", 120/240 VAC, 3W, 225 AMP PANEL
10	35W HIGH PRESSURE SODIUM, VANDAL RESISTANT EXTERIOR MOUNTED FLOODLIGHT, WITH PHOTOCELL
11	36" x 80" INSULATED HOLLOW METAL CORE DOOR AND FRAME
12	FLUORESCENT LIGHT, 2 LAMPS 30 WATTS EACH, 120 VOLT
13	AIR CONDITIONING UNIT W/ GRILLS
14	CEILING MOUNTED SMOKE DETECTOR (IONIZATION TYPE)
15	CEILING MOUNTED SMOKE DETECTOR (PHOTOELECTRIC TYPE)
16	FIRST AID KIT
17	(NOT USED)
18	85 ALARM BLOCKS, MODULE 50M - 1500W W/ 2 R66M 50 BLOCKS AND BLOCK COVERS
19	12" CABLE TRAY (SEE SHEET COMM-95 FOR DETAILS)
20	FIRE ALARM PANEL
21	ALARM I/O MODULE
22	4" x 4" x 10" WIREWAY
23	4" x 4" x 20" WIREWAY
24	4" x R" CORNER PIECE
25	6" RECEPTACLE STRIP W/ OUTLETS EVERY 1'
26	CONDUIT ADAPTER

ITEM	DESCRIPTION
27	ELBOW ADAPTER
28	END CAP
29	VANDAL PROOF CAGE FOR HVAC
30	REMOTE ANNUNCIATOR MODULE (PRE-PURCHASED)
31	FLOOR TILES - 1/2" x 12" x 12" COMMERCIAL TILE
32	BASE FINISH, 4" BLACK BASE COVER MOLD 10' x 12' SHELTER
33	24" x 36" RUBBER MAT
34	INSULATION MATERIAL FOR 10' x 20' x 9' FIRE RESISTANT R-19
35	1/2" x 2" x 2" ANGLE PLATES AT EXTERIOR DOOR AND WALL FOR VANDAL PROOF LOCK
36	3/4" CONDUIT
37	3/4" CONDUIT
38	UPS SYSTEM, 10KVA, 240 VAC INPUT, 120 VOLT, 10 OUTPUT (TO PAID FOR AS PART OF SHELTER)
39	INTERIOR COPPER GROUND BUS BAR (SEE SHEET COMM-95 FOR DETAILS)
40	INTERIOR GROUND SYSTEM - GROUND LEAD TO EXTERIOR GROUND SYSTEM
41	INTERIOR GROUND SYSTEM - NON-DIRECTIONAL SPLICE
42	INTERIOR GROUND SYSTEM - GROUND WALL SUPPORT
43	INTERIOR GROUND SYSTEM - GROUND BUS GROUND TAP
44	INTERIOR GROUND SYSTEM - CABLE LADDER BOND
45	INTERIOR GROUND SYSTEM - DOOR BONDING STRIP
46	INTERIOR GROUND SYSTEM - PVC 45° NIPPLE
47	UPS PANEL "UP", 120/240VAC, 2W, 100 AMP PANEL
48	STANDBY GENERAL PANEL "GP"
49	EQUIPMENT RACK (PAID FOR AS PART OF CCTV DISTRIBUTION SUBSYSTEM)
50	AUTOMATIC TRANSFER SWITCH (ATS)
51	WALL MOUNTED FIBER OPTIC TERMINATION PANEL

REVISIONS	
NAME	DATE
REVISION 1	12/17/04

ILLINOIS DEPARTMENT OF TRANSPORTATION
 F.A.I. 94/90 (DAN RYAN EXPRESSWAY)
 31st STREET to I-57

I-55 SHELTER (R01)
 EQUIPMENT AND ELECTRICAL LAYOUT

SCALE: NOT TO SCALE
 DATE: October 29, 2004
 DRAWN BY: JM
 CHECKED BY: CS

Edwards AND Kelcey
 ONE NORTH FRANKLIN
 CHICAGO, IL 60606
 PHONE: (312) 251-3000
 FAX: (312) 251-3015
 WEB: WWW.EKCORP.COM

PA030009.035\15\0000\020102.epr 12/15/2004 01:51:27 PM