


F.A.I. RTE.	SECTION	COUNTY	TOTAL SHEETS	SHEET NO.
94/90	2003-0311	COOK	976	294
STA.		TO STA.		
62583		ILLINOIS FED. AID PROJECT		

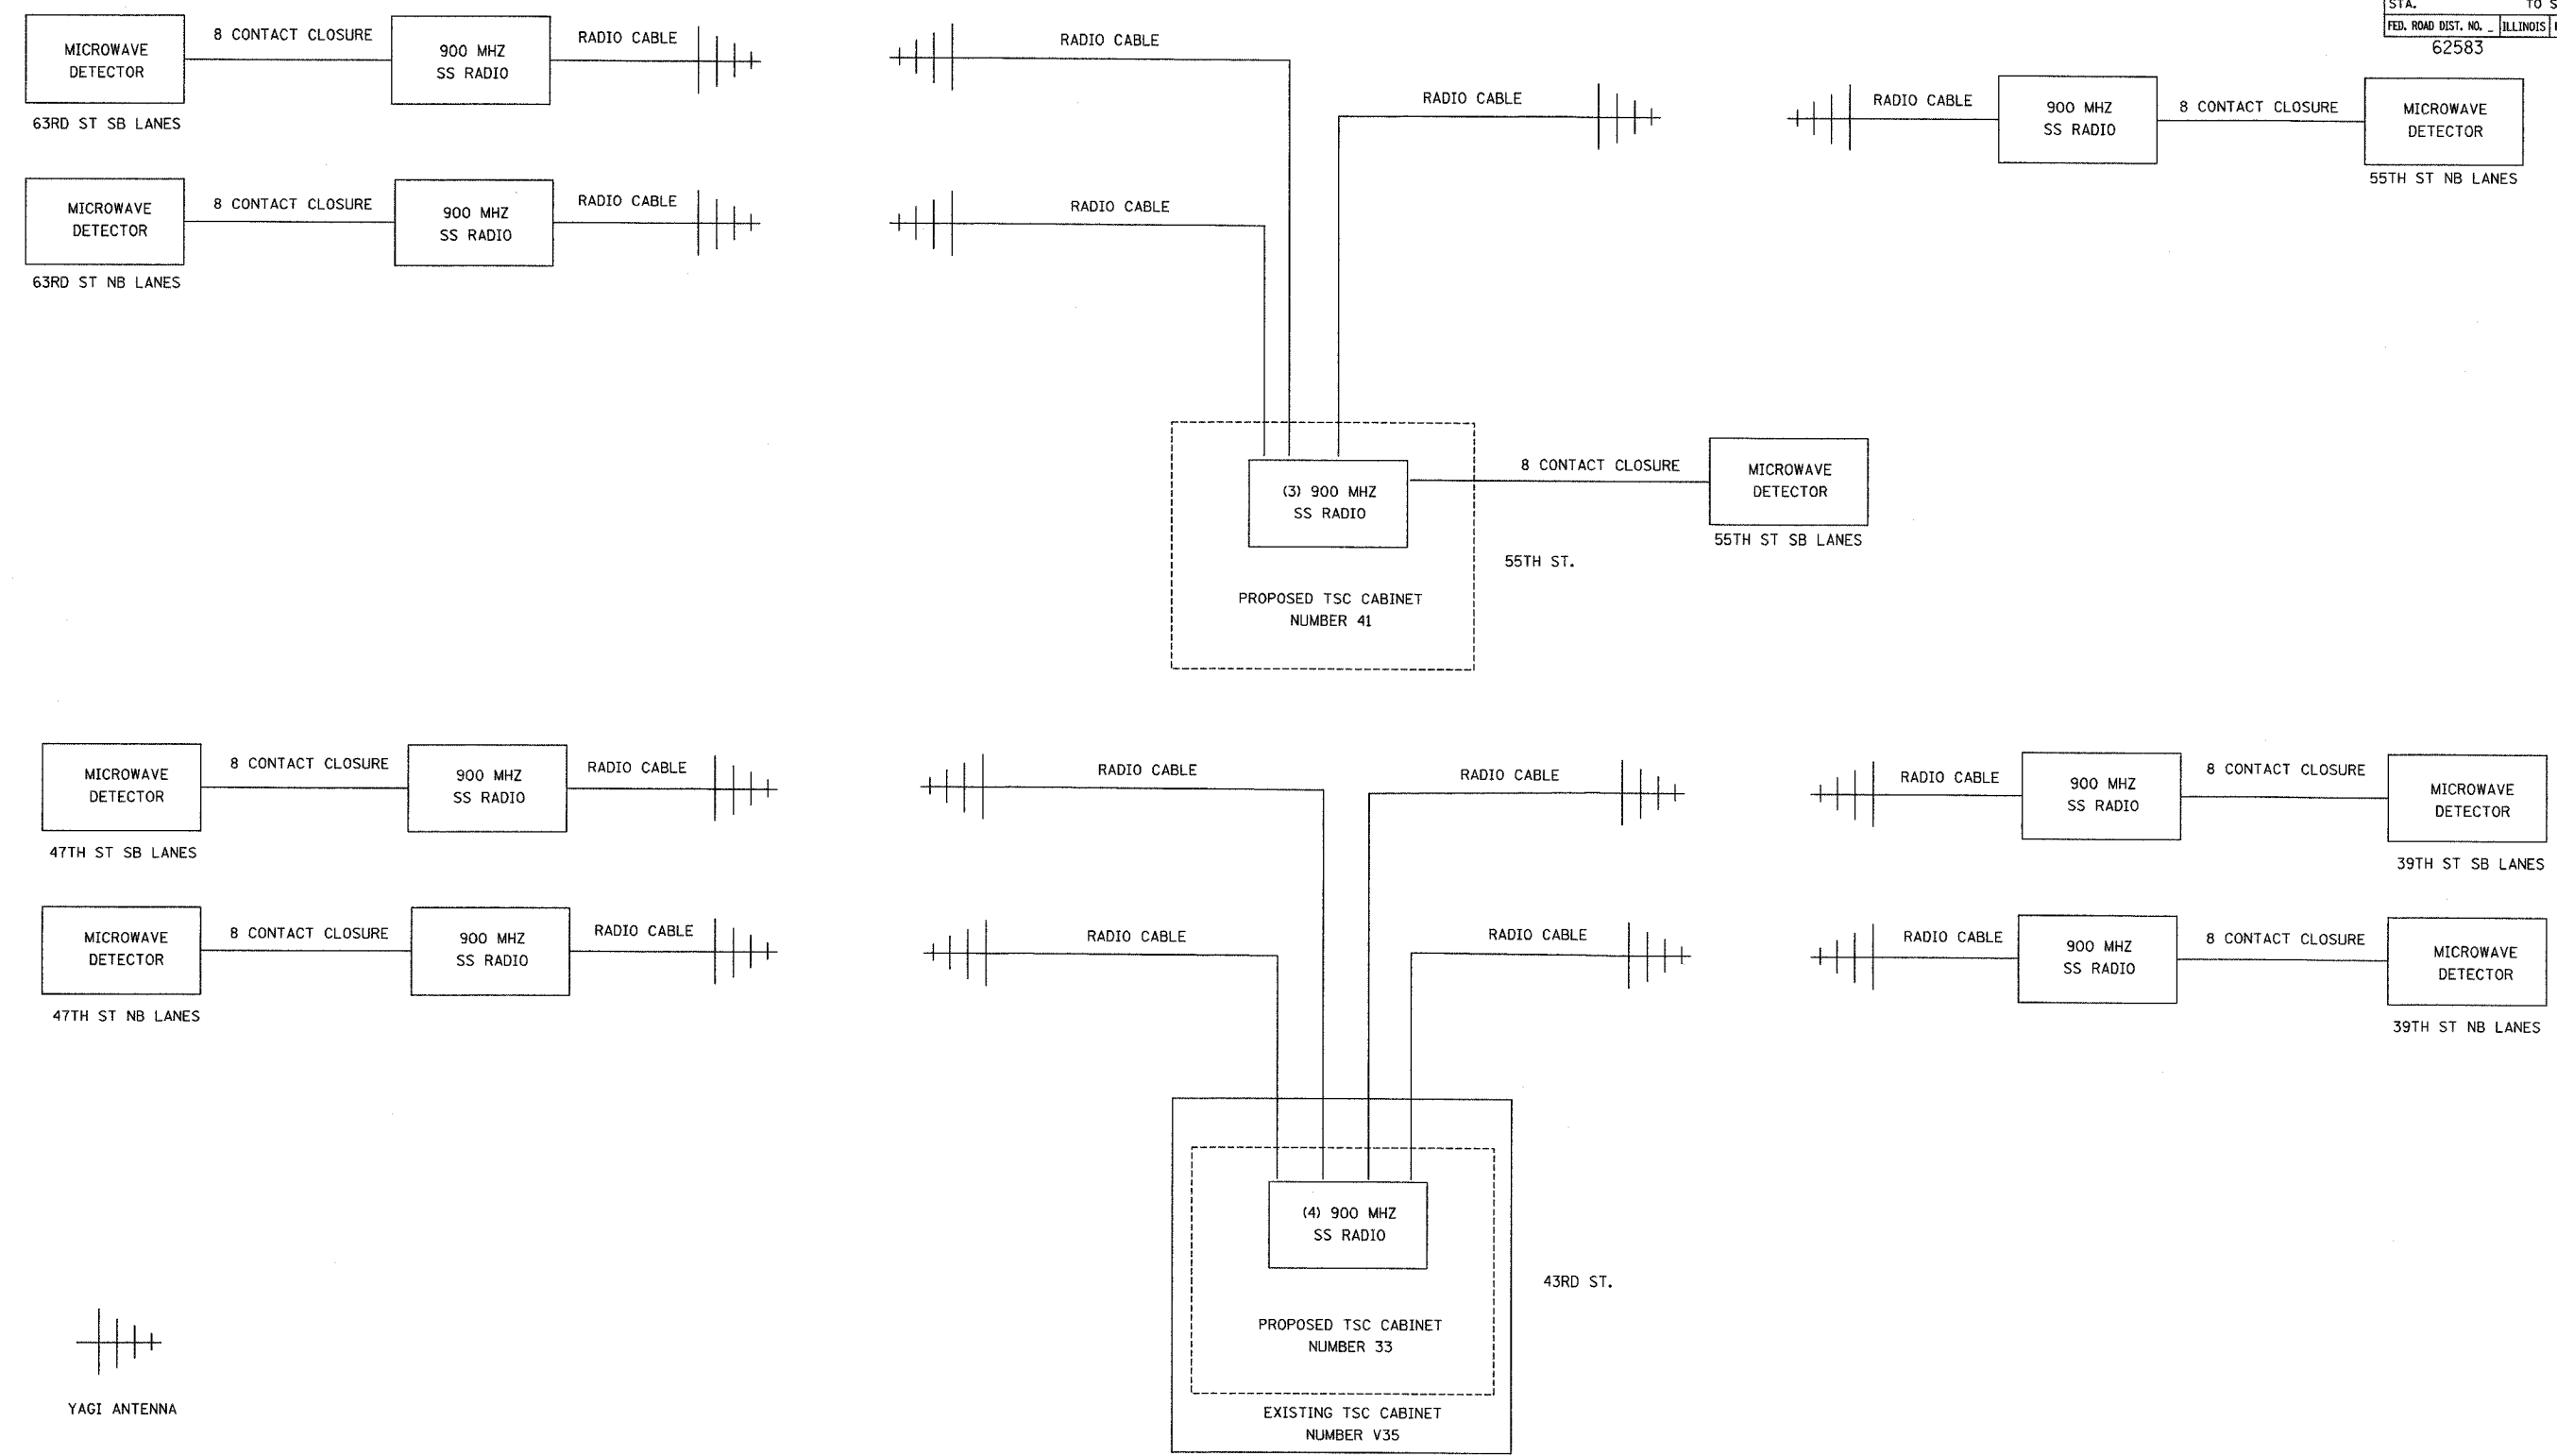

COMM-128

NOTE:  
 1. SEE SHEETS DT-53, DT-54, DT-55 FOR SITE INSTALLATION DETAILS.  
 2. EXISTING TSC CABINETS TO BE UTILIZED UNTIL REMOVAL.

REVISIONS	
NAME	DATE

ILLINOIS DEPARTMENT OF TRANSPORTATION  
 F.A.I. 94/90 (DAN RYAN EXPRESSWAY)  
 31st STREET to I-57  
 TEMPORARY DETECTION  
 COMMUNICATIONS LAYOUT  
 (Sheet 2 of 3)  
 SCALE: N.T.S. DRAWN BY: DHI  
 DATE: October 29, 2004 CHECKED BY: JEZ

**Edwards AND Kelcey**  
 ONE NORTH FRANKLIN  
 CHICAGO, IL 60606  
 PHONE: (312) 251-3000  
 FAX: (312) 251-3015  
 WEB: WWW.EKCORP.COM

10/19/2004 01:49:40 PM