


F.A.I. RTE.	SECTION	COUNTY	TOTAL SHEETS	SHEET NO.
74	(72-7)R-3	PEORIA	1360	1192
STA.	TO STA.			
FED. ROAD DIST. NO.	ILLINOIS	FED. AID PROJECT		

CONTRACT NO. 68200

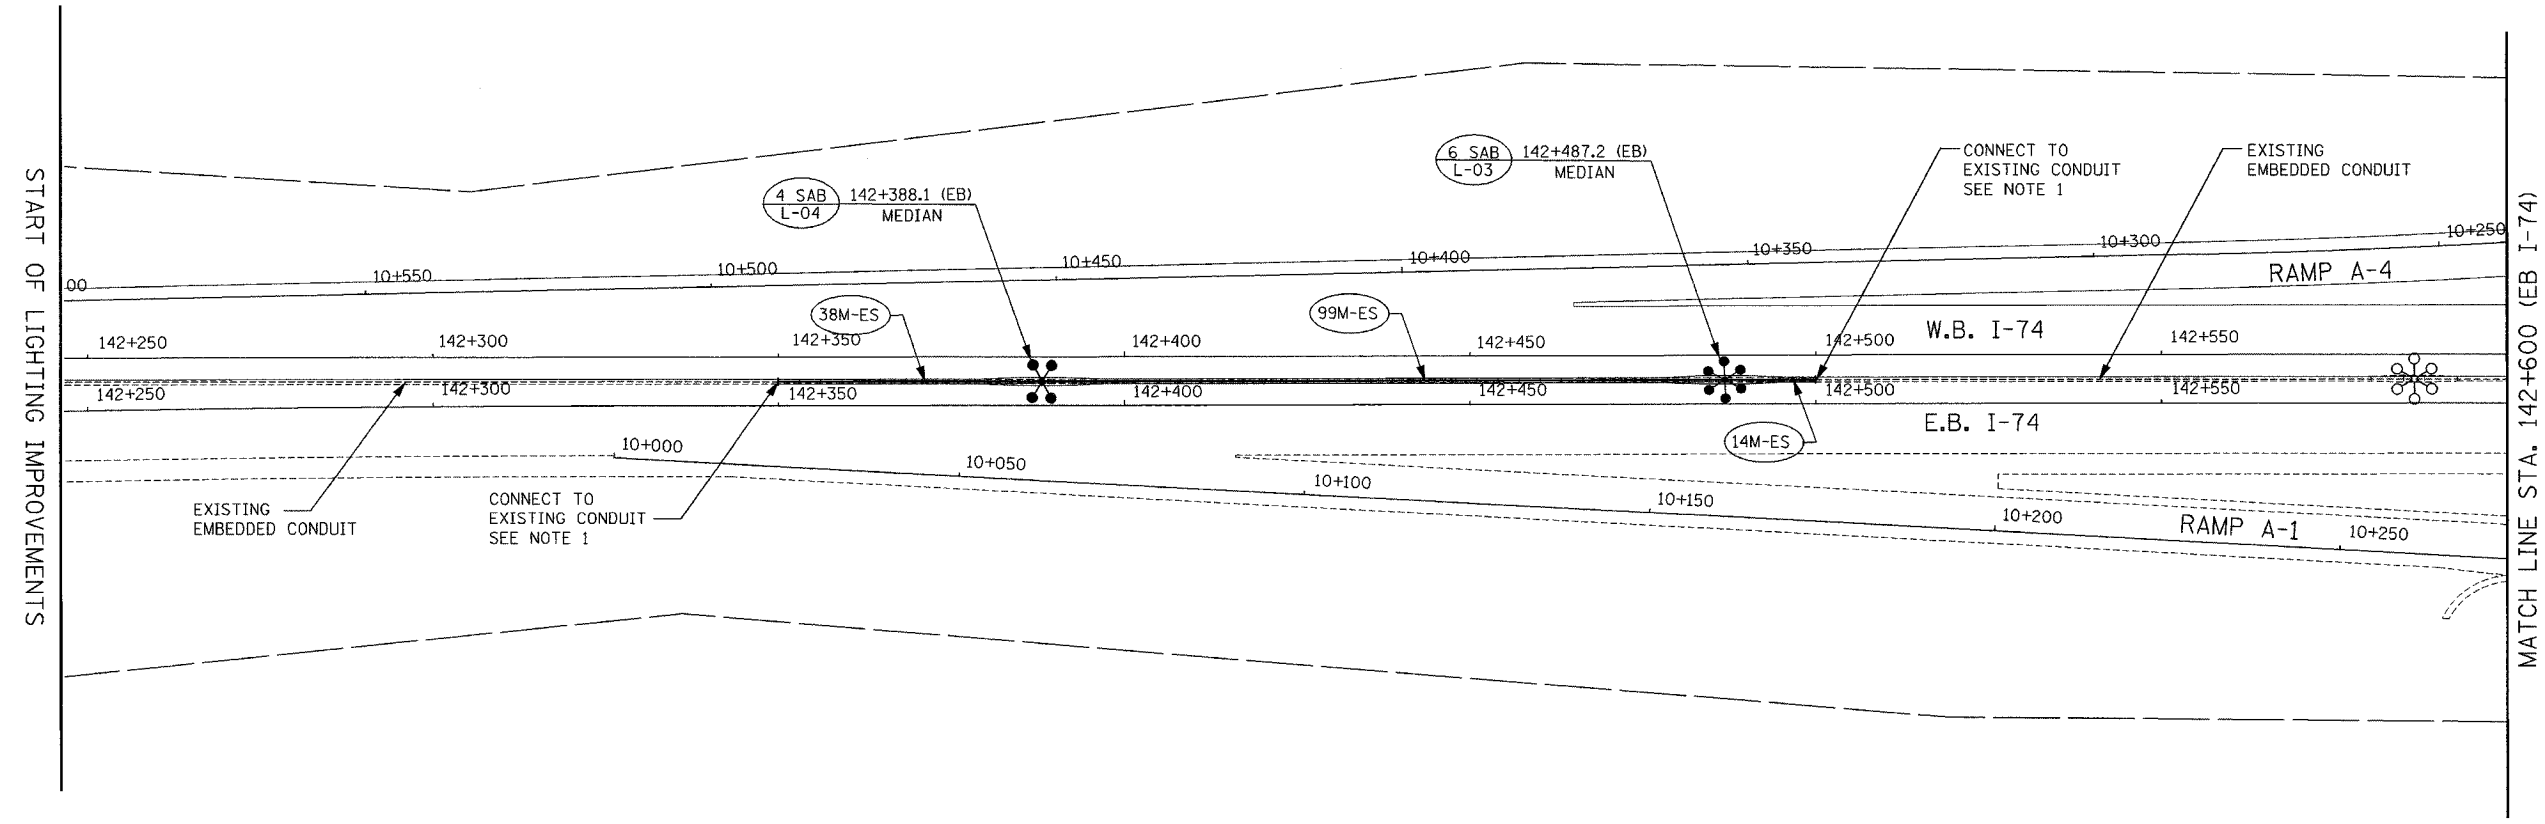

STREET LIGHTING - BILL OF MATERIAL THIS SHEET


PAY ITEM	UNIT	QUANTITY
CONDUIT EMBEDDED IN STRUCTURE, 75MM DIA. PVC	METER	151.0
LIGHT TOWER FOUNDATION (SPECIAL)	METER	12.5
HIGH MAST LUMINAIRE, (INSTALL ONLY)	EACH	10
LIGHT TOWER, INSTALL ONLY	EACH	2

LENGTH IN METERS

- ES: EMBEDDED IN STRUCTURE
- T: TRENCH
- P: PUSHED
- CT: COMMON TRENCH
- CTT: COMMON TRENCH WITH TRAFFIC SIGNAL CONDUIT (TRENCH AND BACKFILL BY TRAFFIC SIGNAL CONTRACTOR)

PROPOSED CONDUIT CALL-OUT

 NOTE:
1. USE CONDUIT COUPLING TO CONNECT PROPOSED CONDUIT TO EXISTING CONDUIT. COST OF CONNECTION SHALL BE INCLUDED IN "CONDUIT EMBEDDED IN STRUCTURE, 75mm DIA. PVC" PAY ITEM.



ab **alfred benesch & company**
CONSULTING ENGINEERS
205 NORTH MICHIGAN AVENUE, CHICAGO, ILLINOIS 60601

REVISIONS	
NAME	DATE

ILLINOIS DEPARTMENT OF TRANSPORTATION
PROPOSED LIGHTING PLAN
I-74
STA. 142+250 TO STA. 142+600
DRAWN BY DJK
CHECKED BY MKR
DATE: 11/12/04

m:\p\proj\3573\UG\LIGHTING\4-Contract\01\1001-74r4.dgn

10:37:28 AM

11/15/2004