


F.A.I. RTE.	SECTION	COUNTY	TOTAL SHEETS	SHEET NO.
74	(72-7R-3)	PEORIA	1360	1193
STA.	TO STA.			
FED. ROAD DIST. NO.	ILLINOIS	FED. AID PROJECT		

CONTRACT NO. 68200

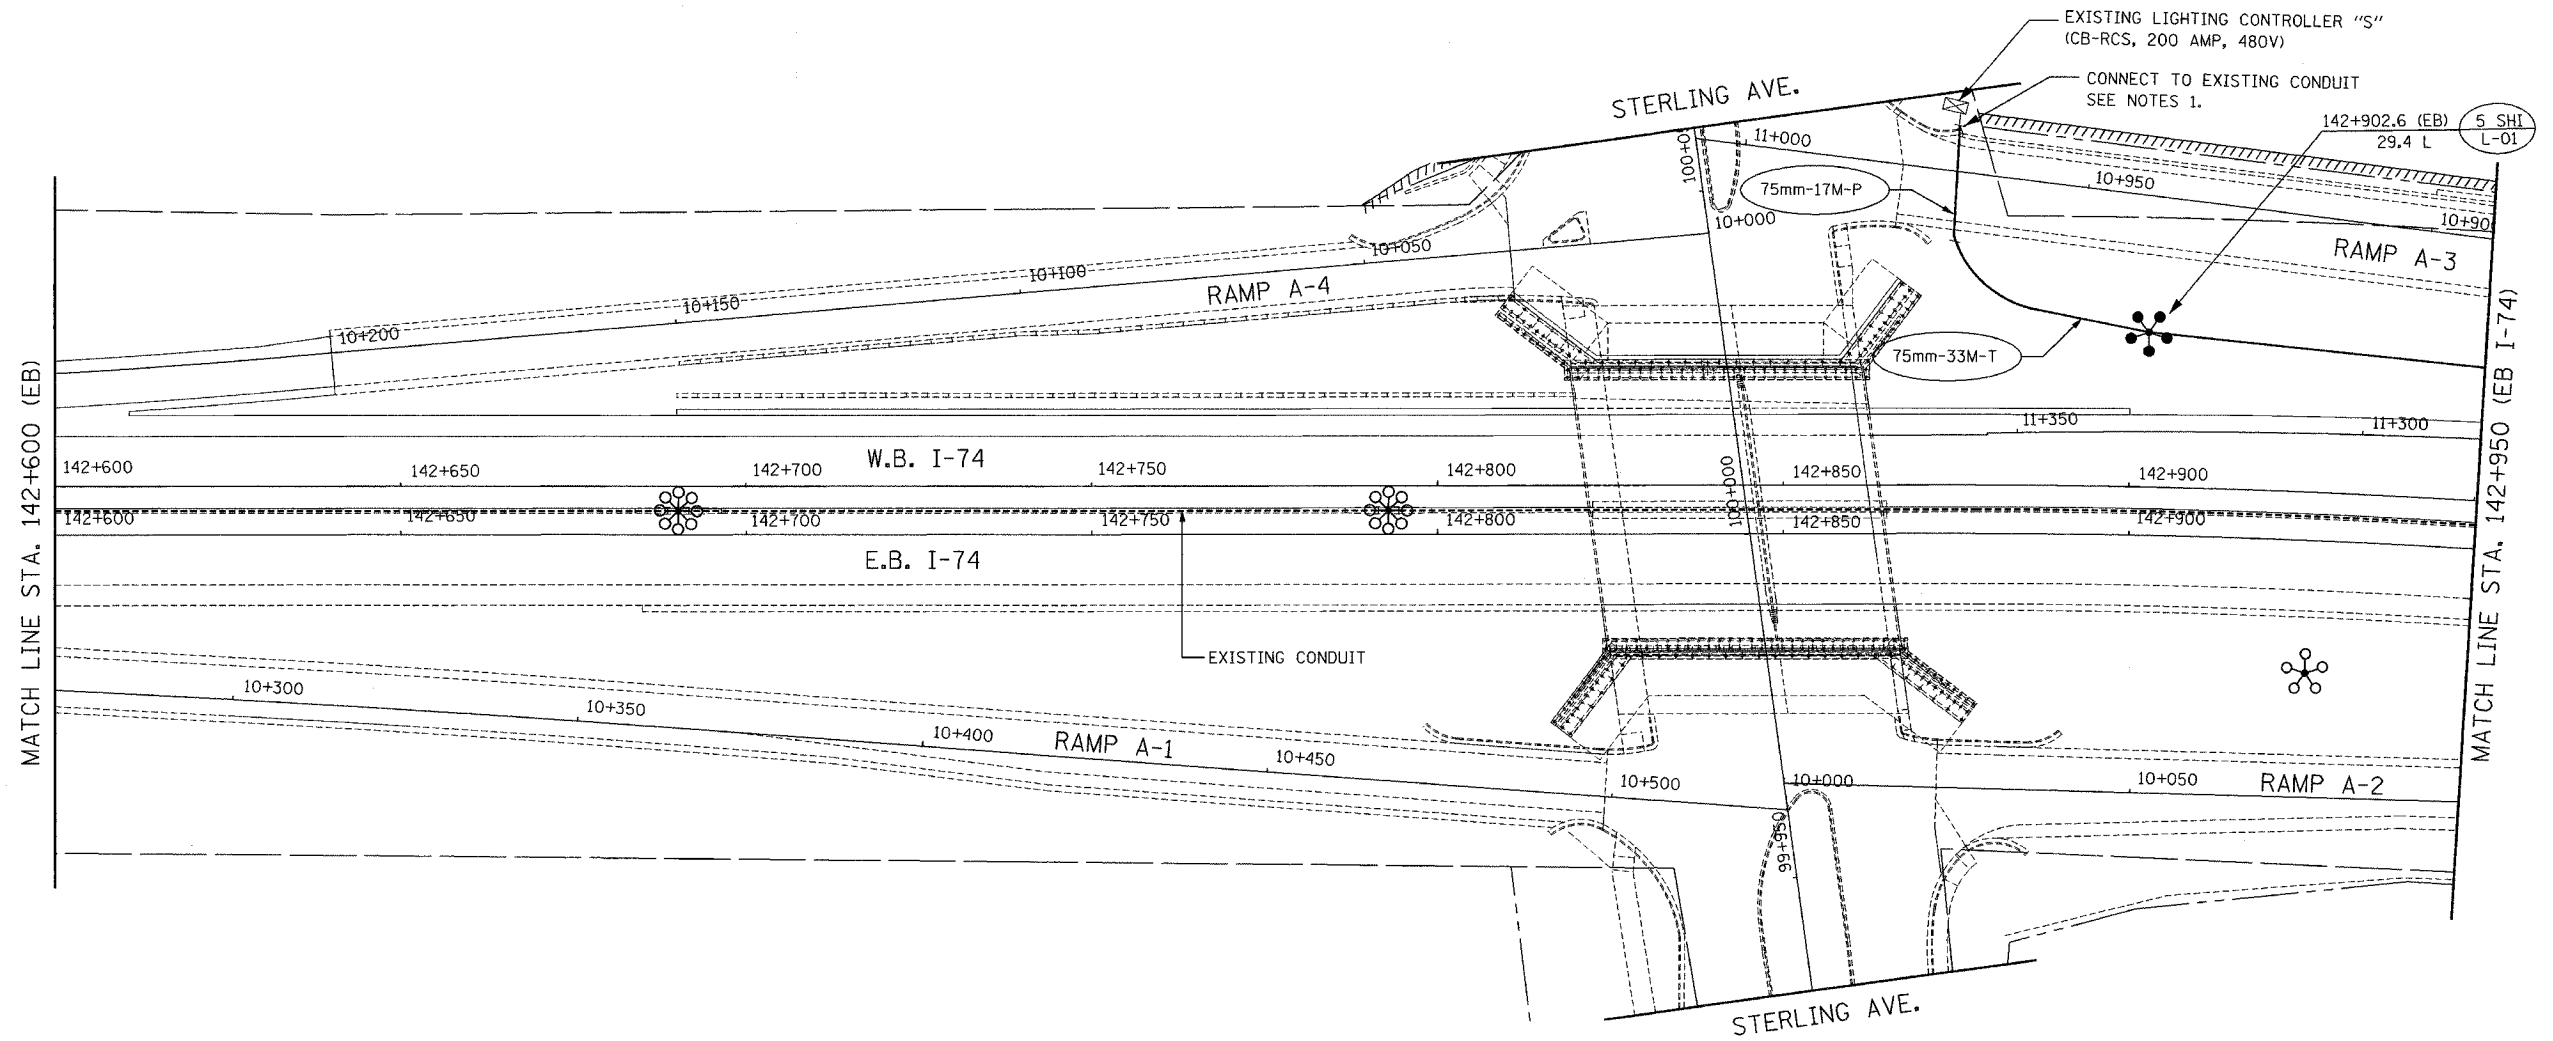

m:\proj\3573\LIGHTING\4-Contract 10\11002-7\at4.dgn

11/2/06 AM

11/15/2004

STREET LIGHTING - BILL OF MATERIAL THIS SHEET


PAY ITEM	UNIT	QUANTITY
CONDUIT IN TRENCH, 75MM DIA., PVC	METER	33.0
CONDUIT PUSHED, 75MM DIA., PVC	METER	17.0
TRENCH AND BACKFILL FOR ELECTRICAL WORK	METER	33.0
LIGHT TOWER FOUNDATION	METER	7.6
HIGH MAST LUMINAIRE, (INSTALL ONLY)	EACH	5
LIGHT TOWER, INSTALL ONLY	EACH	1

- LENGTH IN METERS
- ES: EMBEDDED IN STRUCTURE
 - T: TRENCH
 - P: PUSHED
 - CT: COMMON TRENCH
 - CTT: COMMON TRENCH WITH TRAFFIC SIGNAL CONDUIT (TRENCH AND BACKFILL BY TRAFFIC SIGNAL CONTRACTOR)

PROPOSED CONDUIT CALL-OUT

NOTE:

 - USE CONDUIT COUPLING TO CONNECT PROPOSED TO EXISTING CONDUIT. COST TO BE INCLUDED IN "CONDUIT PUSHED, 75mm DIA., PVC" PAY ITEM.



ab **alfred benesch & company**
CONSULTING ENGINEERS
205 NORTH MICHIGAN AVENUE, CHICAGO, ILLINOIS 60601

REVISIONS	
NAME	DATE

LIGHTING SHEET 9 OF 64

ILLINOIS DEPARTMENT OF TRANSPORTATION
PROPOSED LIGHTING PLAN
I-74
STA. 142+600 TO STA. 142+950

DATE: 11/12/04
DRAWN BY DJK
CHECKED BY MKR