
 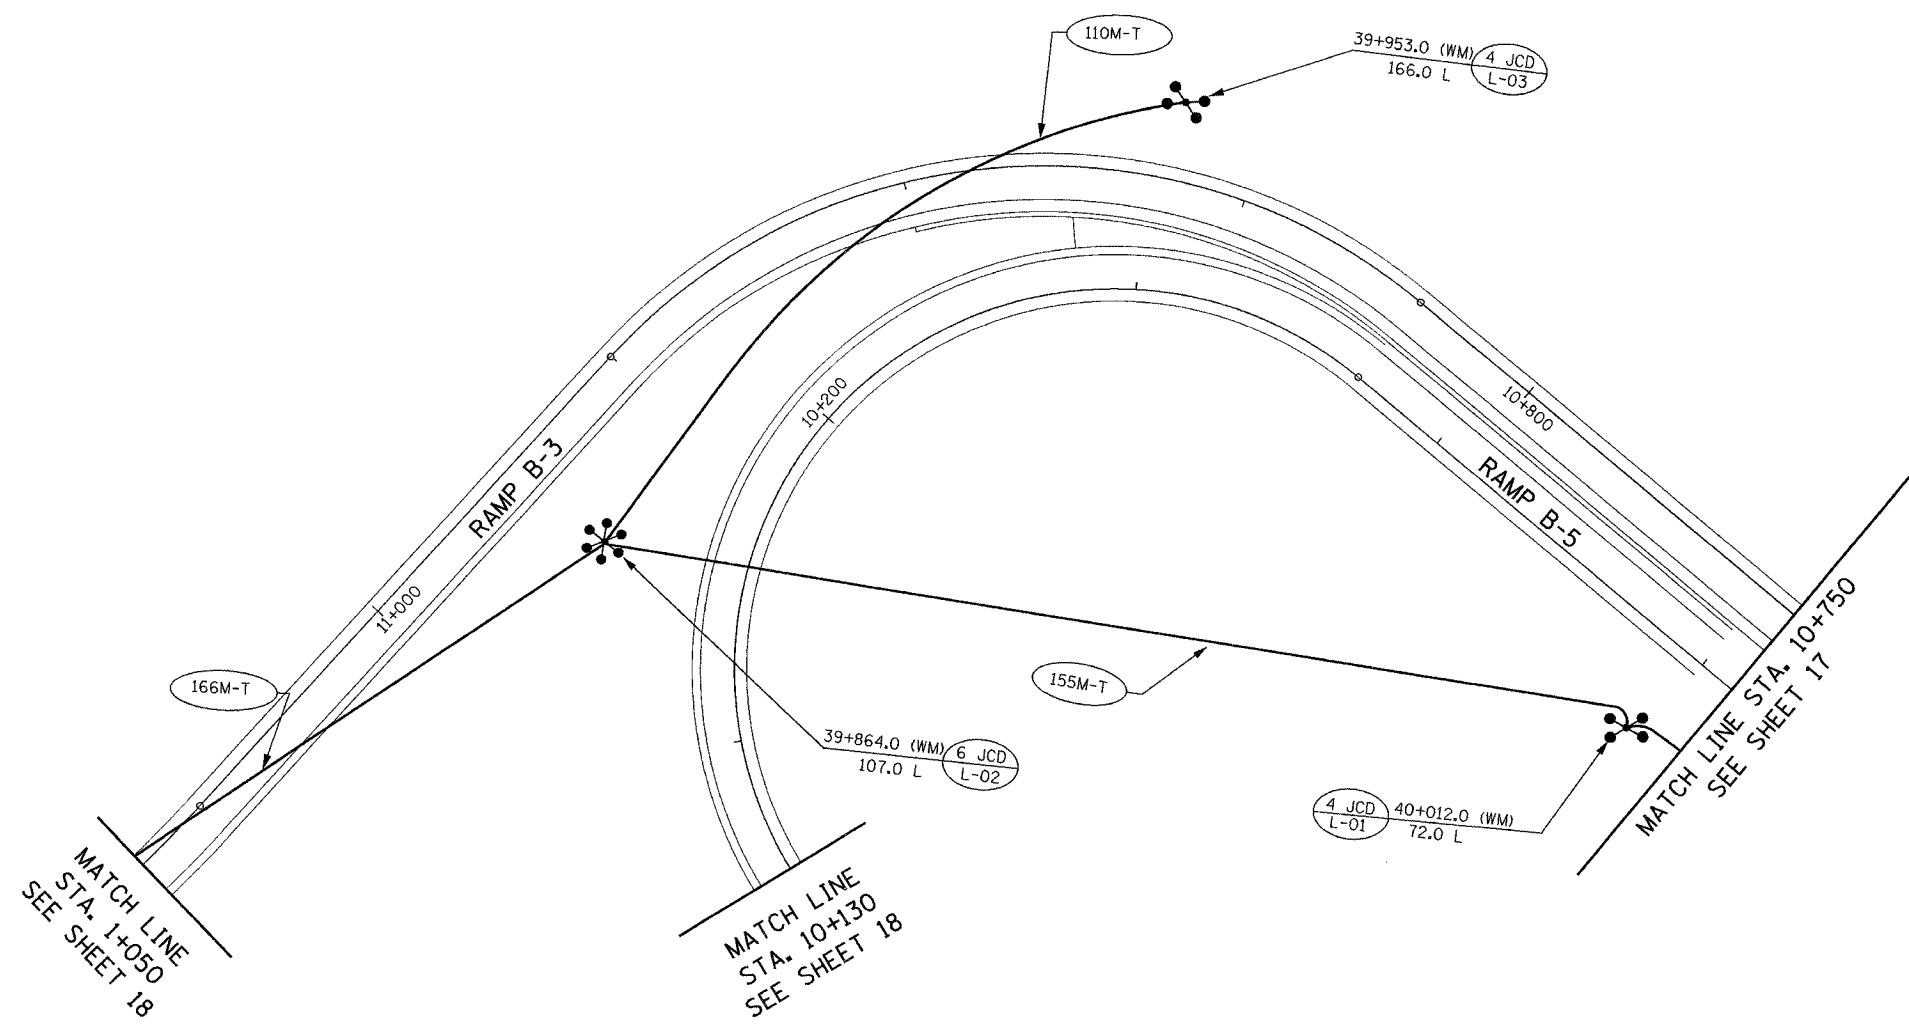



F.A.I. RTE.	SECTION	COUNTY	TOTAL SHEETS	SHEET NO.
74	(72-7R-3)	PEORIA	1360	1803
STA.	TO STA.			
FED. ROAD DIST. NO.	ILLINOIS	FED. AID PROJECT		

CONTRACT NO. 68200



STREET LIGHTING - BILL OF MATERIAL THIS SHEET

PAY ITEM	UNIT	QUANTITY
CONDUIT IN TRENCH, 75MM DIA., PVC	METER	431.0
TRENCH AND BACKFILL FOR ELECTRICAL WORK	METER	431.0
LIGHT TOWER FOUNDATION	METER	18.5
HIGH MAST LUMINAIRE, (INSTALL ONLY)	EACH	14
LIGHT TOWER, INSTALL ONLY	EACH	3

 

**ab** **alfred benesch & company**  
 CONSULTING ENGINEERS  
 205 NORTH MICHIGAN AVENUE, CHICAGO, ILLINOIS 60601

REVISIONS	
NAME	DATE

ILLINOIS DEPARTMENT OF TRANSPORTATION  
 PROPOSED LIGHTING PLAN  
 WAR MEMORIAL DR. INTERCHANGE  
 RAMPS B-3 & B-5  
 DRAWN BY DJK  
 CHECKED BY MKR  
 DATE: 11/12/04

10:50:03 AM 11/15/2004 m:\p\13573\LIGHT\ING\74\Contract\10\11006-7\avm\dgn