


F.A.I. RTE.	SECTION	COUNTY	TOTAL SHEETS	SHEET NO.
74	(72-7R-3)	PEORIA	136	1204
STA.	TO STA.			
FED. ROAD DIST. NO.	ILLINOIS	FED. AID PROJECT		


CONTRACT NO. 68200

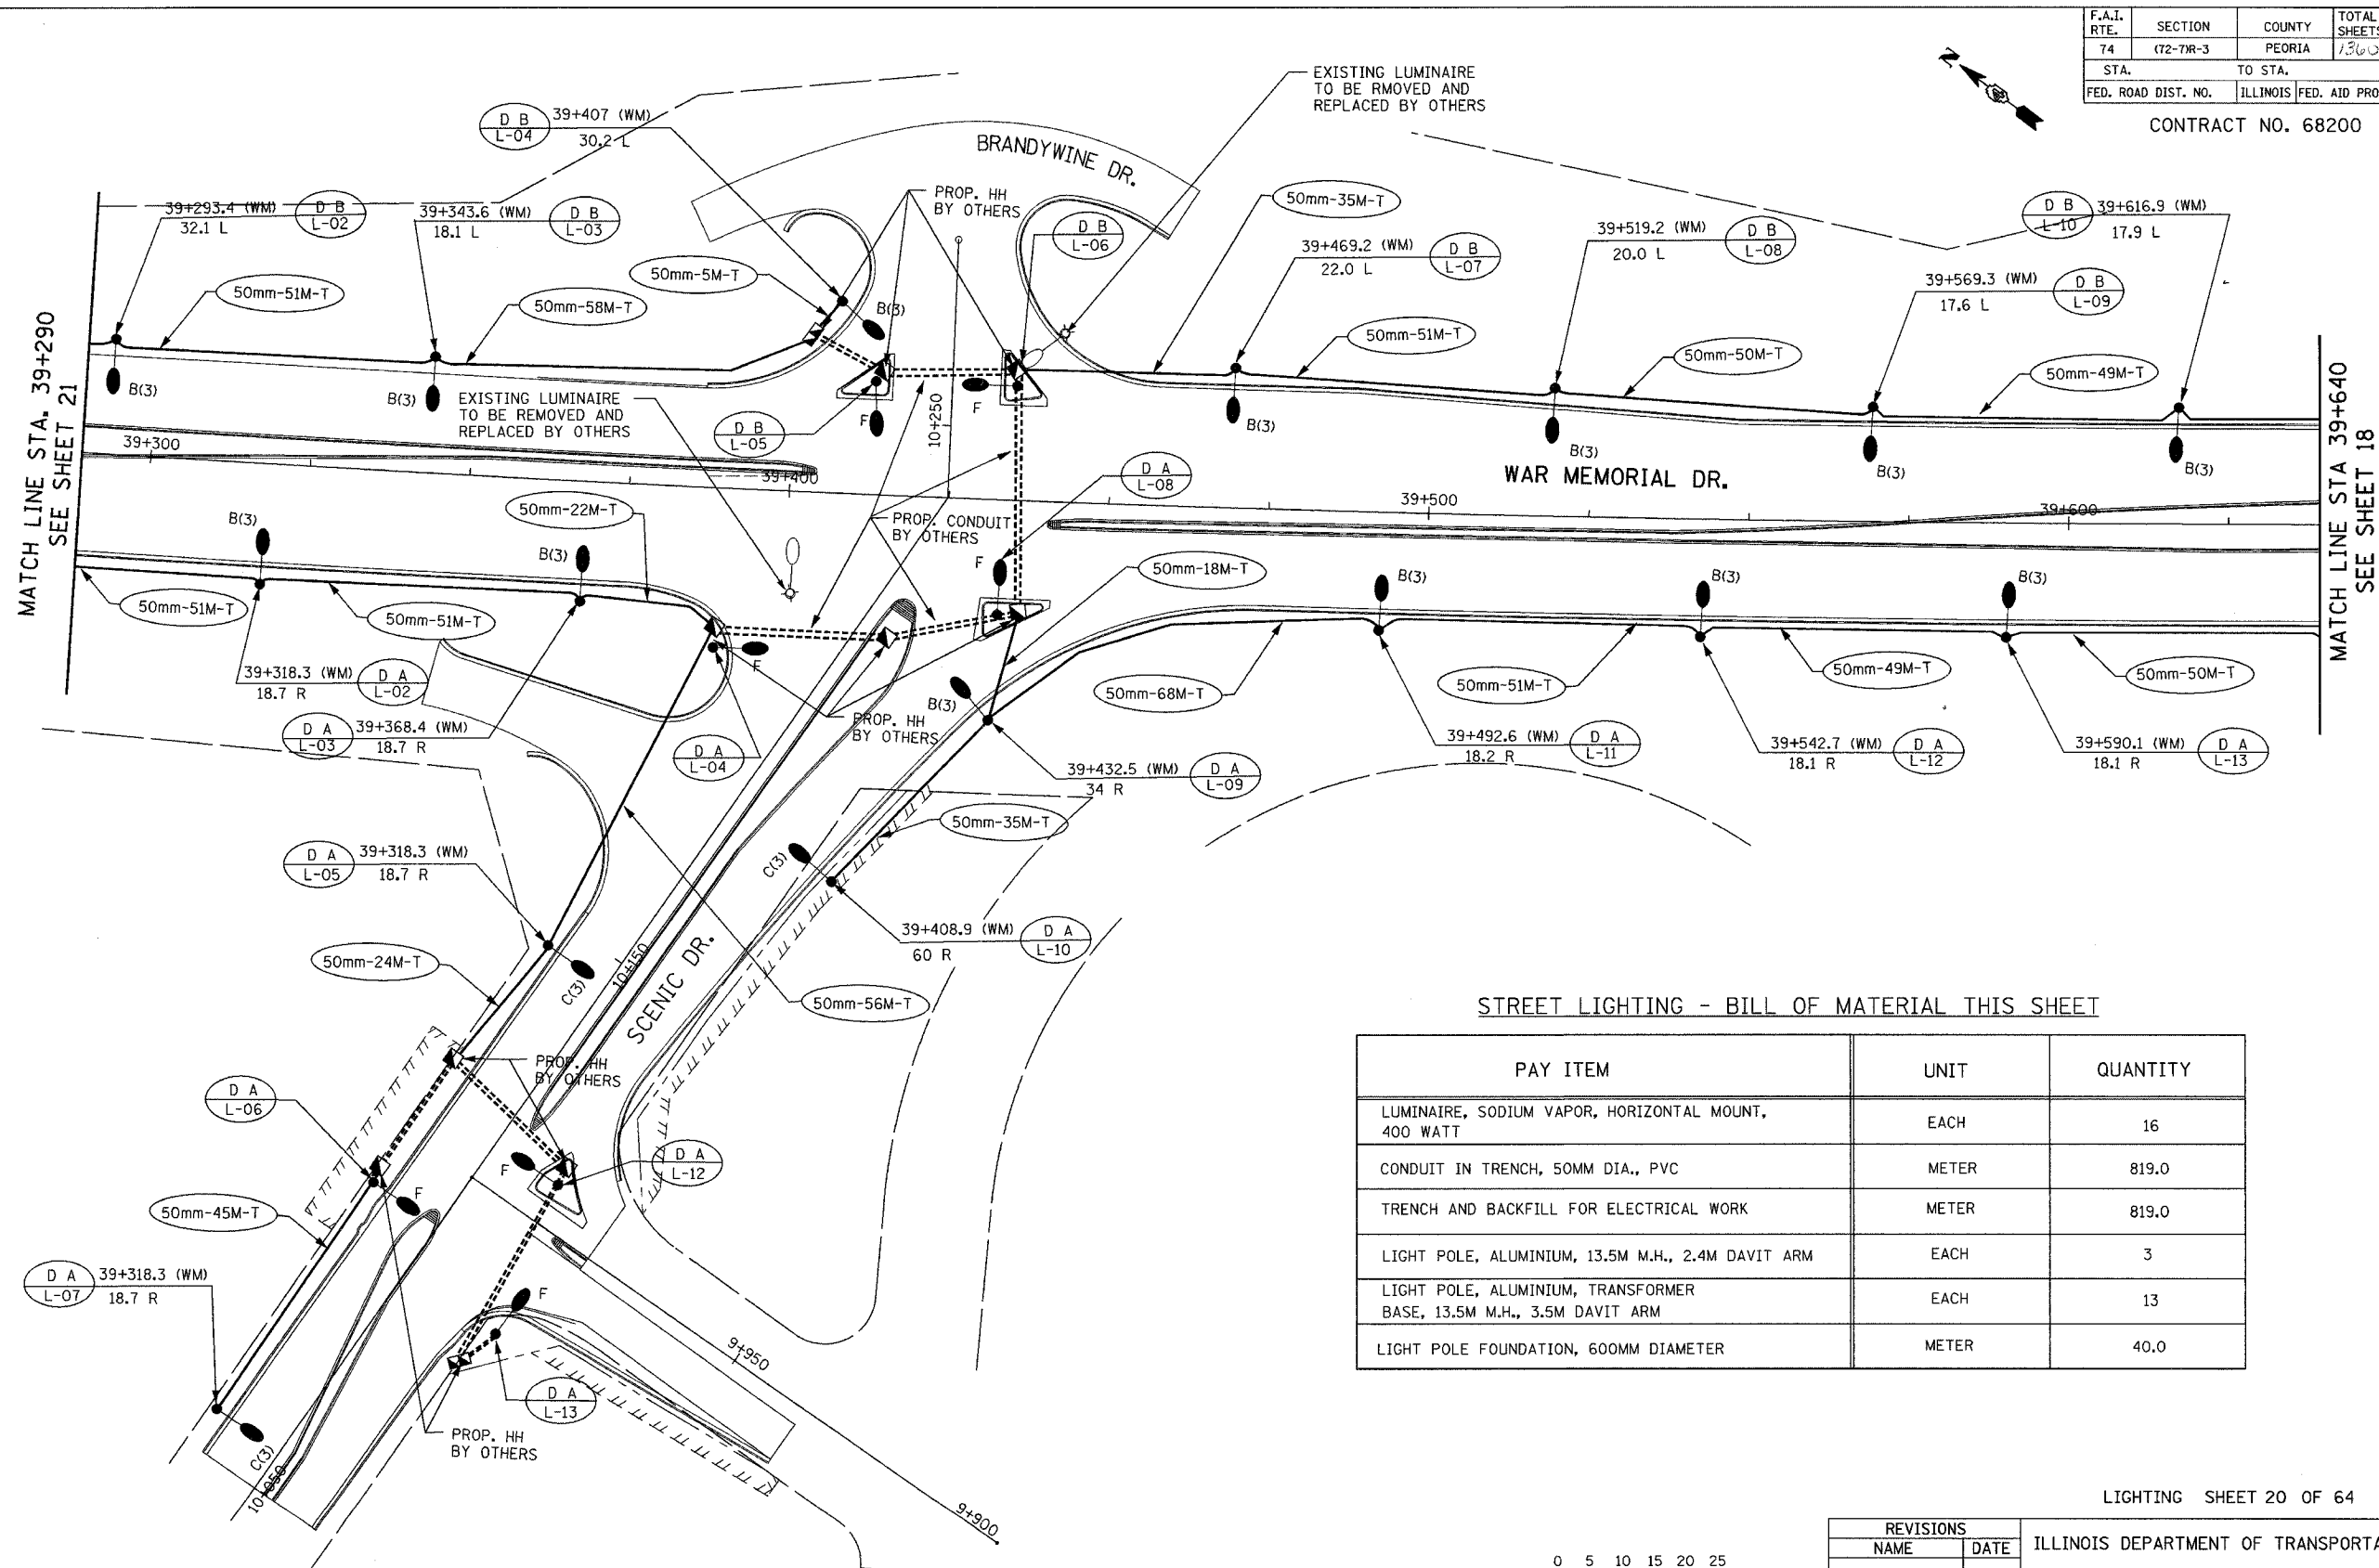

STREET LIGHTING - BILL OF MATERIAL THIS SHEET

PAY ITEM	UNIT	QUANTITY
LUMINAIRE, SODIUM VAPOR, HORIZONTAL MOUNT, 400 WATT	EACH	16
CONDUIT IN TRENCH, 50MM DIA., PVC	METER	819.0
TRENCH AND BACKFILL FOR ELECTRICAL WORK	METER	819.0
LIGHT POLE, ALUMINIUM, 13.5M M.H., 2.4M DAVIT ARM	EACH	3
LIGHT POLE, ALUMINIUM, TRANSFORMER BASE, 13.5M M.H., 3.5M DAVIT ARM	EACH	13
LIGHT POLE FOUNDATION, 600MM DIAMETER	METER	40.0

 LIGHTING SHEET 20 OF 64



ab **alfred benesch & company**
CONSULTING ENGINEERS
205 NORTH MICHIGAN AVENUE, CHICAGO, ILLINOIS 60601

REVISIONS	
NAME	DATE

ILLINOIS DEPARTMENT OF TRANSPORTATION

PROPOSED LIGHTING PLAN
WAR MEMORIAL DR.
STA. 39+290 TO STA. 39+640

DRAWN BY DJK
CHECKED BY MKR
DATE: 1/25/2005

M:\proj\35573\LIGHTING\4Contract 10\11002-Town.dgn

3:18:25 PM

1/25/2005