
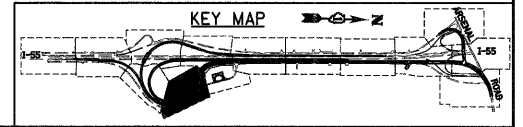


SINGH
 300 W. ADAMS ST.
 CHICAGO, IL 60606
 SINGH & ASSOCIATES, INC.
 CONSULTING ENGINEERS
 TEL: (312) 629-0240
 FAX: (312) 629-8449

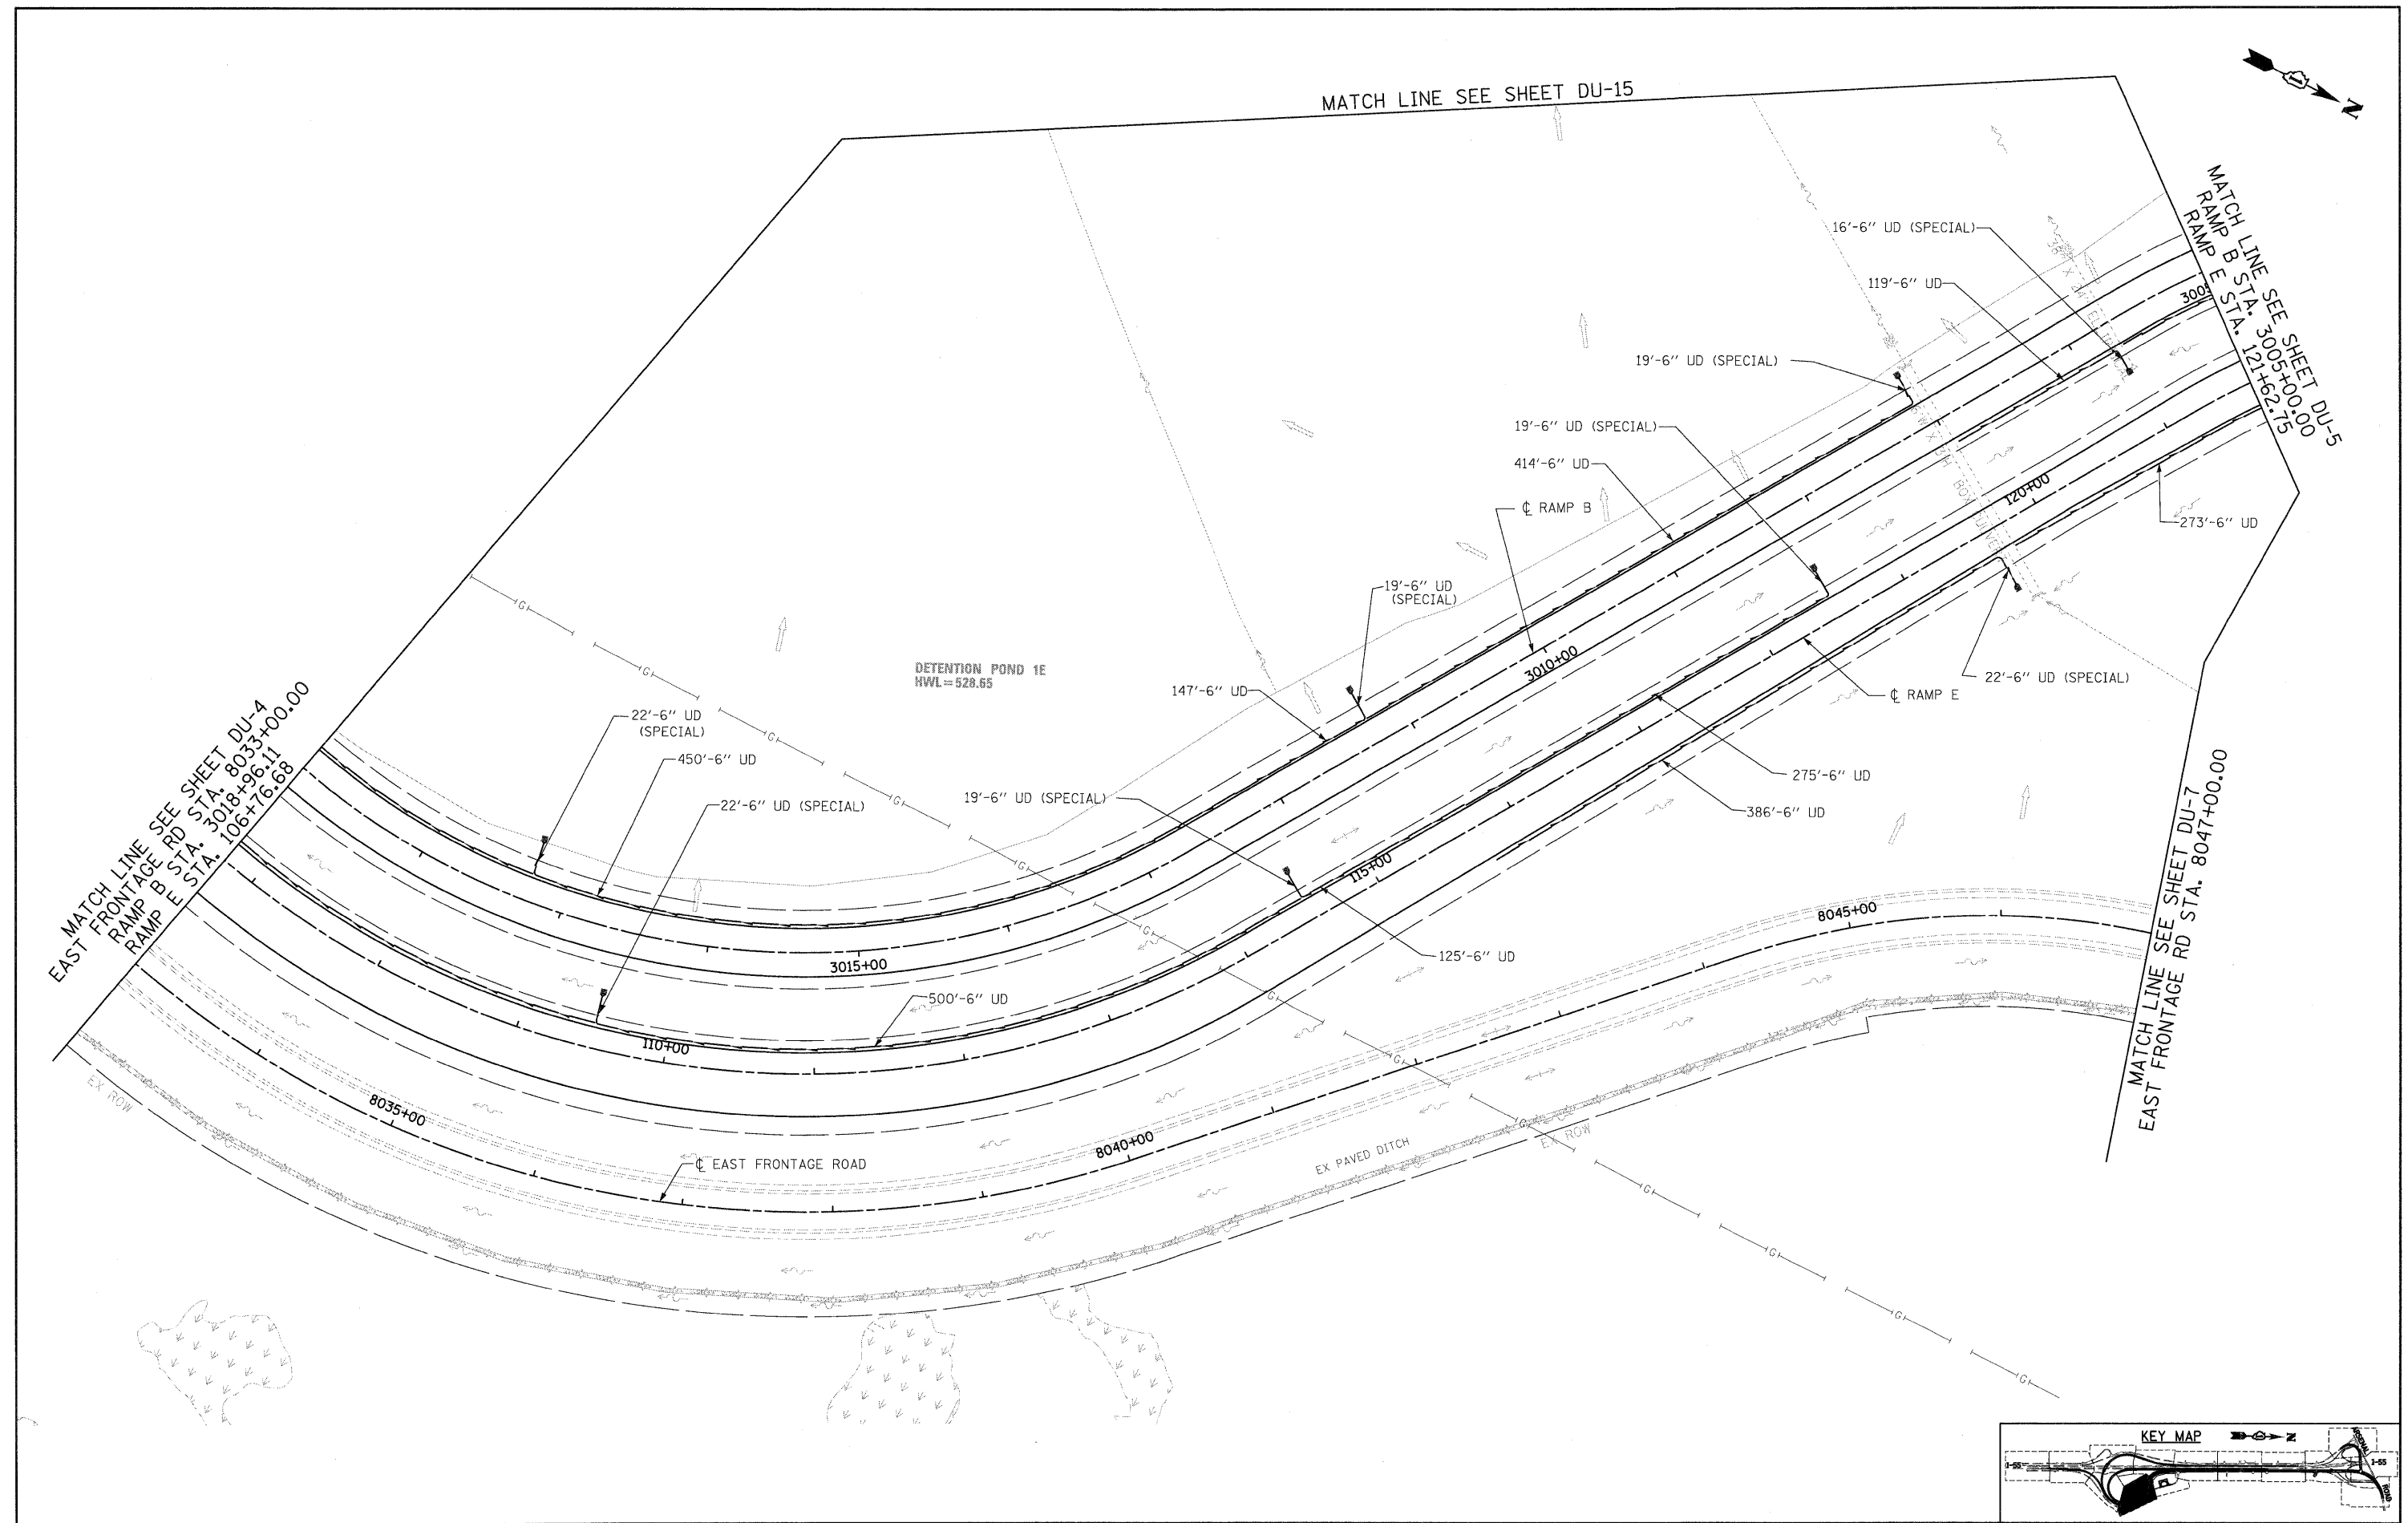

FILE NAME = D162F12-SHT-DRAIN06.dgn	USER NAME = TKluagal	DESIGNED - PKT	REVISED -
		DRAWN - VP	REVISED -
		CHECKED - CL	REVISED -
		DATE - 2/4/11	REVISED -
PLOT SCALE = 1:50			
PLOT DATE = 2/3/2011			

**STATE OF ILLINOIS
 DEPARTMENT OF TRANSPORTATION**

DRAINAGE AND UTILITY PLAN

SCALE: 1"=50' SHEET NO. 6 OF 25 SHEETS STA. TO STA.

F.A.I. RTE.	SECTION	COUNTY	TOTAL SHEETS	SHEET NO.
55	99-2HB-2B-1	WILL	756	172
CONTRACT NO. 60F12				
FED. ROAD DIST. NO. 1 ILLINOIS FED. AID PROJECT				